




4-WEST ELEVATION
SCALE 1:75

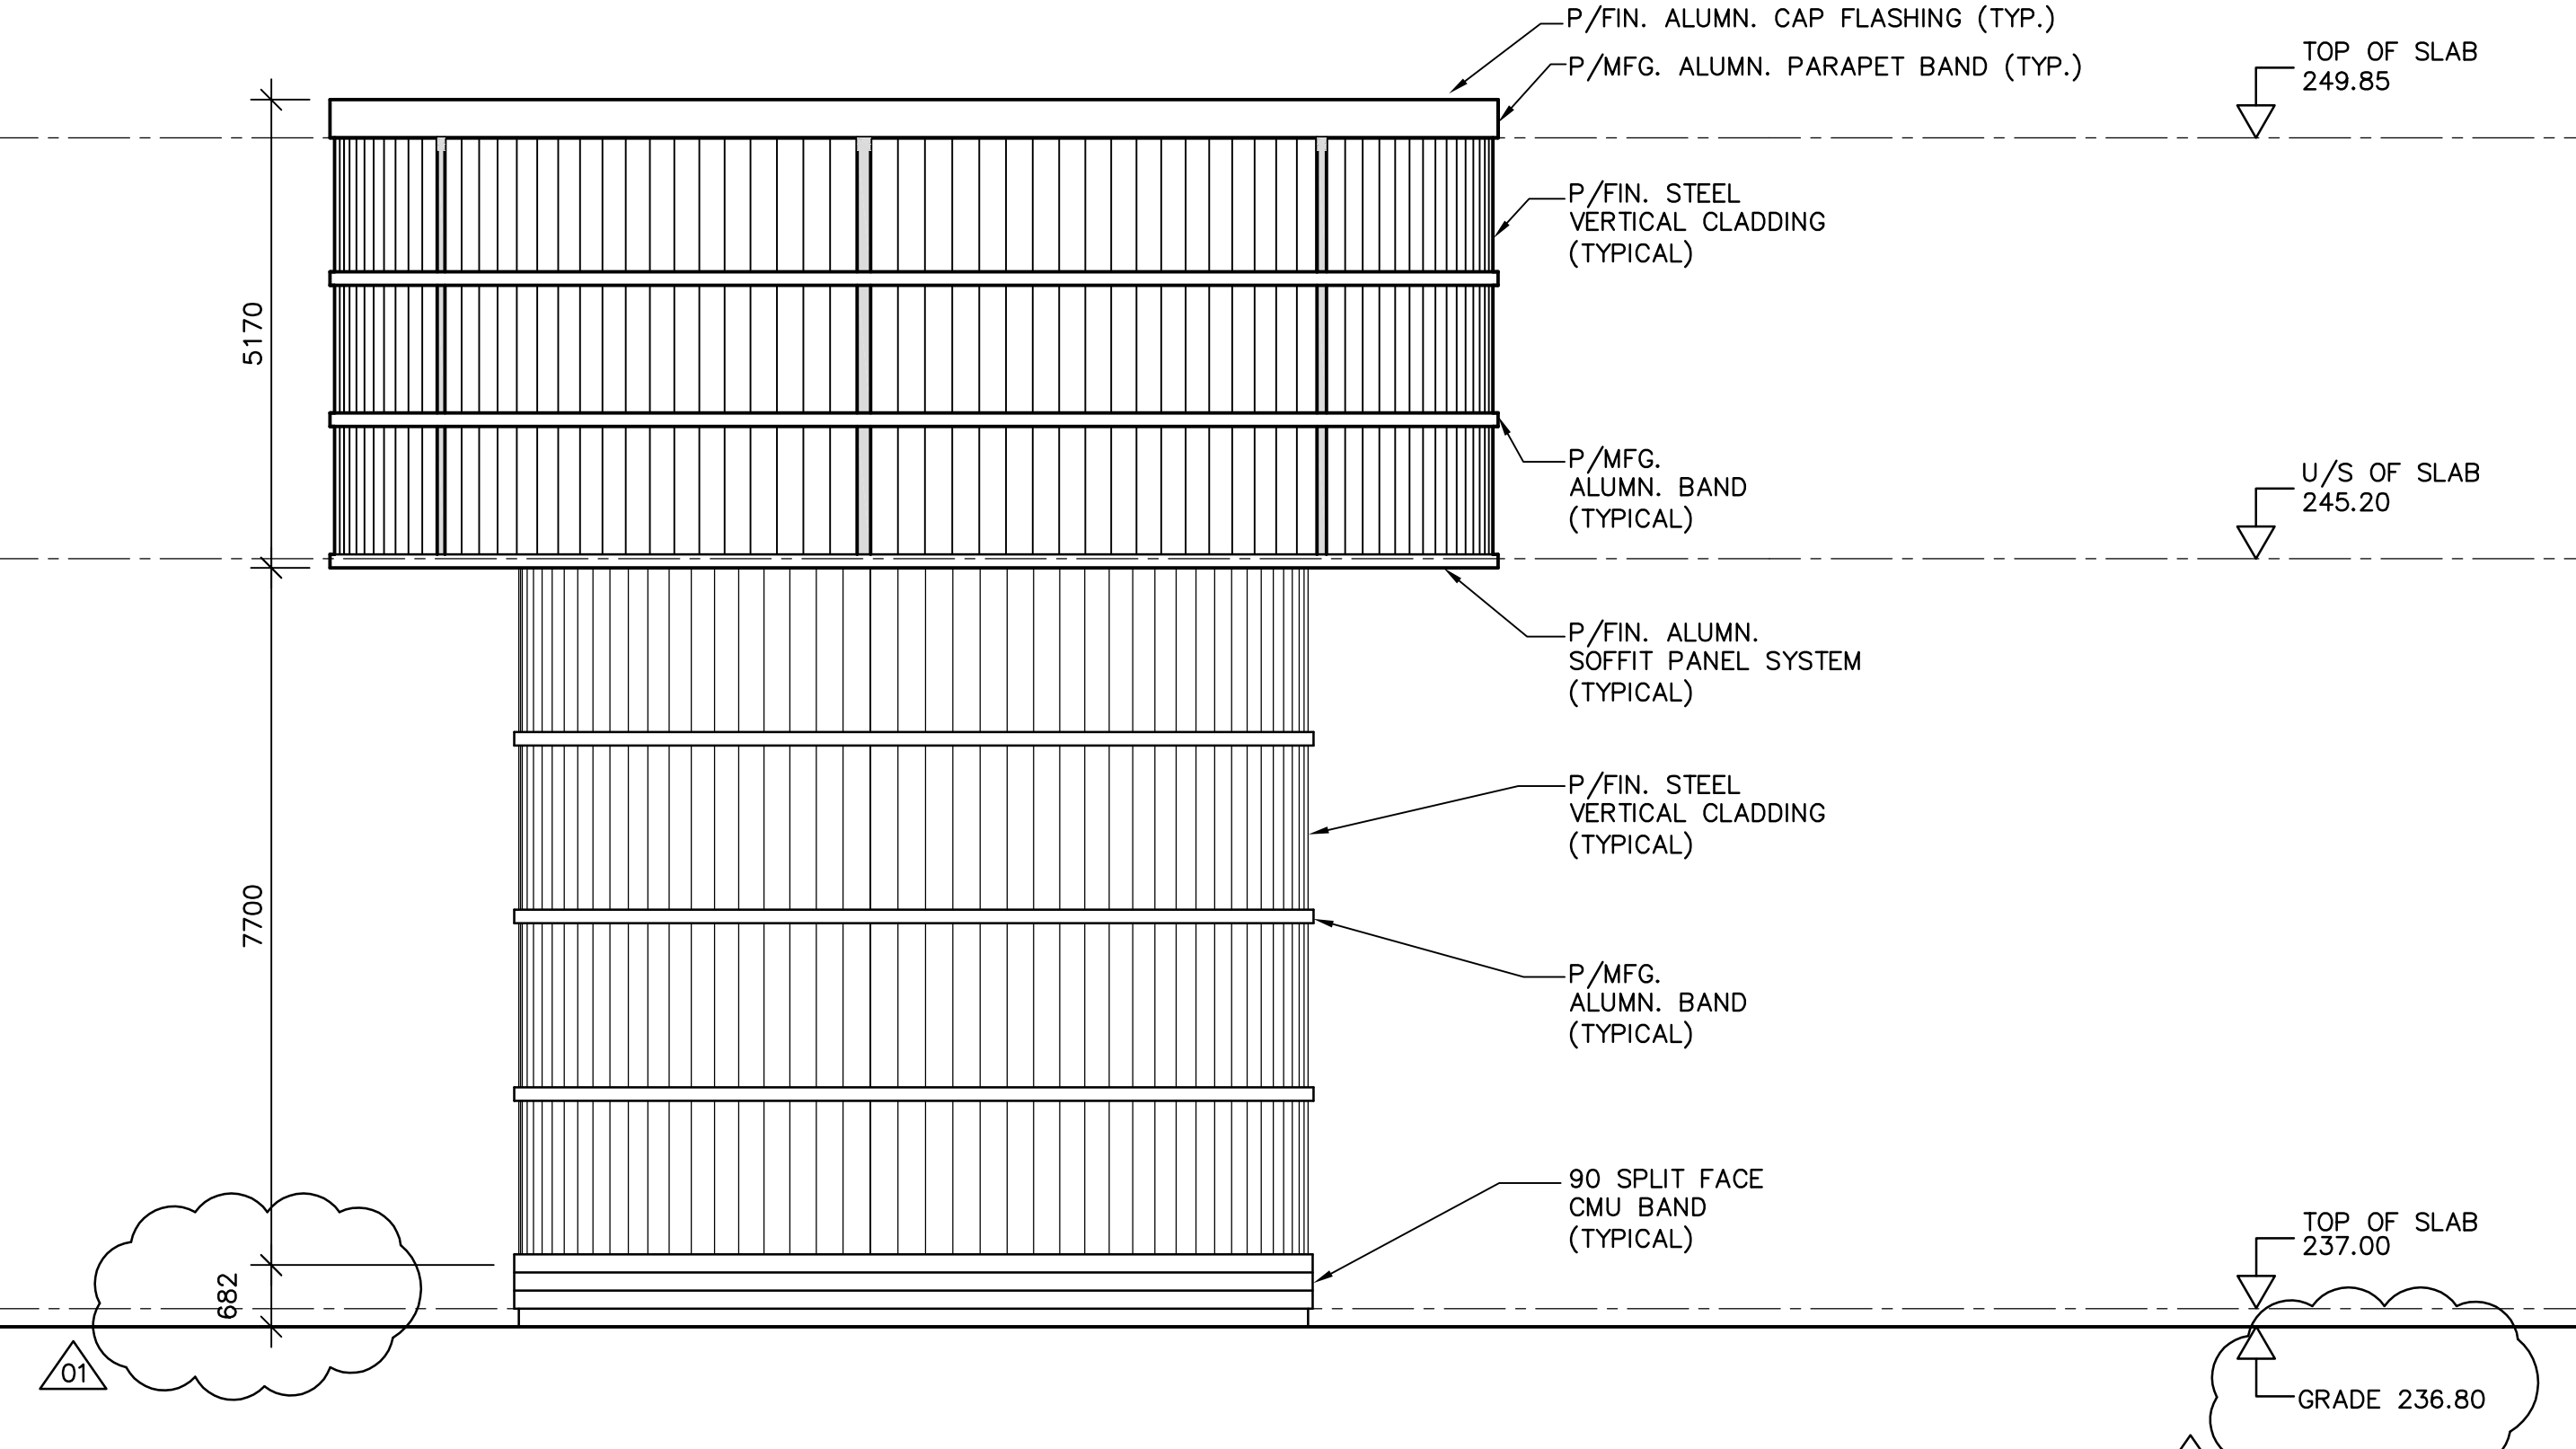

3-SOUTH ELEVATION
SCALE 1:75

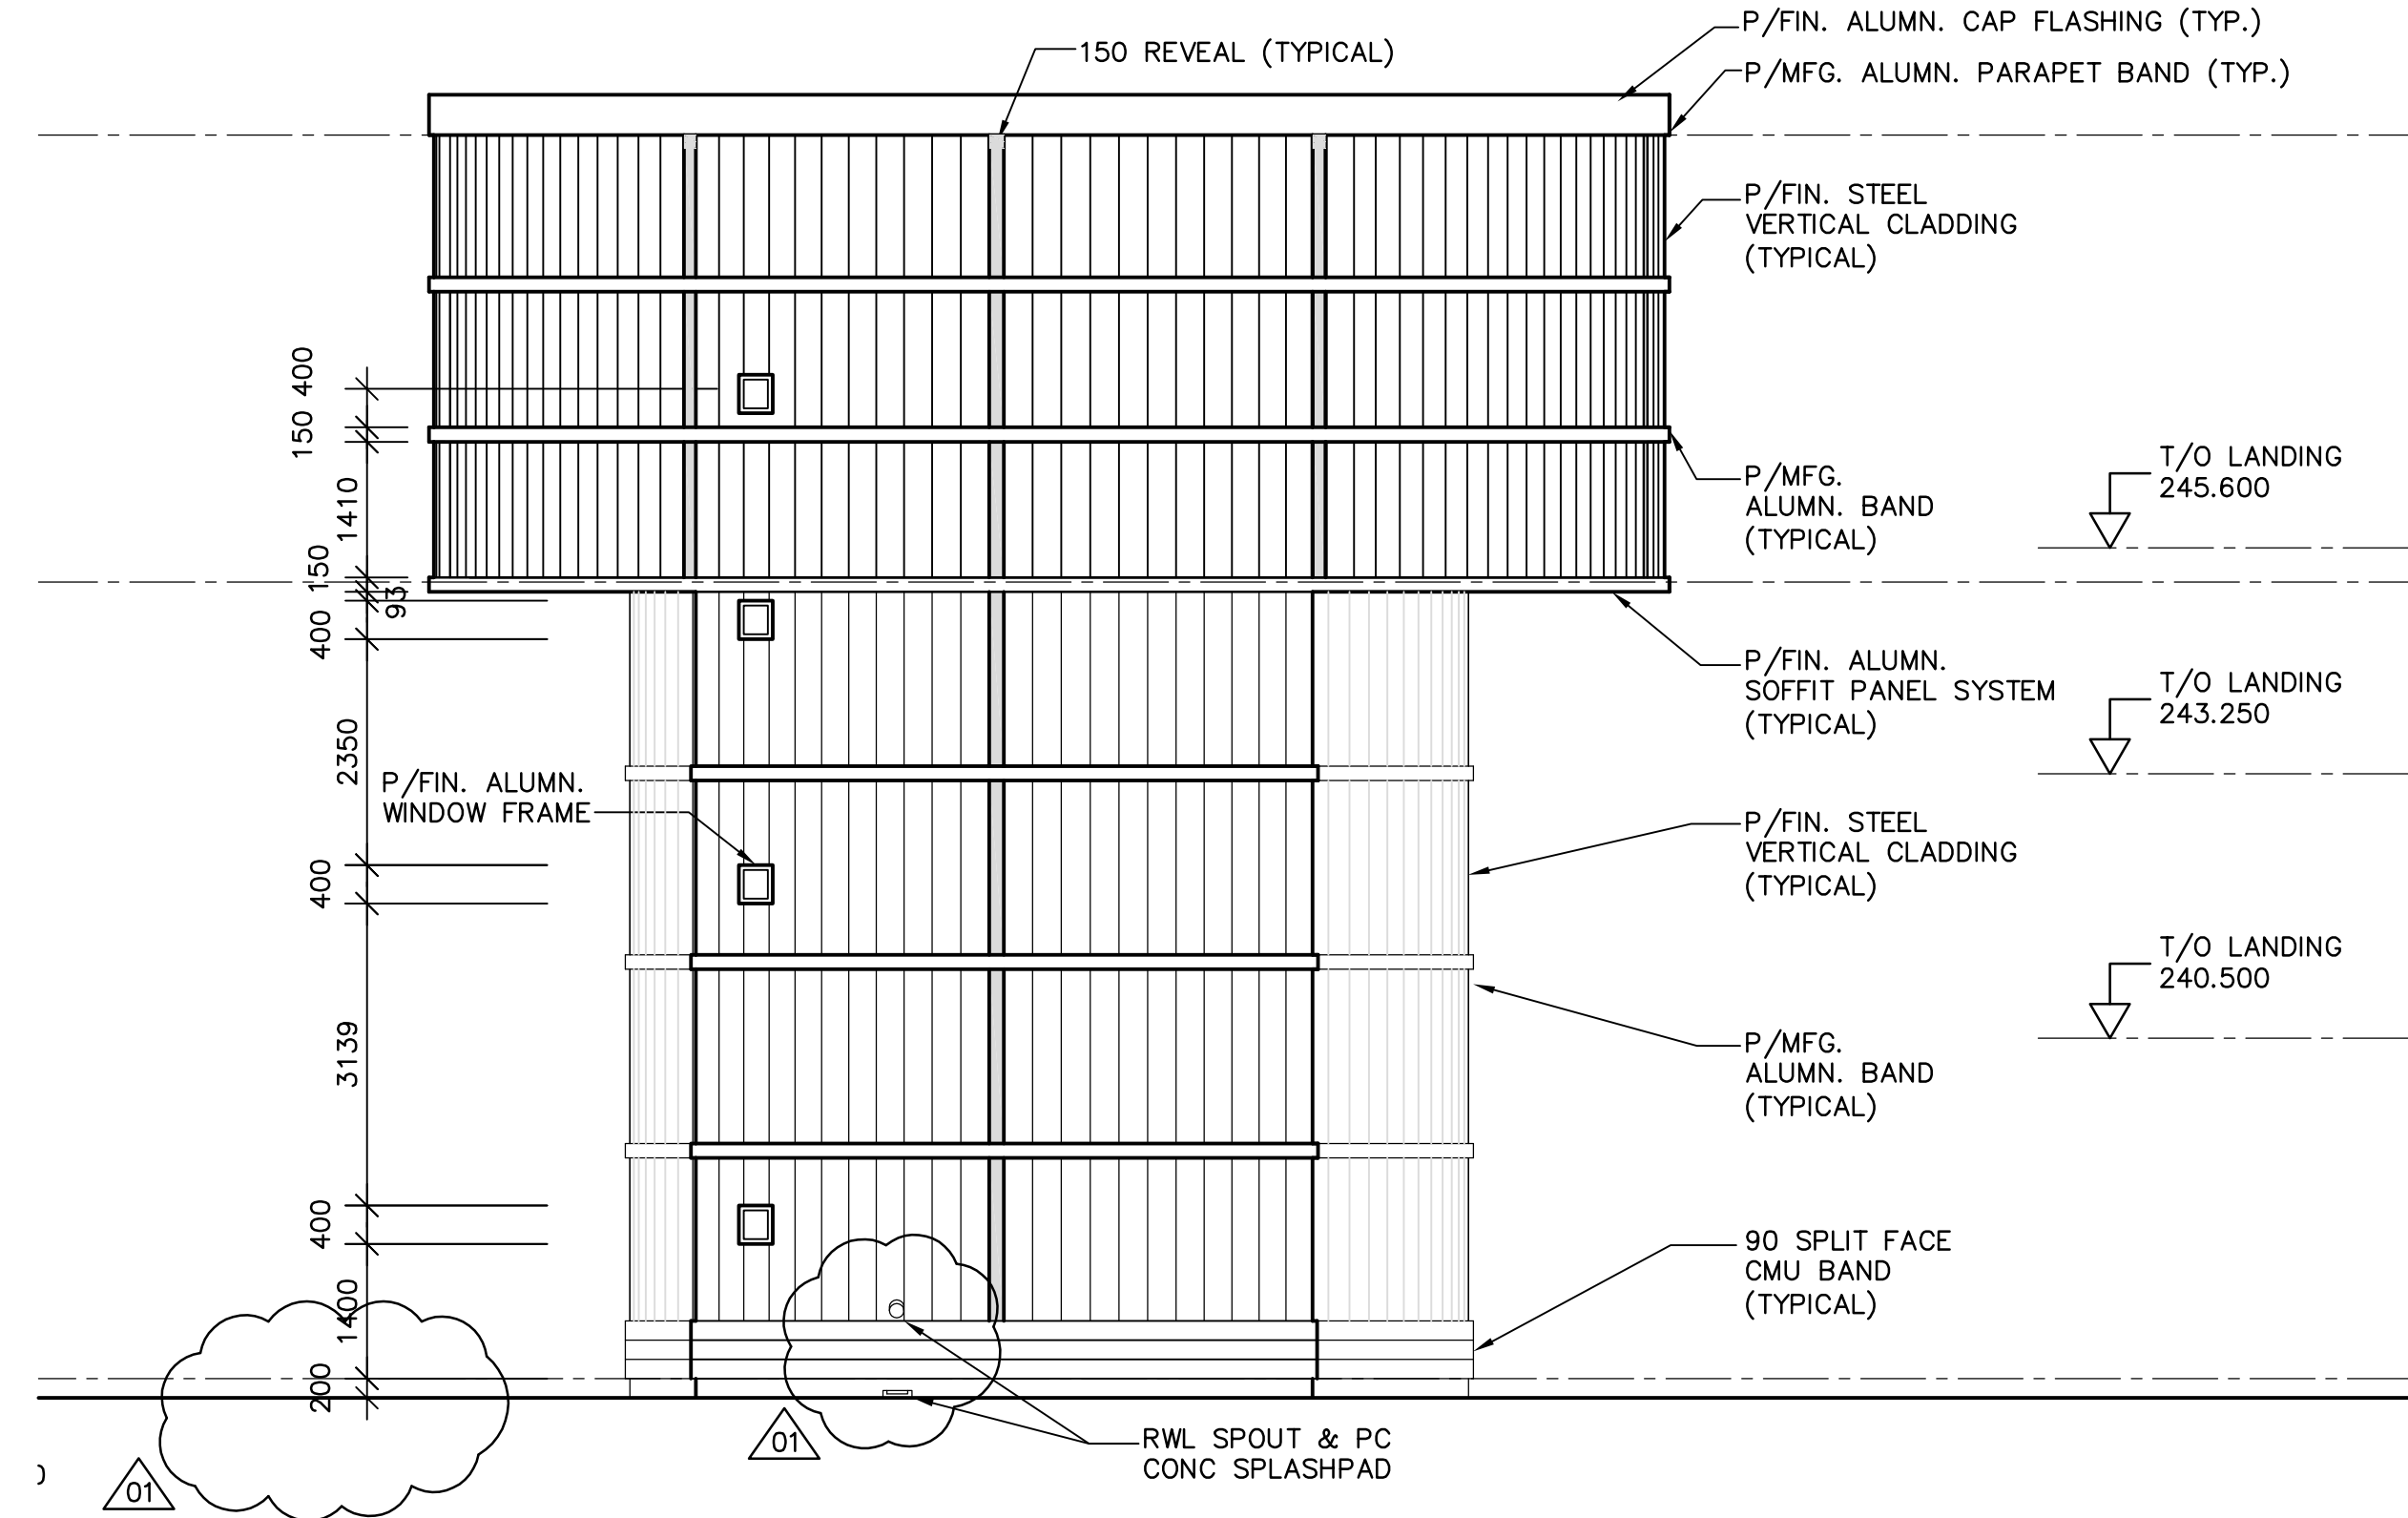

1-NORTH ELEVATION
SCALE 1:75

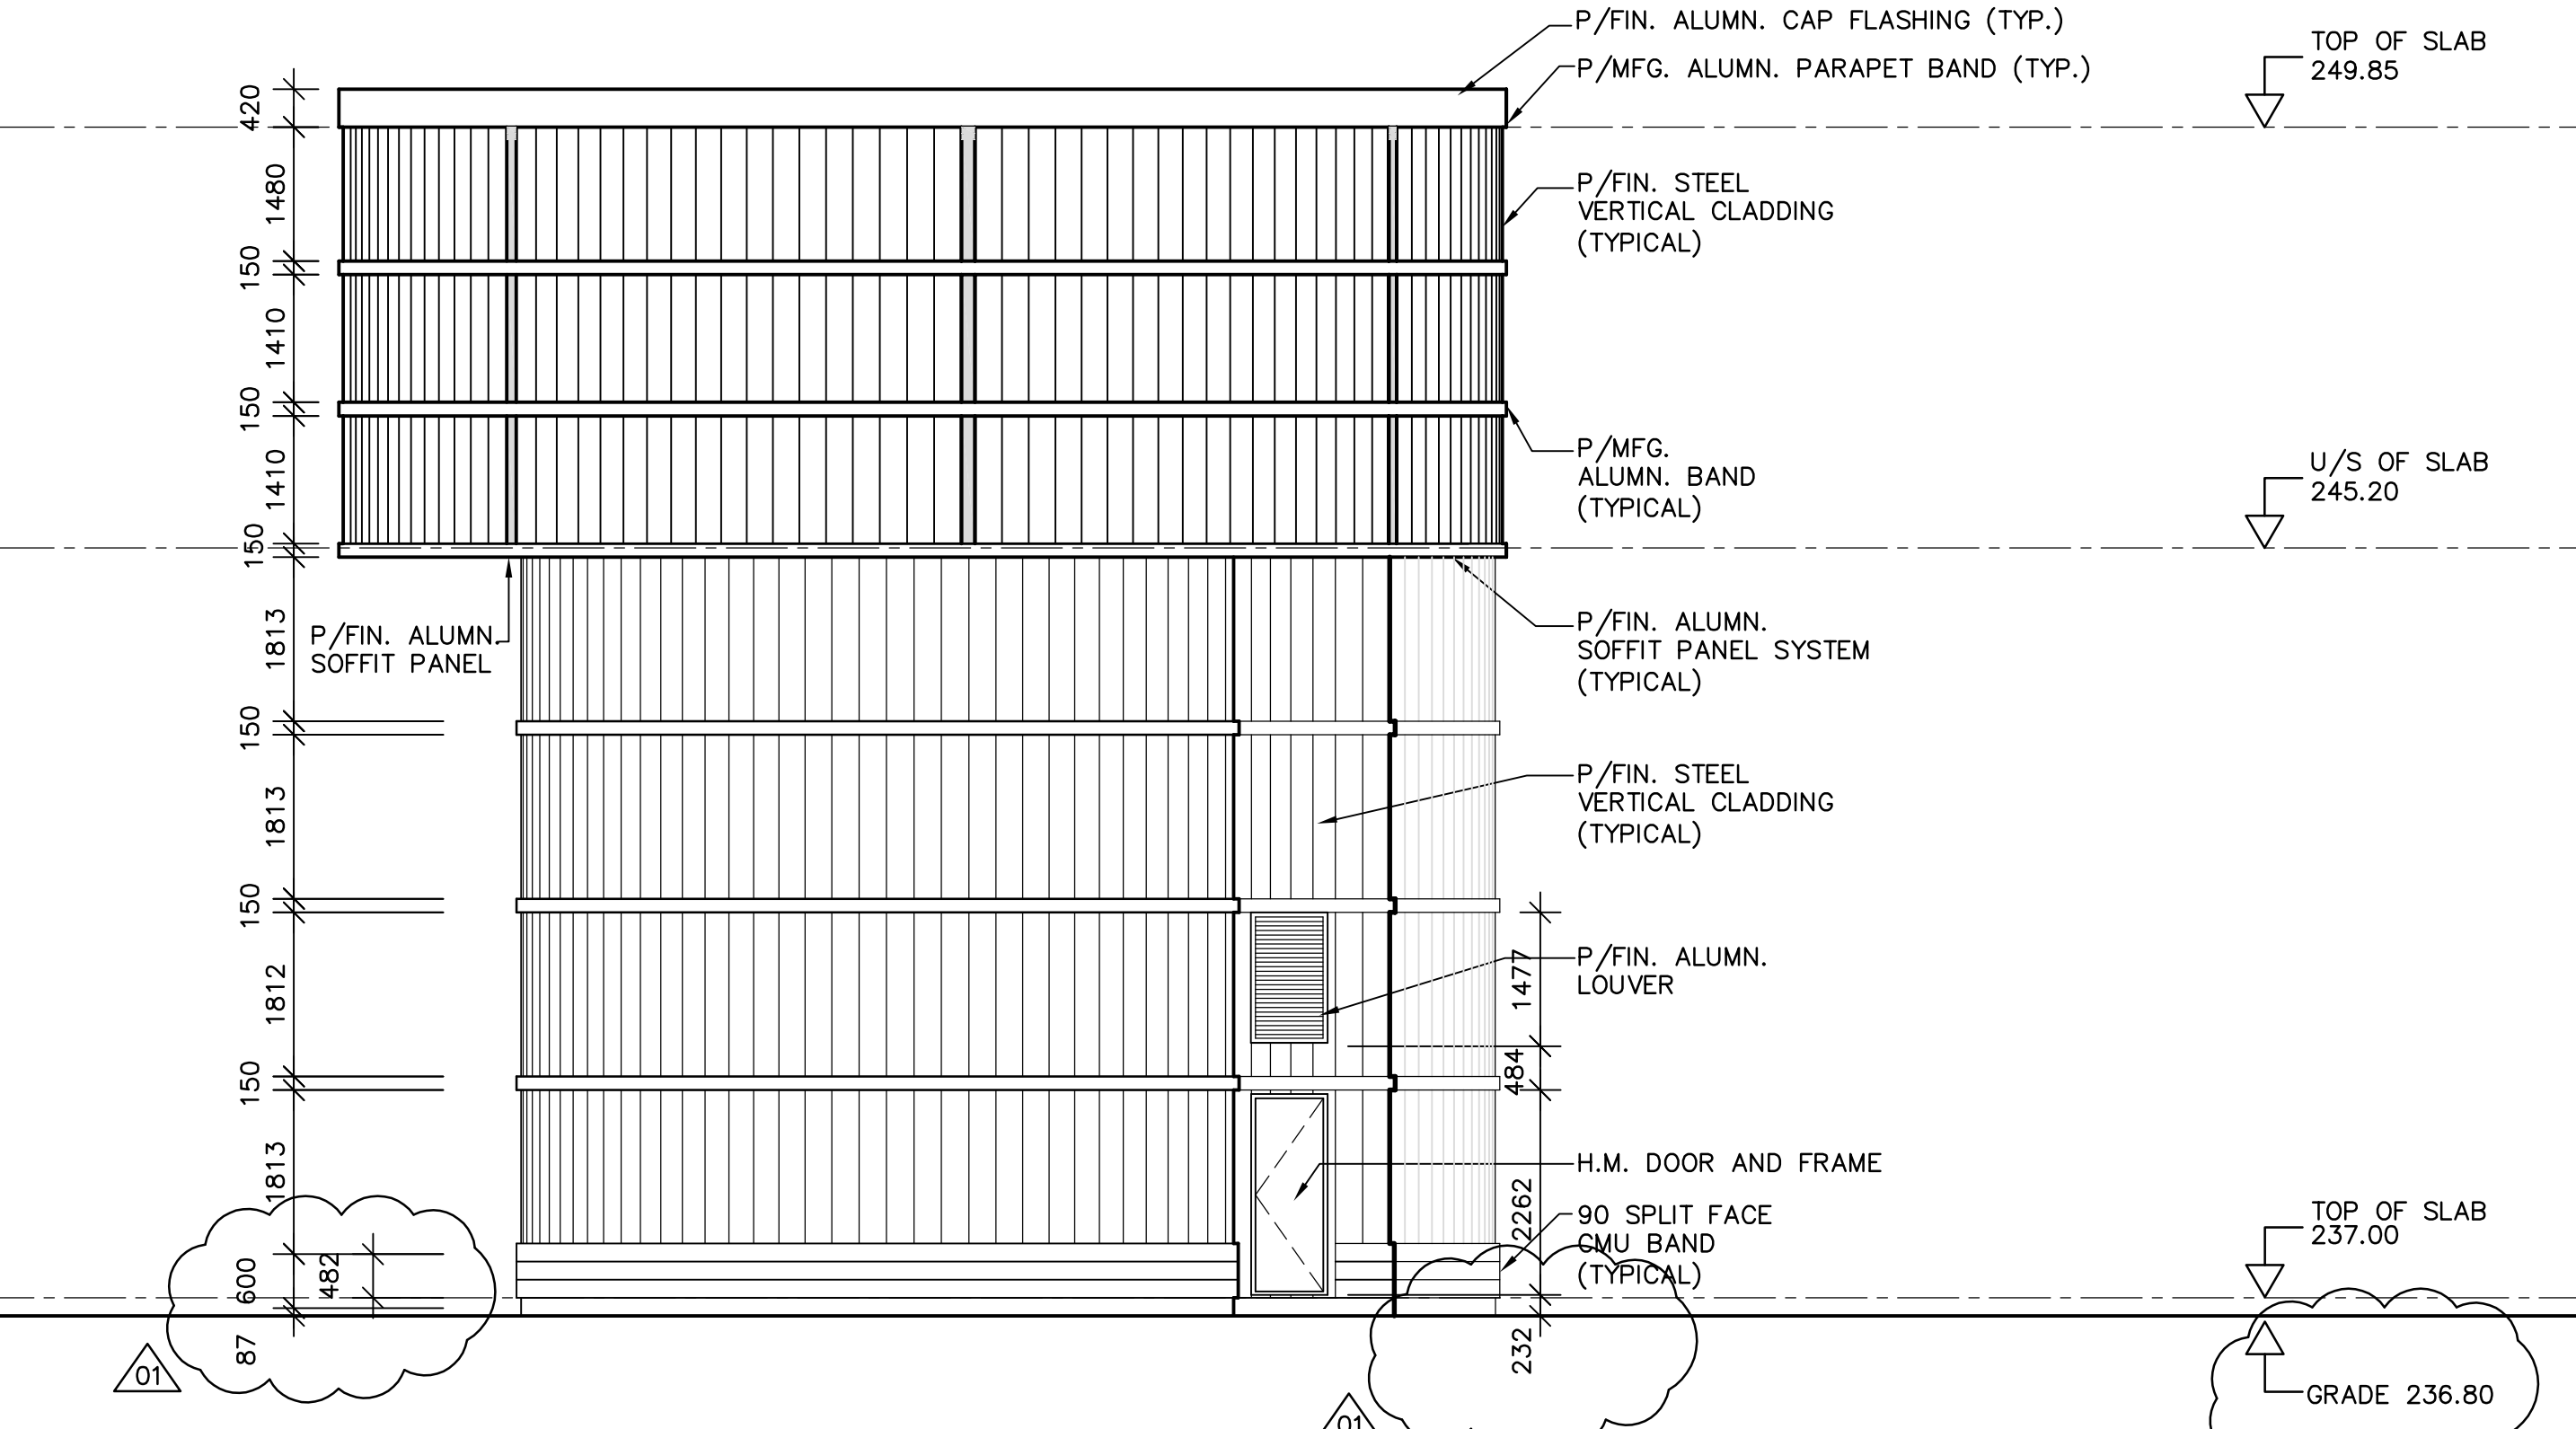

2-EAST ELEVATION
SCALE 1:75



NO.	REVISIONS	DATE	BY
01	37-2006 ADDENDUM 1	06/05/24	LK
00	ISSUED FOR TENDER	06/05/03	LK

DESIGNED BY	TWS	CHECKED BY	TWS
DRAWN BY	SM	APPROVED BY	AHL
SCALE:	AS NOTED	RELEASED FOR CONSTRUCTION BY:	R. SOROKOWSKI
DATE	2006/04/21	DATE	2006/05/03

ENGINEER'S SEAL	ORIGINAL SIGNED BY	N. COOPER
		2006/05/03
CONSULTANT DRAWING NO.	WY-B0300	

THE CITY OF WINNIPEG
WATER AND WASTE DEPARTMENT
ENGINEERING DIVISION

WATER TREATMENT PLANT
YARD PIPING AND VALVE CHAMBERS
SURGE TOWER CONSTRUCTION

ARCHITECTURAL ELEVATIONS

CITY FILE NUMBER
SHEET OF
CITY DRAWING NUMBER
1-0601Y-A-B0300-001-01