




4-WEST ELEVATION
SCALE 1:75

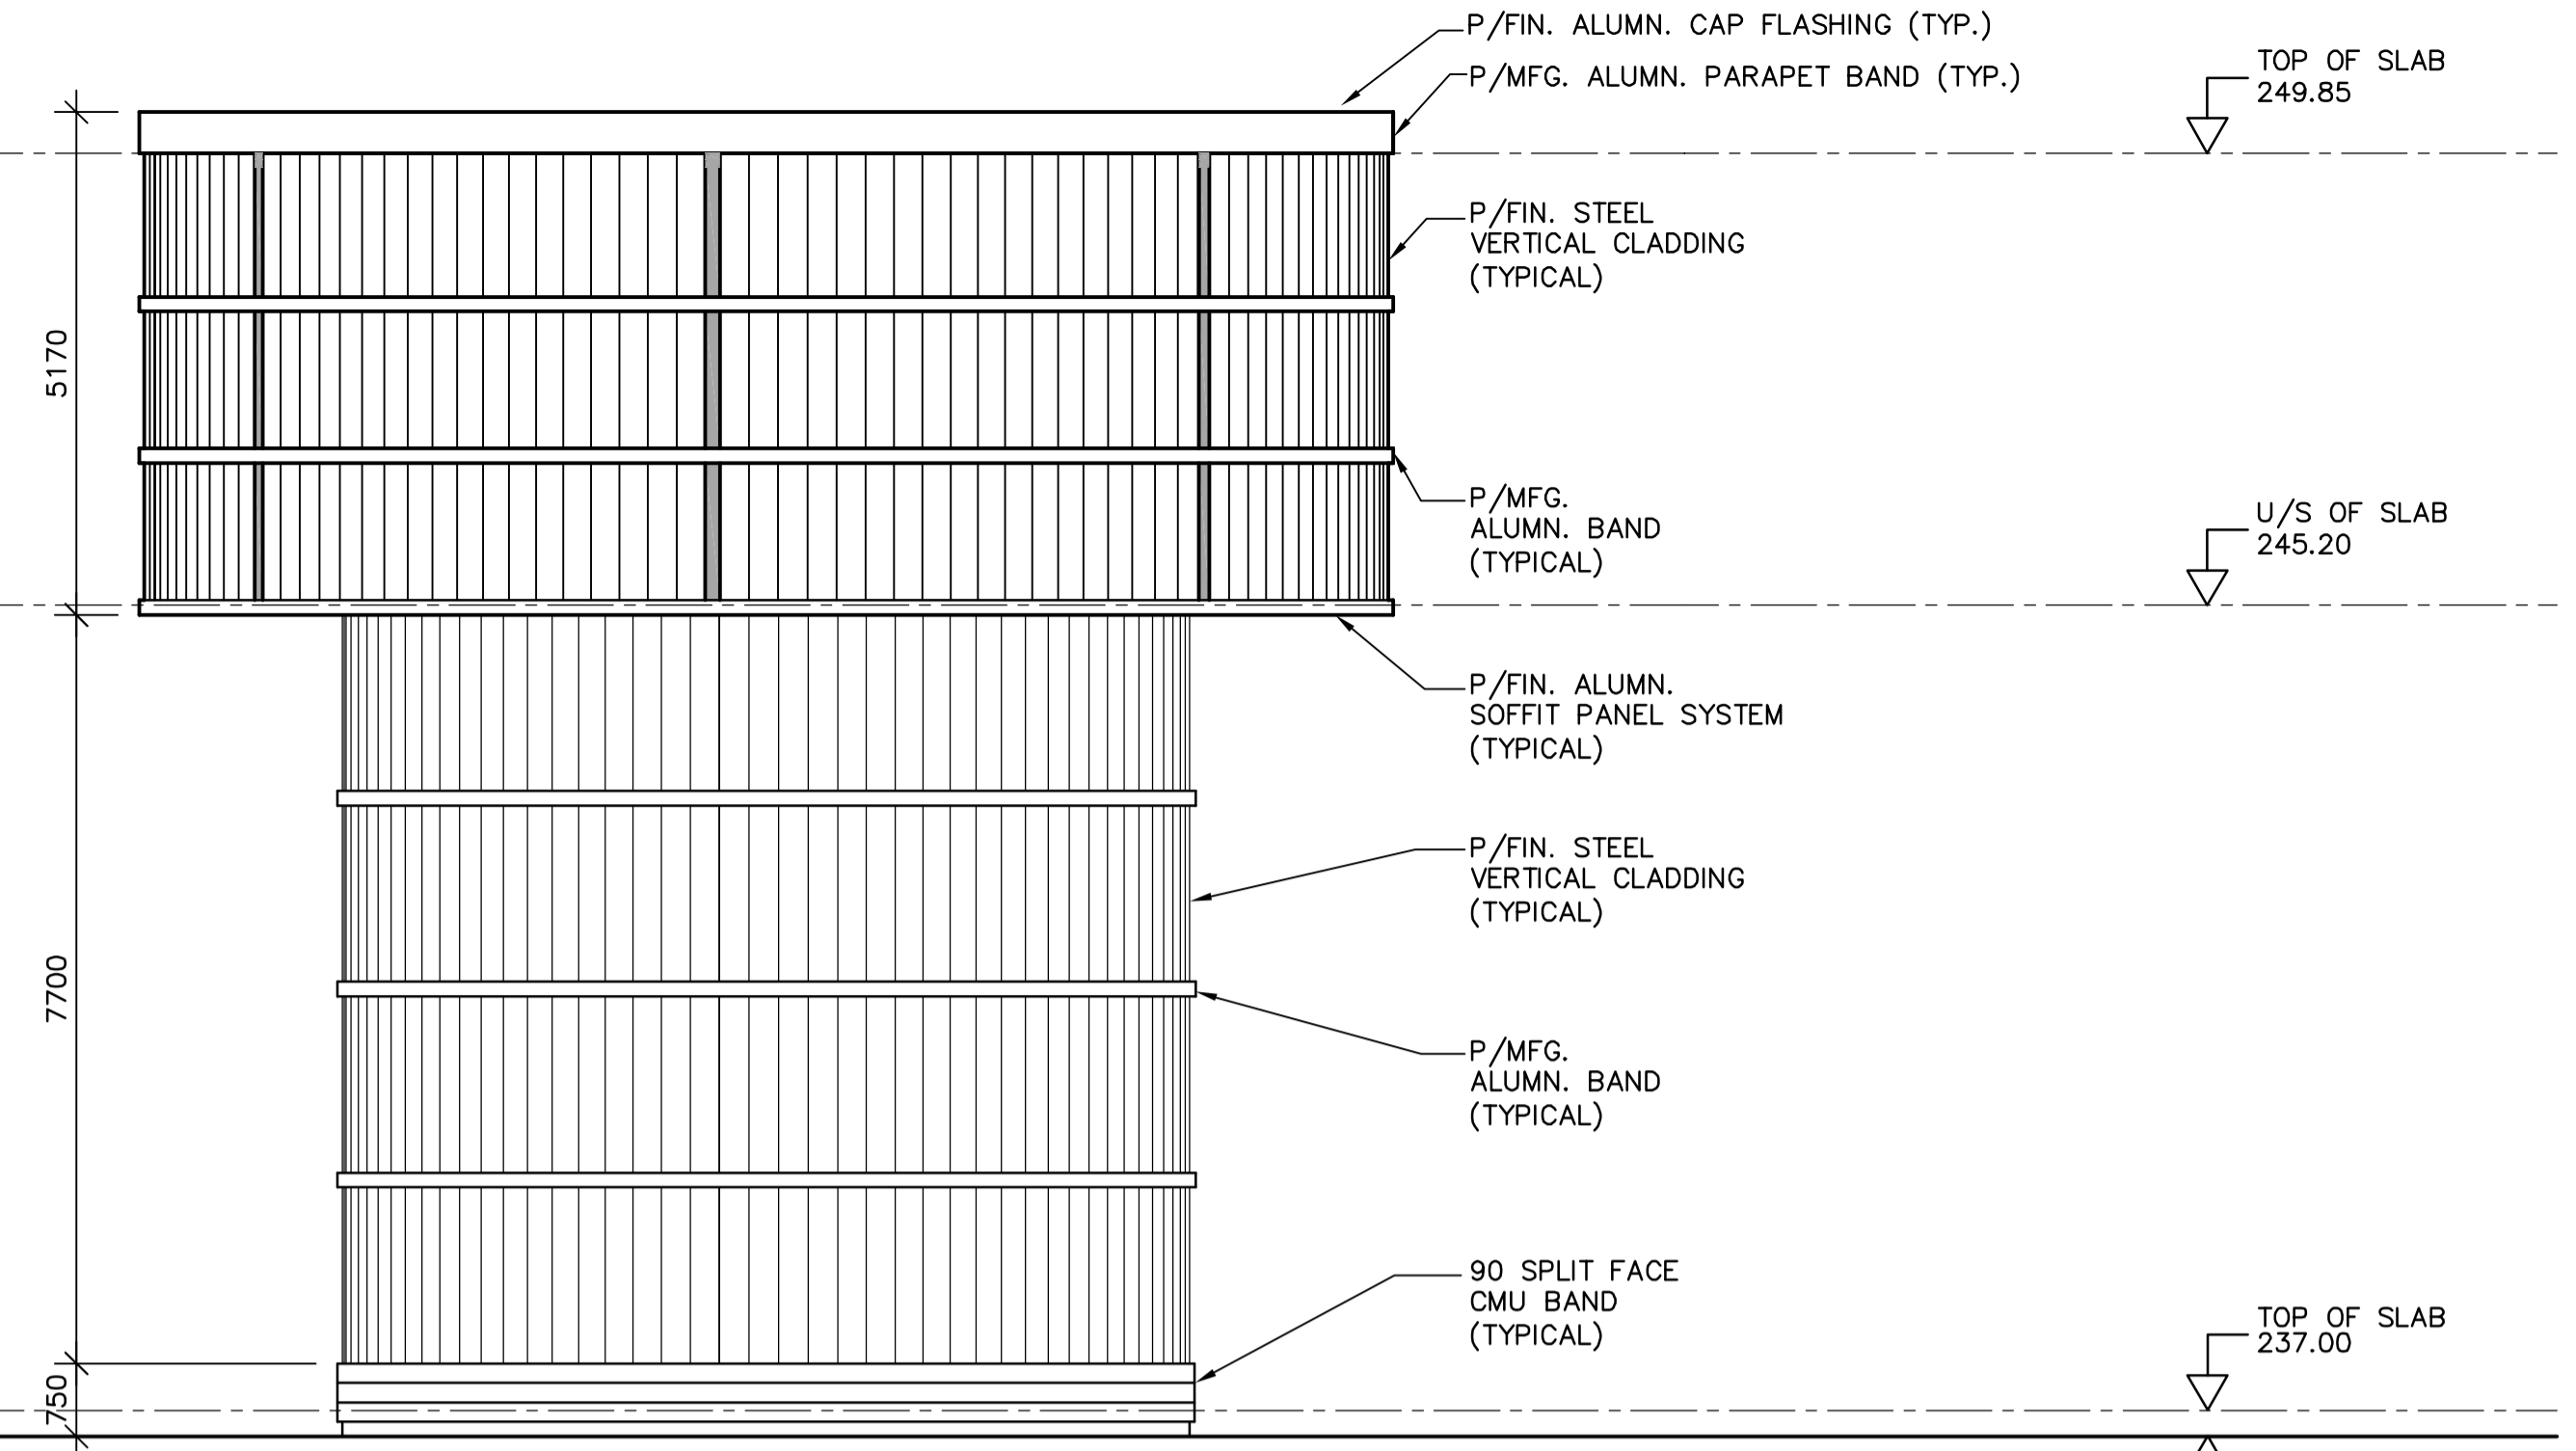

3-SOUTH ELEVATION
SCALE 1:75

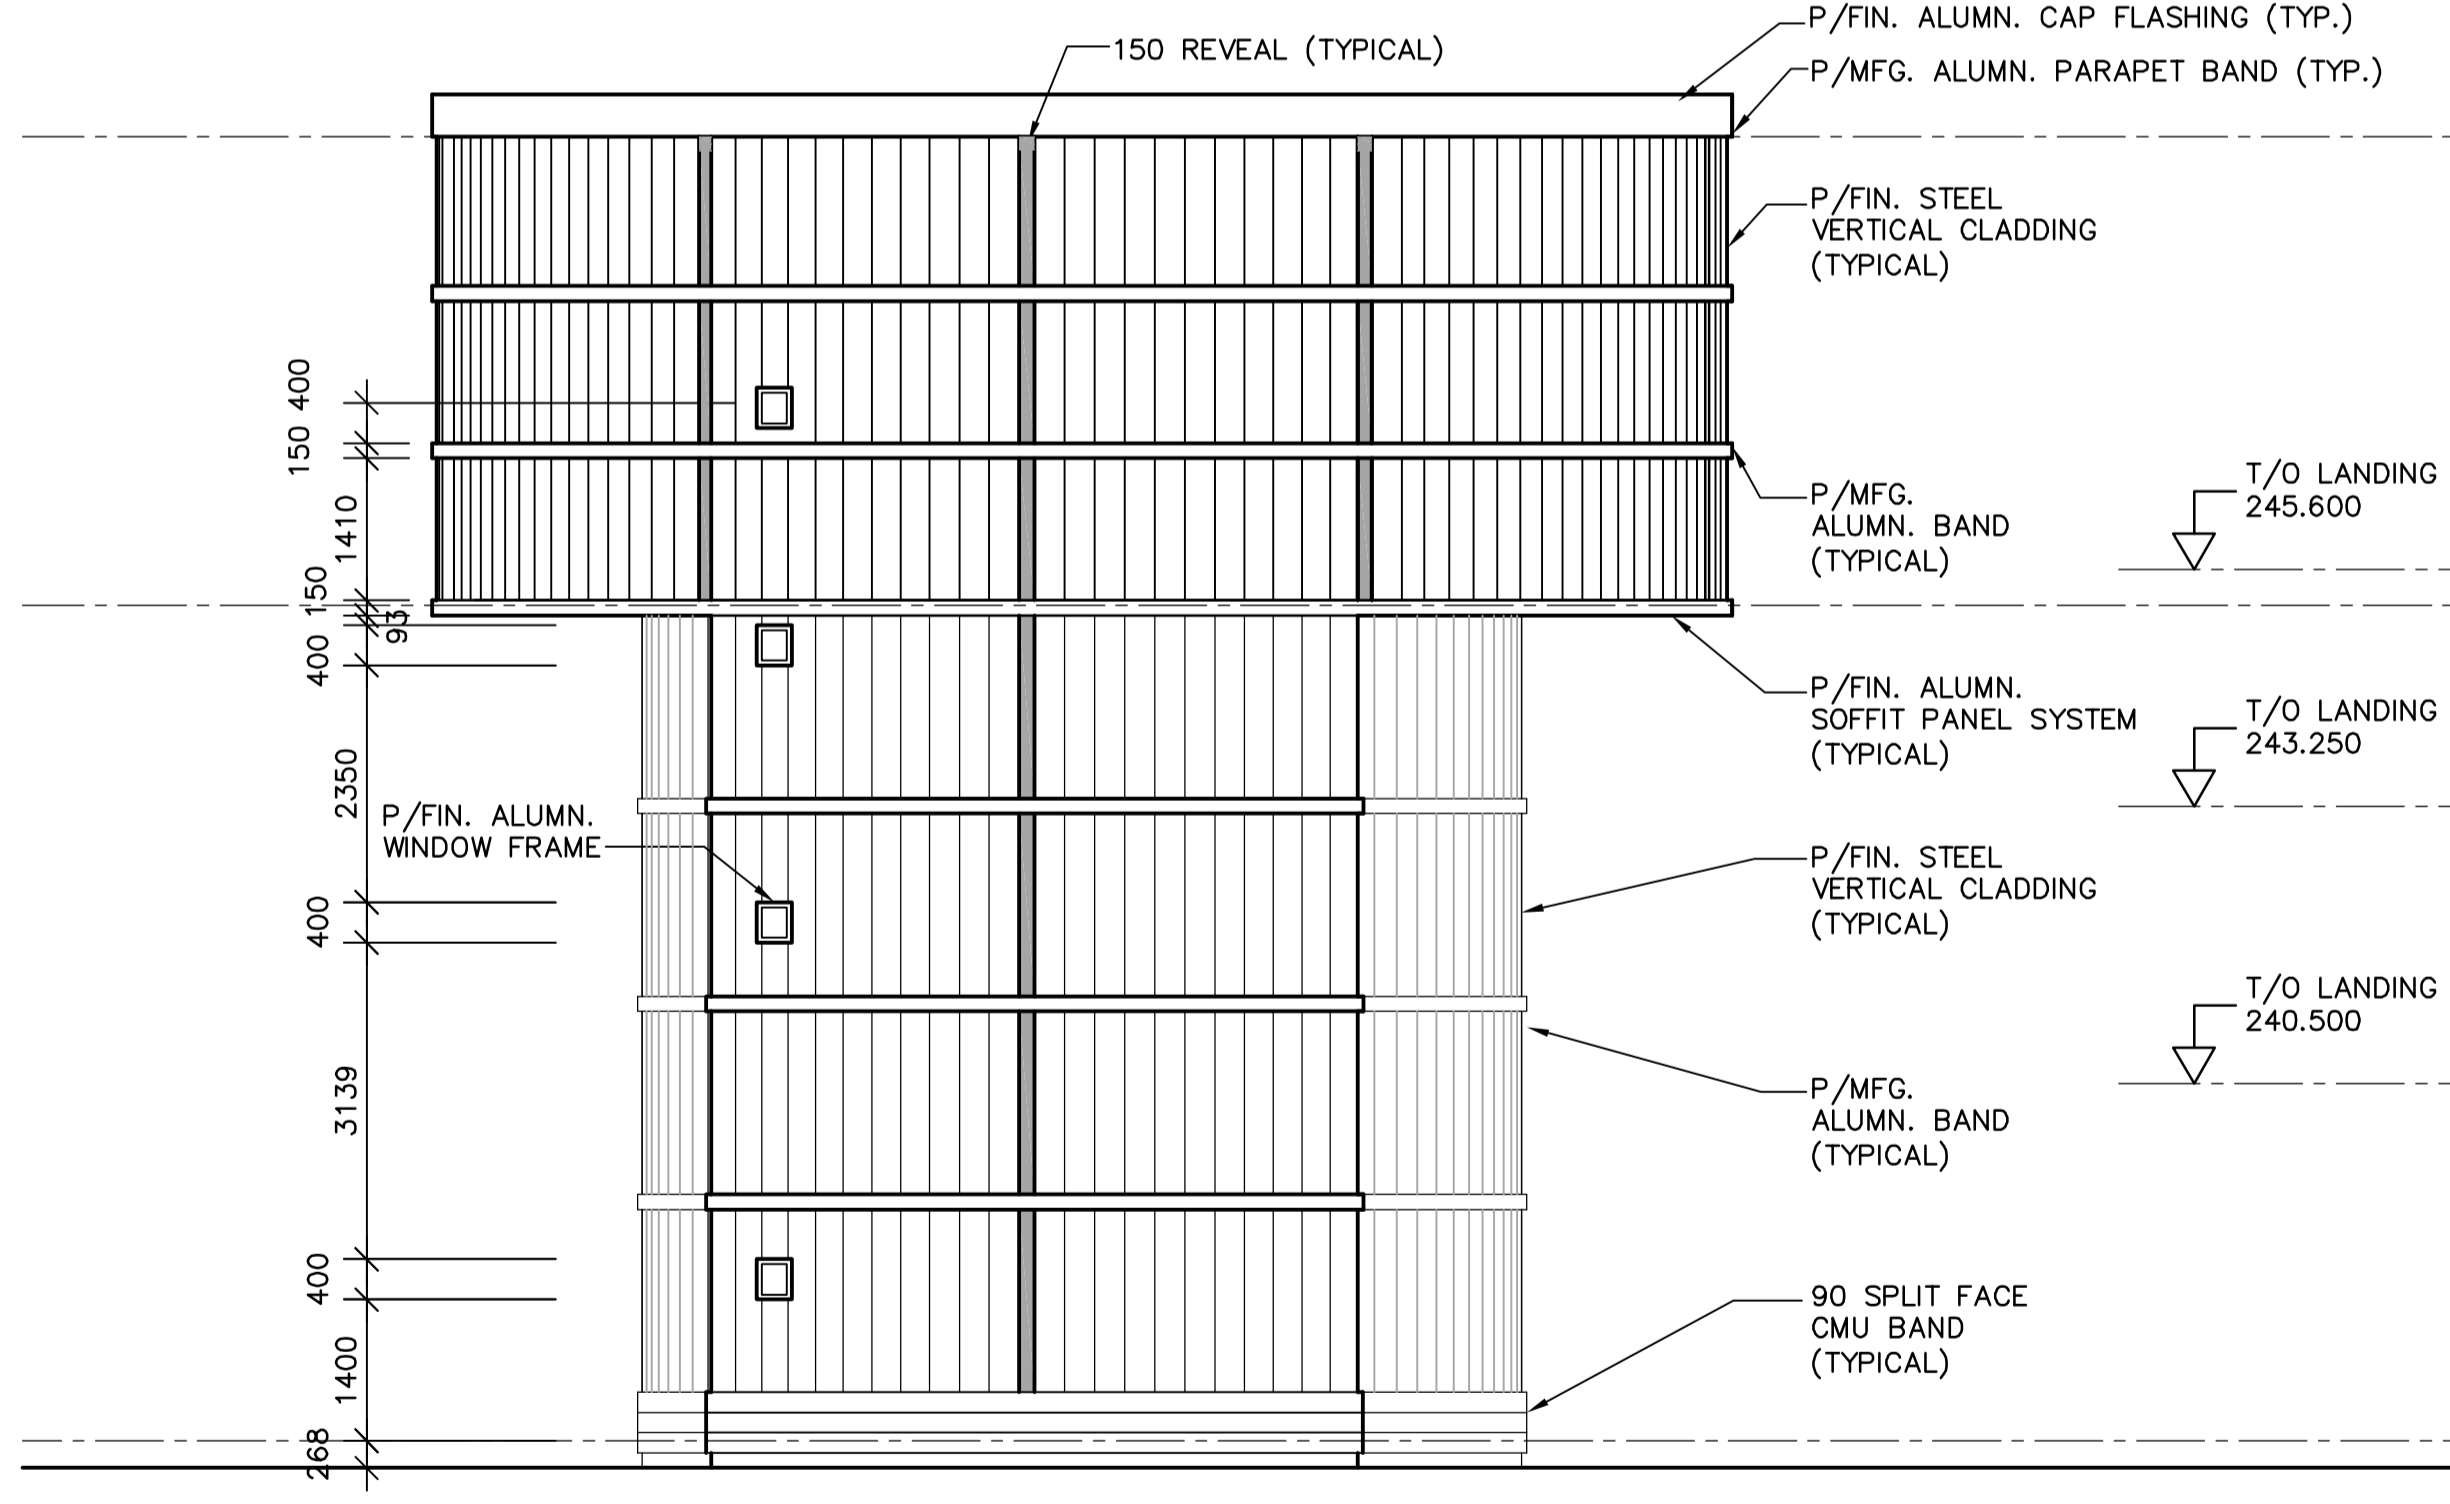

1-NORTH ELEVATION
SCALE 1:75

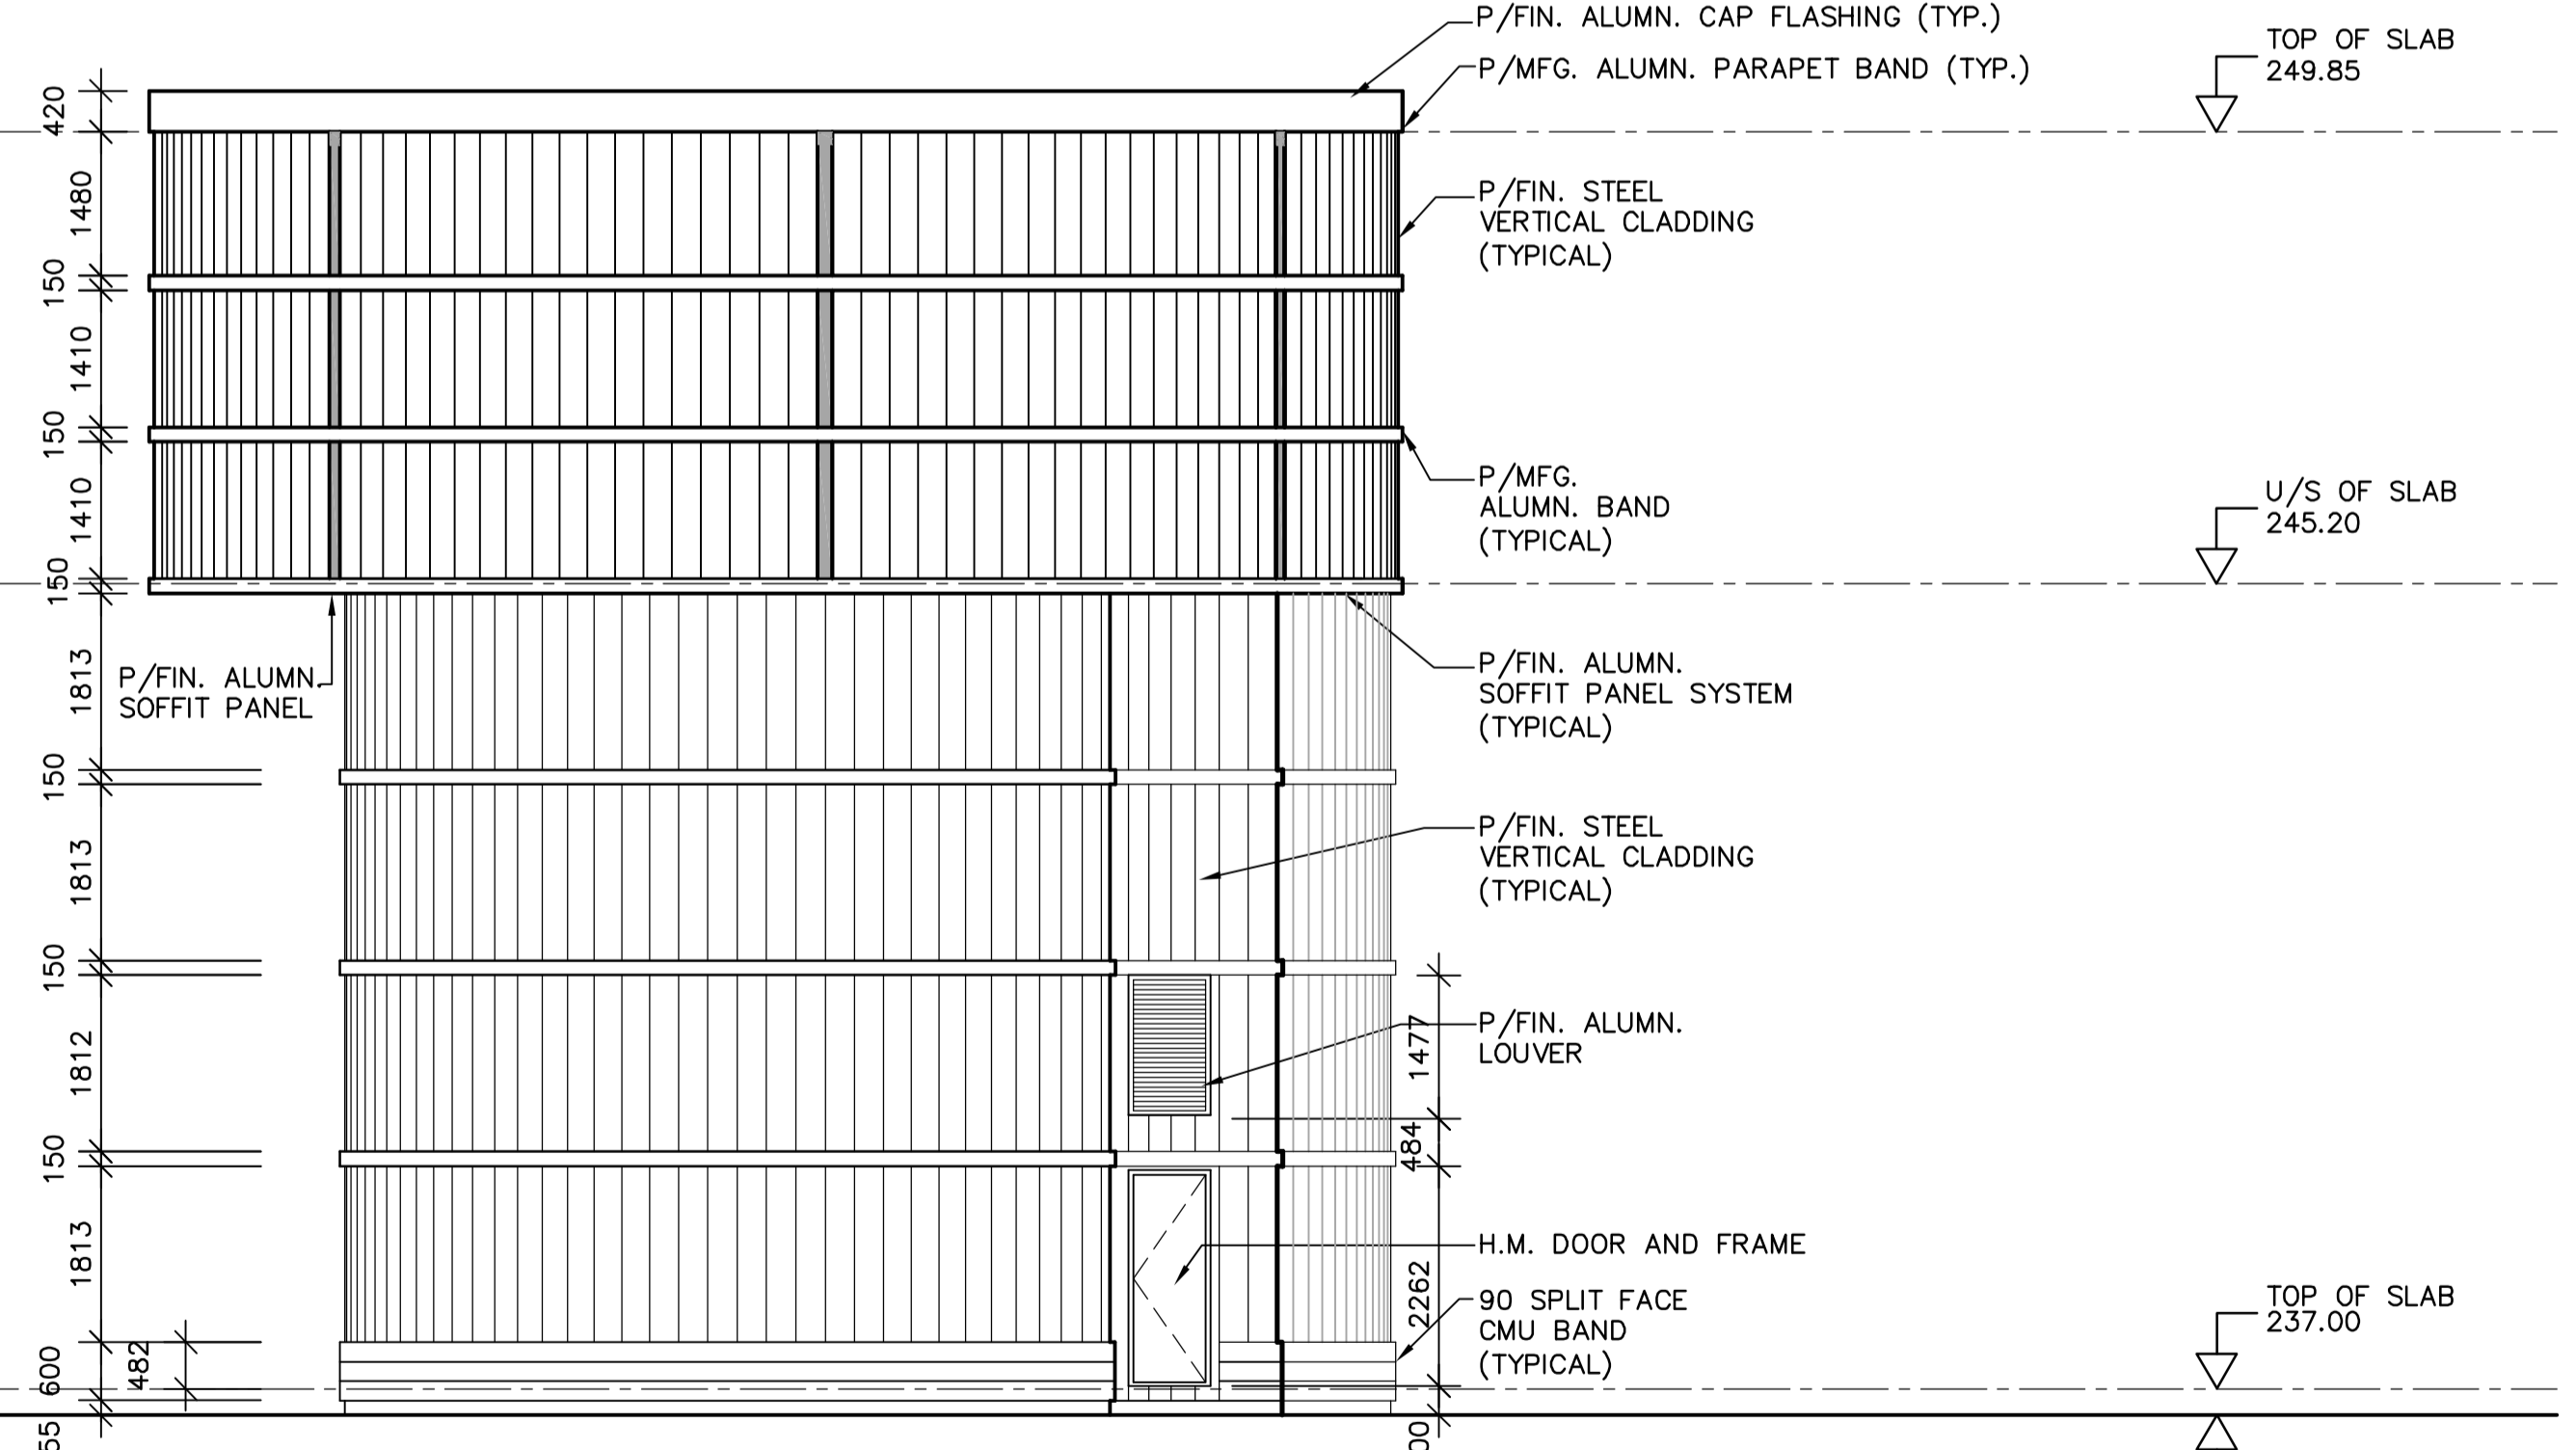

2-EAST ELEVATION
SCALE 1:75



B.M. ELEV.			
DESIGNED BY	TWS	CHECKED BY	TWS
DRAWN BY	SM	APPROVED BY	AHL
SCALE:	AS NOTED	RELEASED FOR CONSTRUCTION BY:	R. SOROKOWSKI
NO.	ISSUED FOR TENDER	DATE	06/05/03 LK
NO.	REVISIONS	DATE	BY
		2006/04/21	

CH2MHILL
Frederickson Cooper ARCHITECTS

EarthTech
A Tyco International Ltd. Company

DESIGNED BY: TWS
CHECKED BY: TWS
DRAWN BY: SM
APPROVED BY: AHL
SCALE: AS NOTED
RELEASED FOR CONSTRUCTION BY: R. SOROKOWSKI

DATE: 2006/04/21
DATE: 2006/05/03

ENGINEER'S SEAL

ORIGINAL SIGNED BY
N. COOPER
2006/05/03

CONSULTANT DRAWING NO.
WY-B0300

THE CITY OF WINNIPEG
WATER AND WASTE DEPARTMENT
ENGINEERING DIVISION

WATER TREATMENT PLANT
YARD PIPING AND VALVE CHAMBERS
SURGE TOWER CONSTRUCTION

ARCHITECTURAL ELEVATIONS

CITY FILE NUMBER
SHEET OF
CITY DRAWING NUMBER
1-0601Y-A-B0300-001-00D