



MAIN ENTRY PLAN @ EL. 236.500

1:75

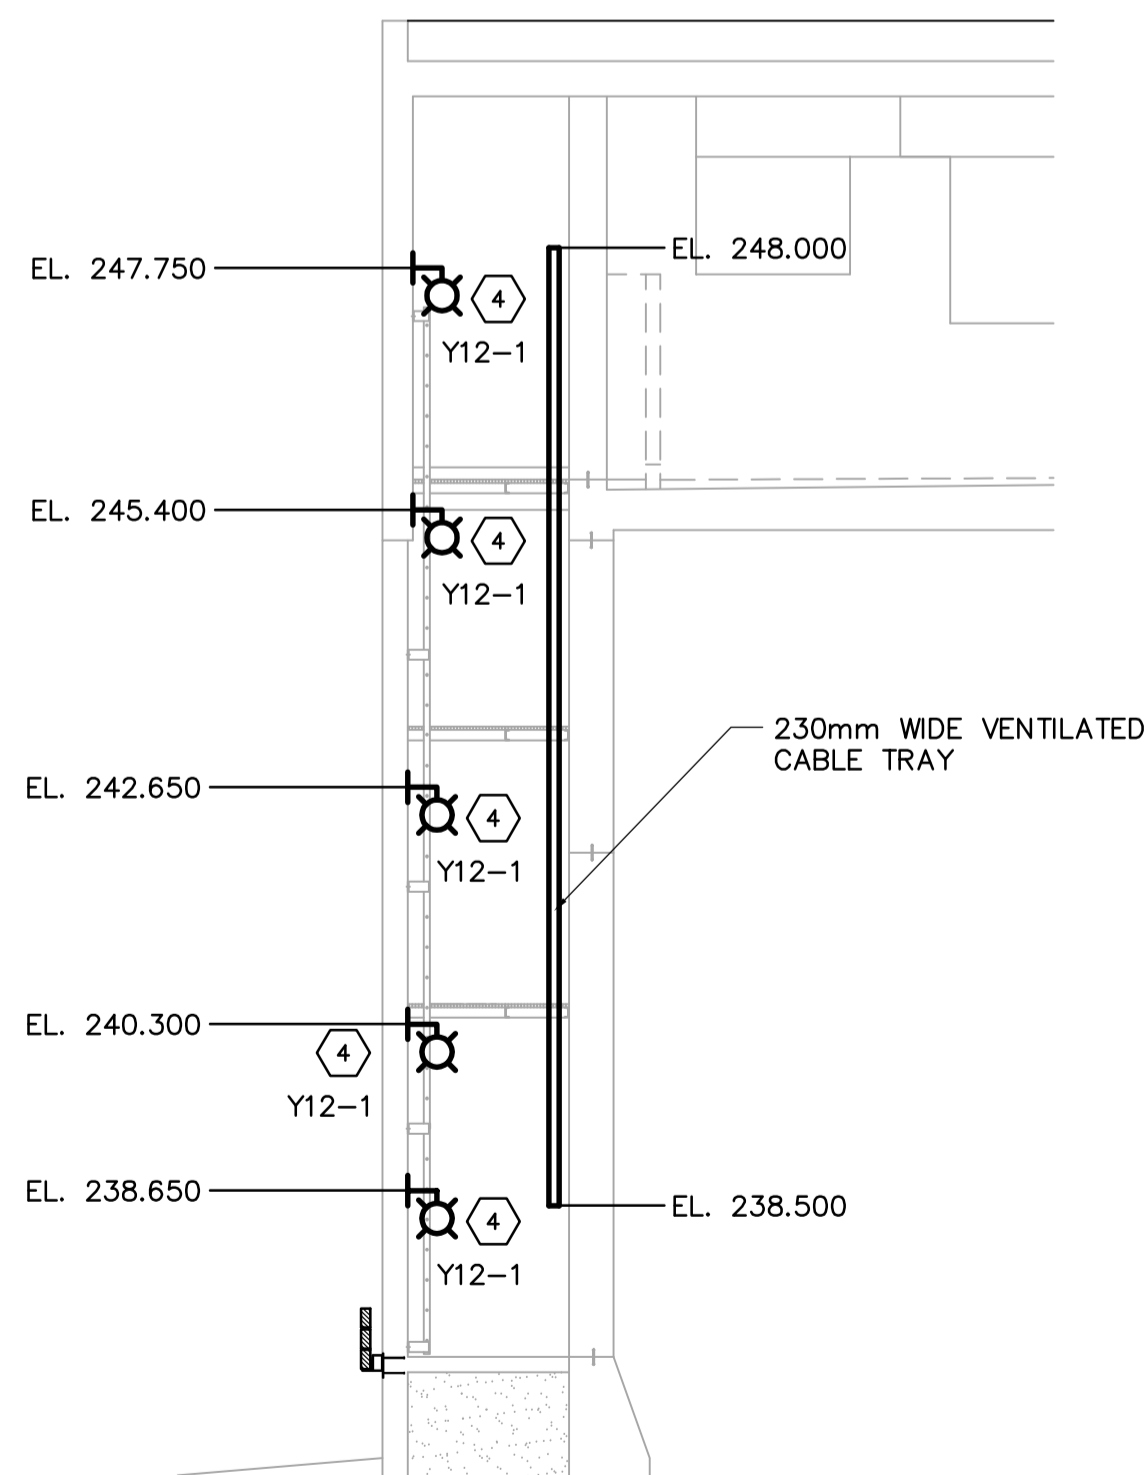


SECTION

1:75

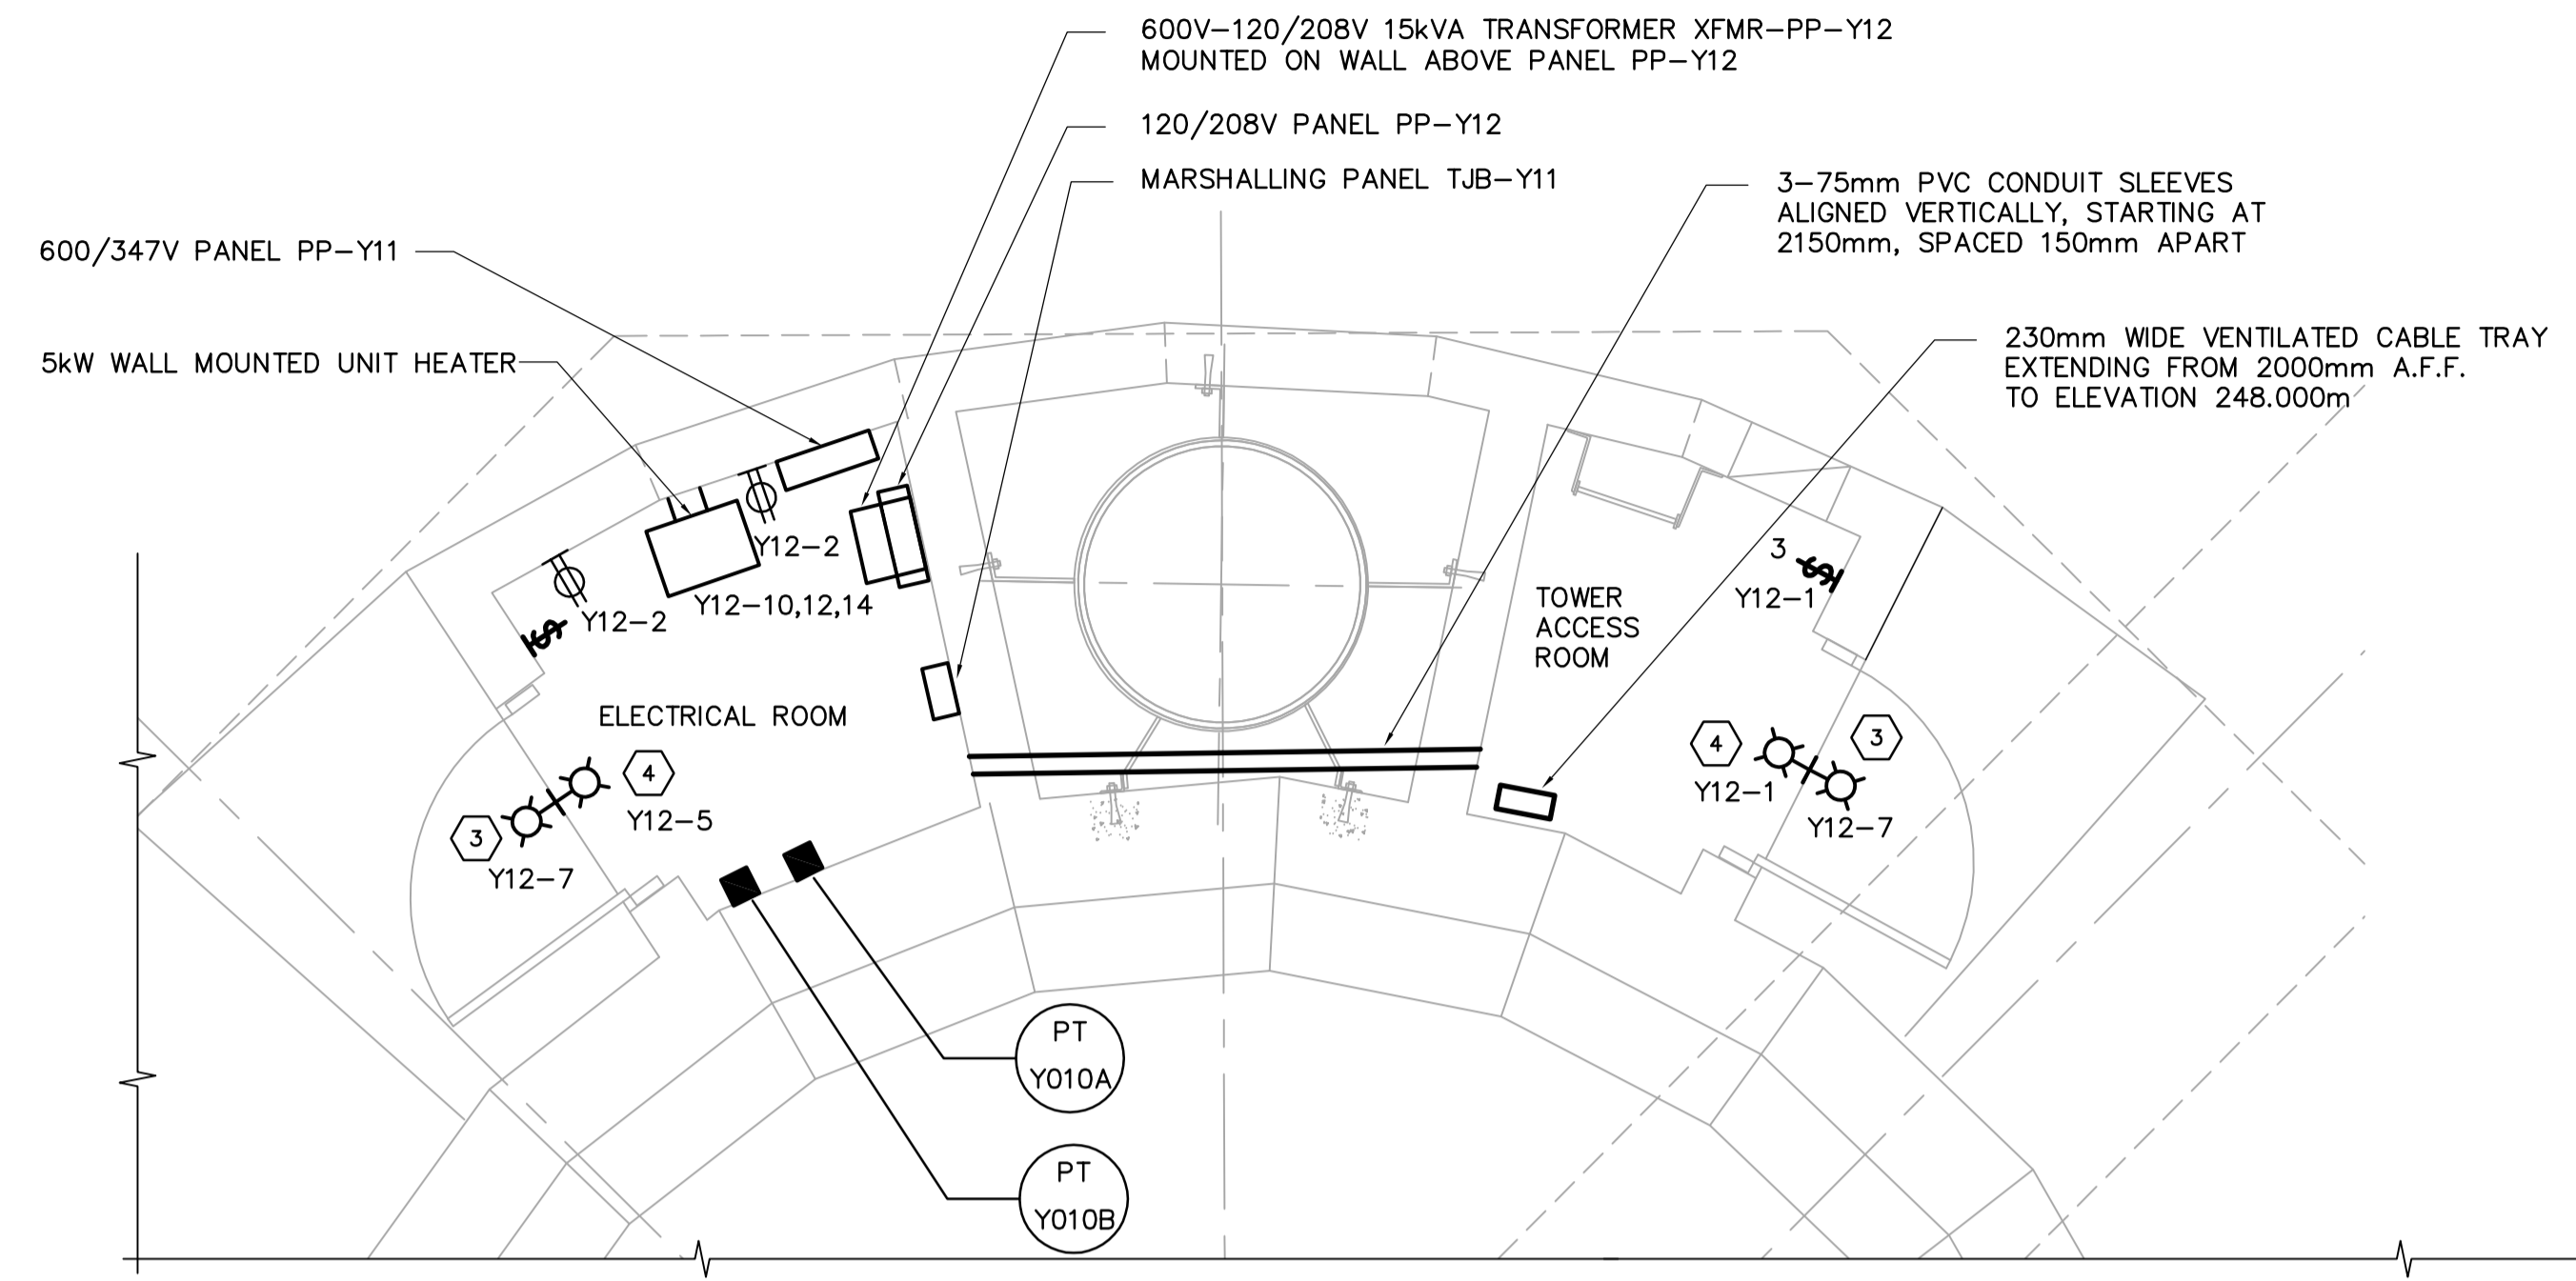

PARTIAL PLAN @ MAIN ENTRY

SCALE: 1:30

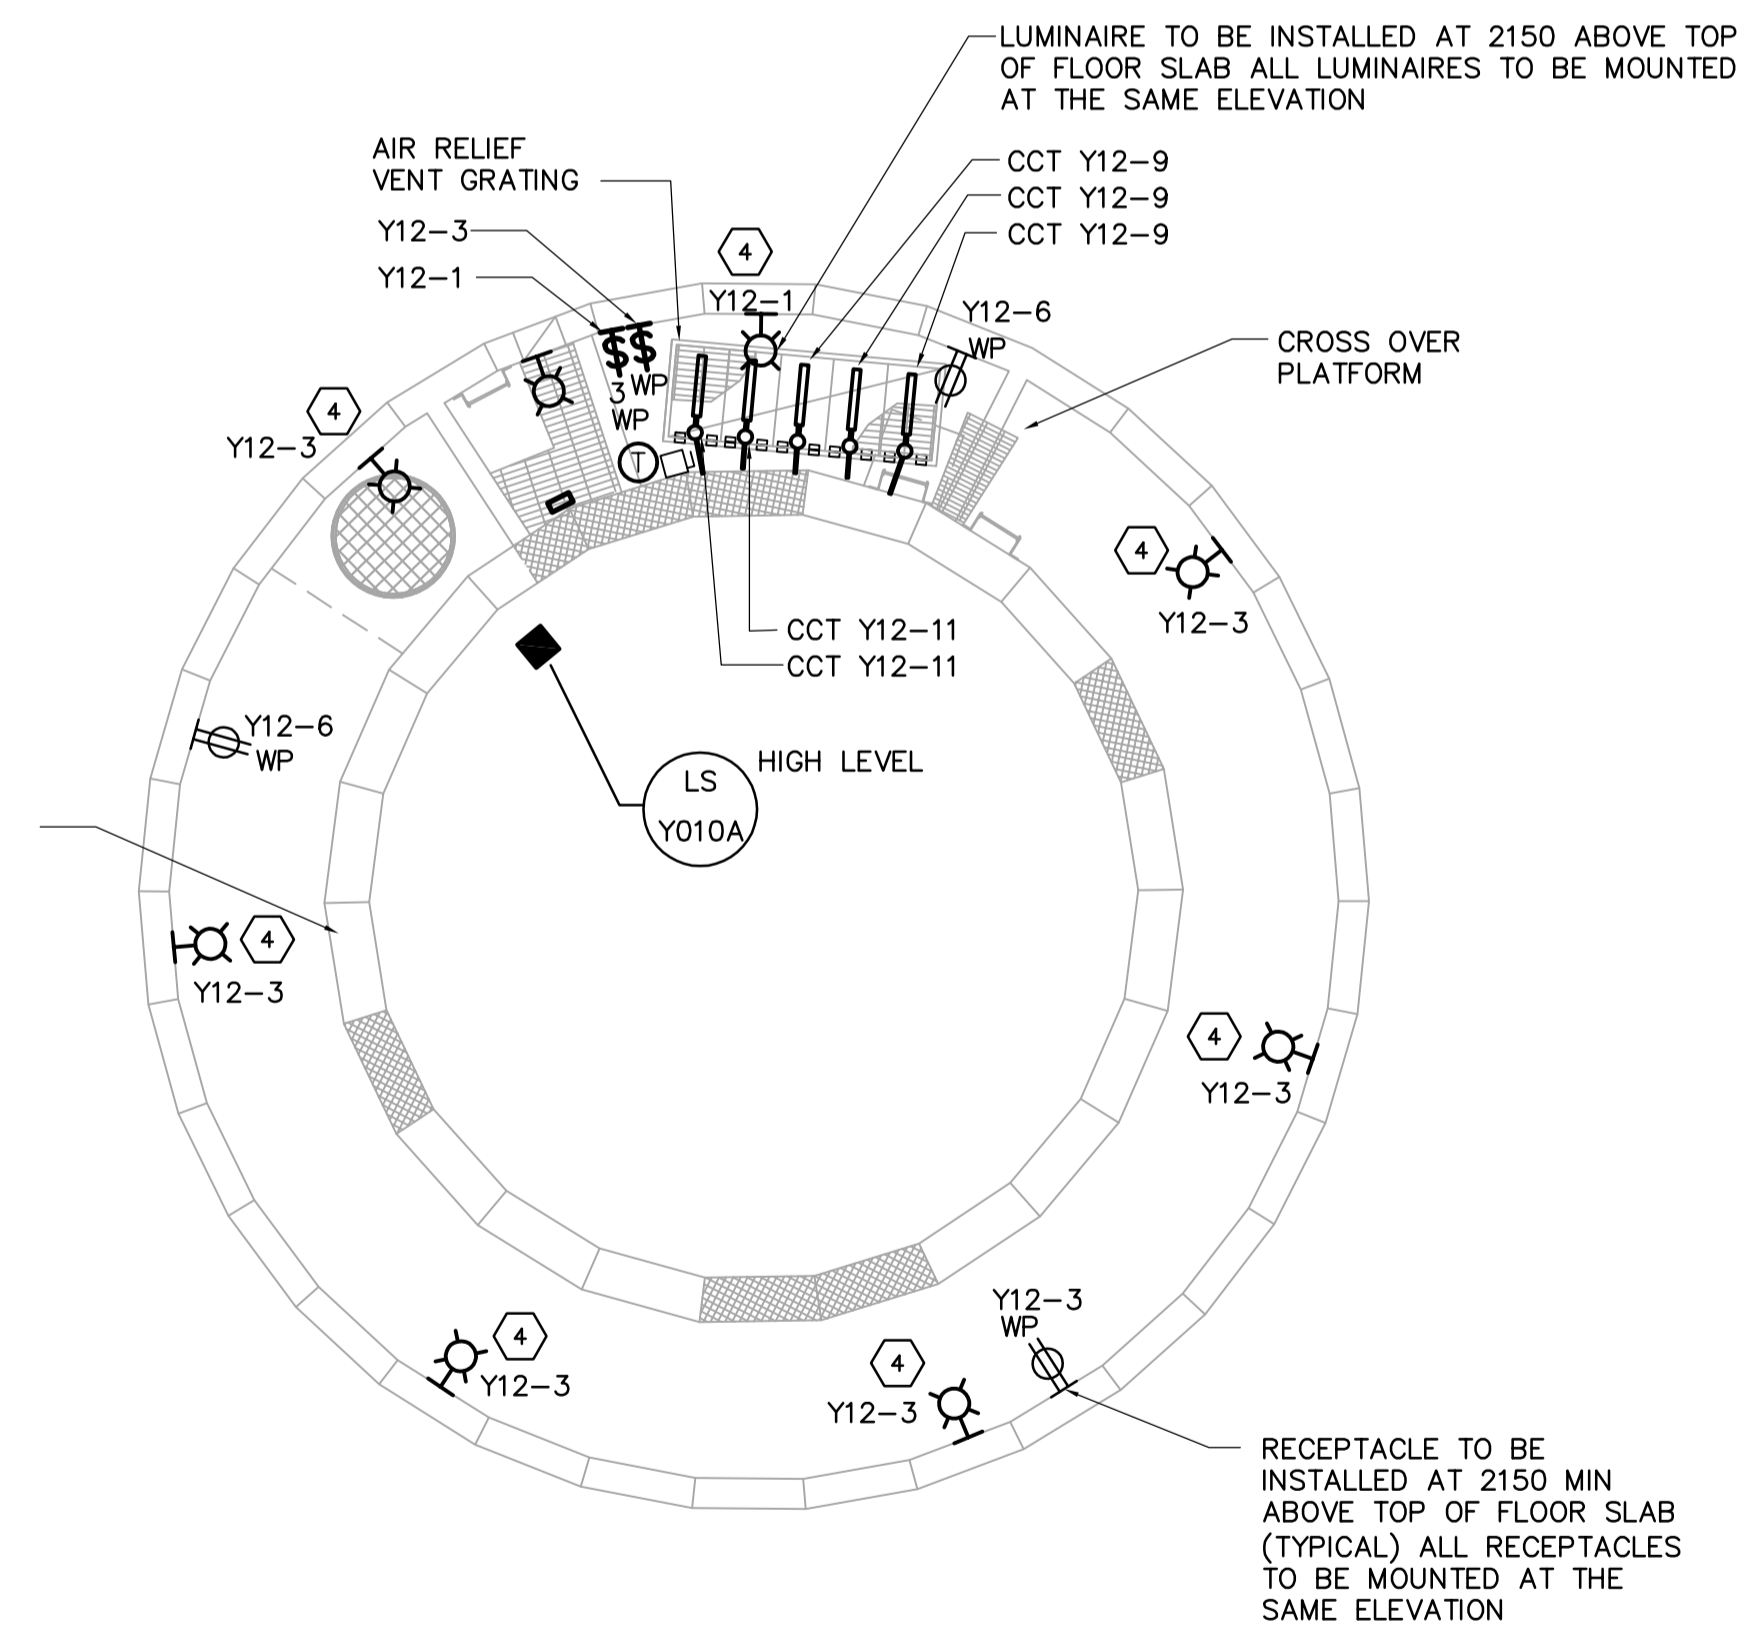

AT OVERFLOW PLAN

1:75

<p><b>APEGM</b> Certificate of Authorization Earth Tech Canada Inc. No. 730 Expiry: April 30, 2007</p>	B.M. ELEV.	<p>Frederickson Cooper ARCHITECTS</p>	<p>EarthTech A Fluor International Ltd. Company</p>	ENGINEER'S SEAL	<p><b>THE CITY OF WINNIPEG</b> WATER AND WASTE DEPARTMENT ENGINEERING DIVISION</p>		
				DESIGNED BY: BLM		CHECKED BY: PS	ORIGINAL SIGNED BY: B.L. MOORE
				DRAWN BY: ERC		APPROVED BY: AHL	2006/05/03
				SCALE: AS NOTED		RELEASED FOR CONSTRUCTION BY: R.SOROKOWSKI	CONSULTANT DRAWING NO. WY-E0151
	00 ISSUED FOR TENDER 06/05/03 ERC	NO. REVISIONS	DATE 2006/02/16	DATE 2006/05/03	<p>WATER TREATMENT PLANT YARD PIPING AND VALVE CHAMBERS SURGE TOWER CONSTRUCTION</p>	CITY FILE NUMBER	
					<p>ELECTRICAL PLANS AND DETAIL</p>	SHEET OF	
						CITY DRAWING NUMBER	
						1-06011-A-E0151-001-00D	