


NOTES :
GENERAL NOTES:
 1. FOR CRAWL SPACE DRAINAGE PLAN & WEeping TILE LOCATIONS -SEE MECH. DWGS.

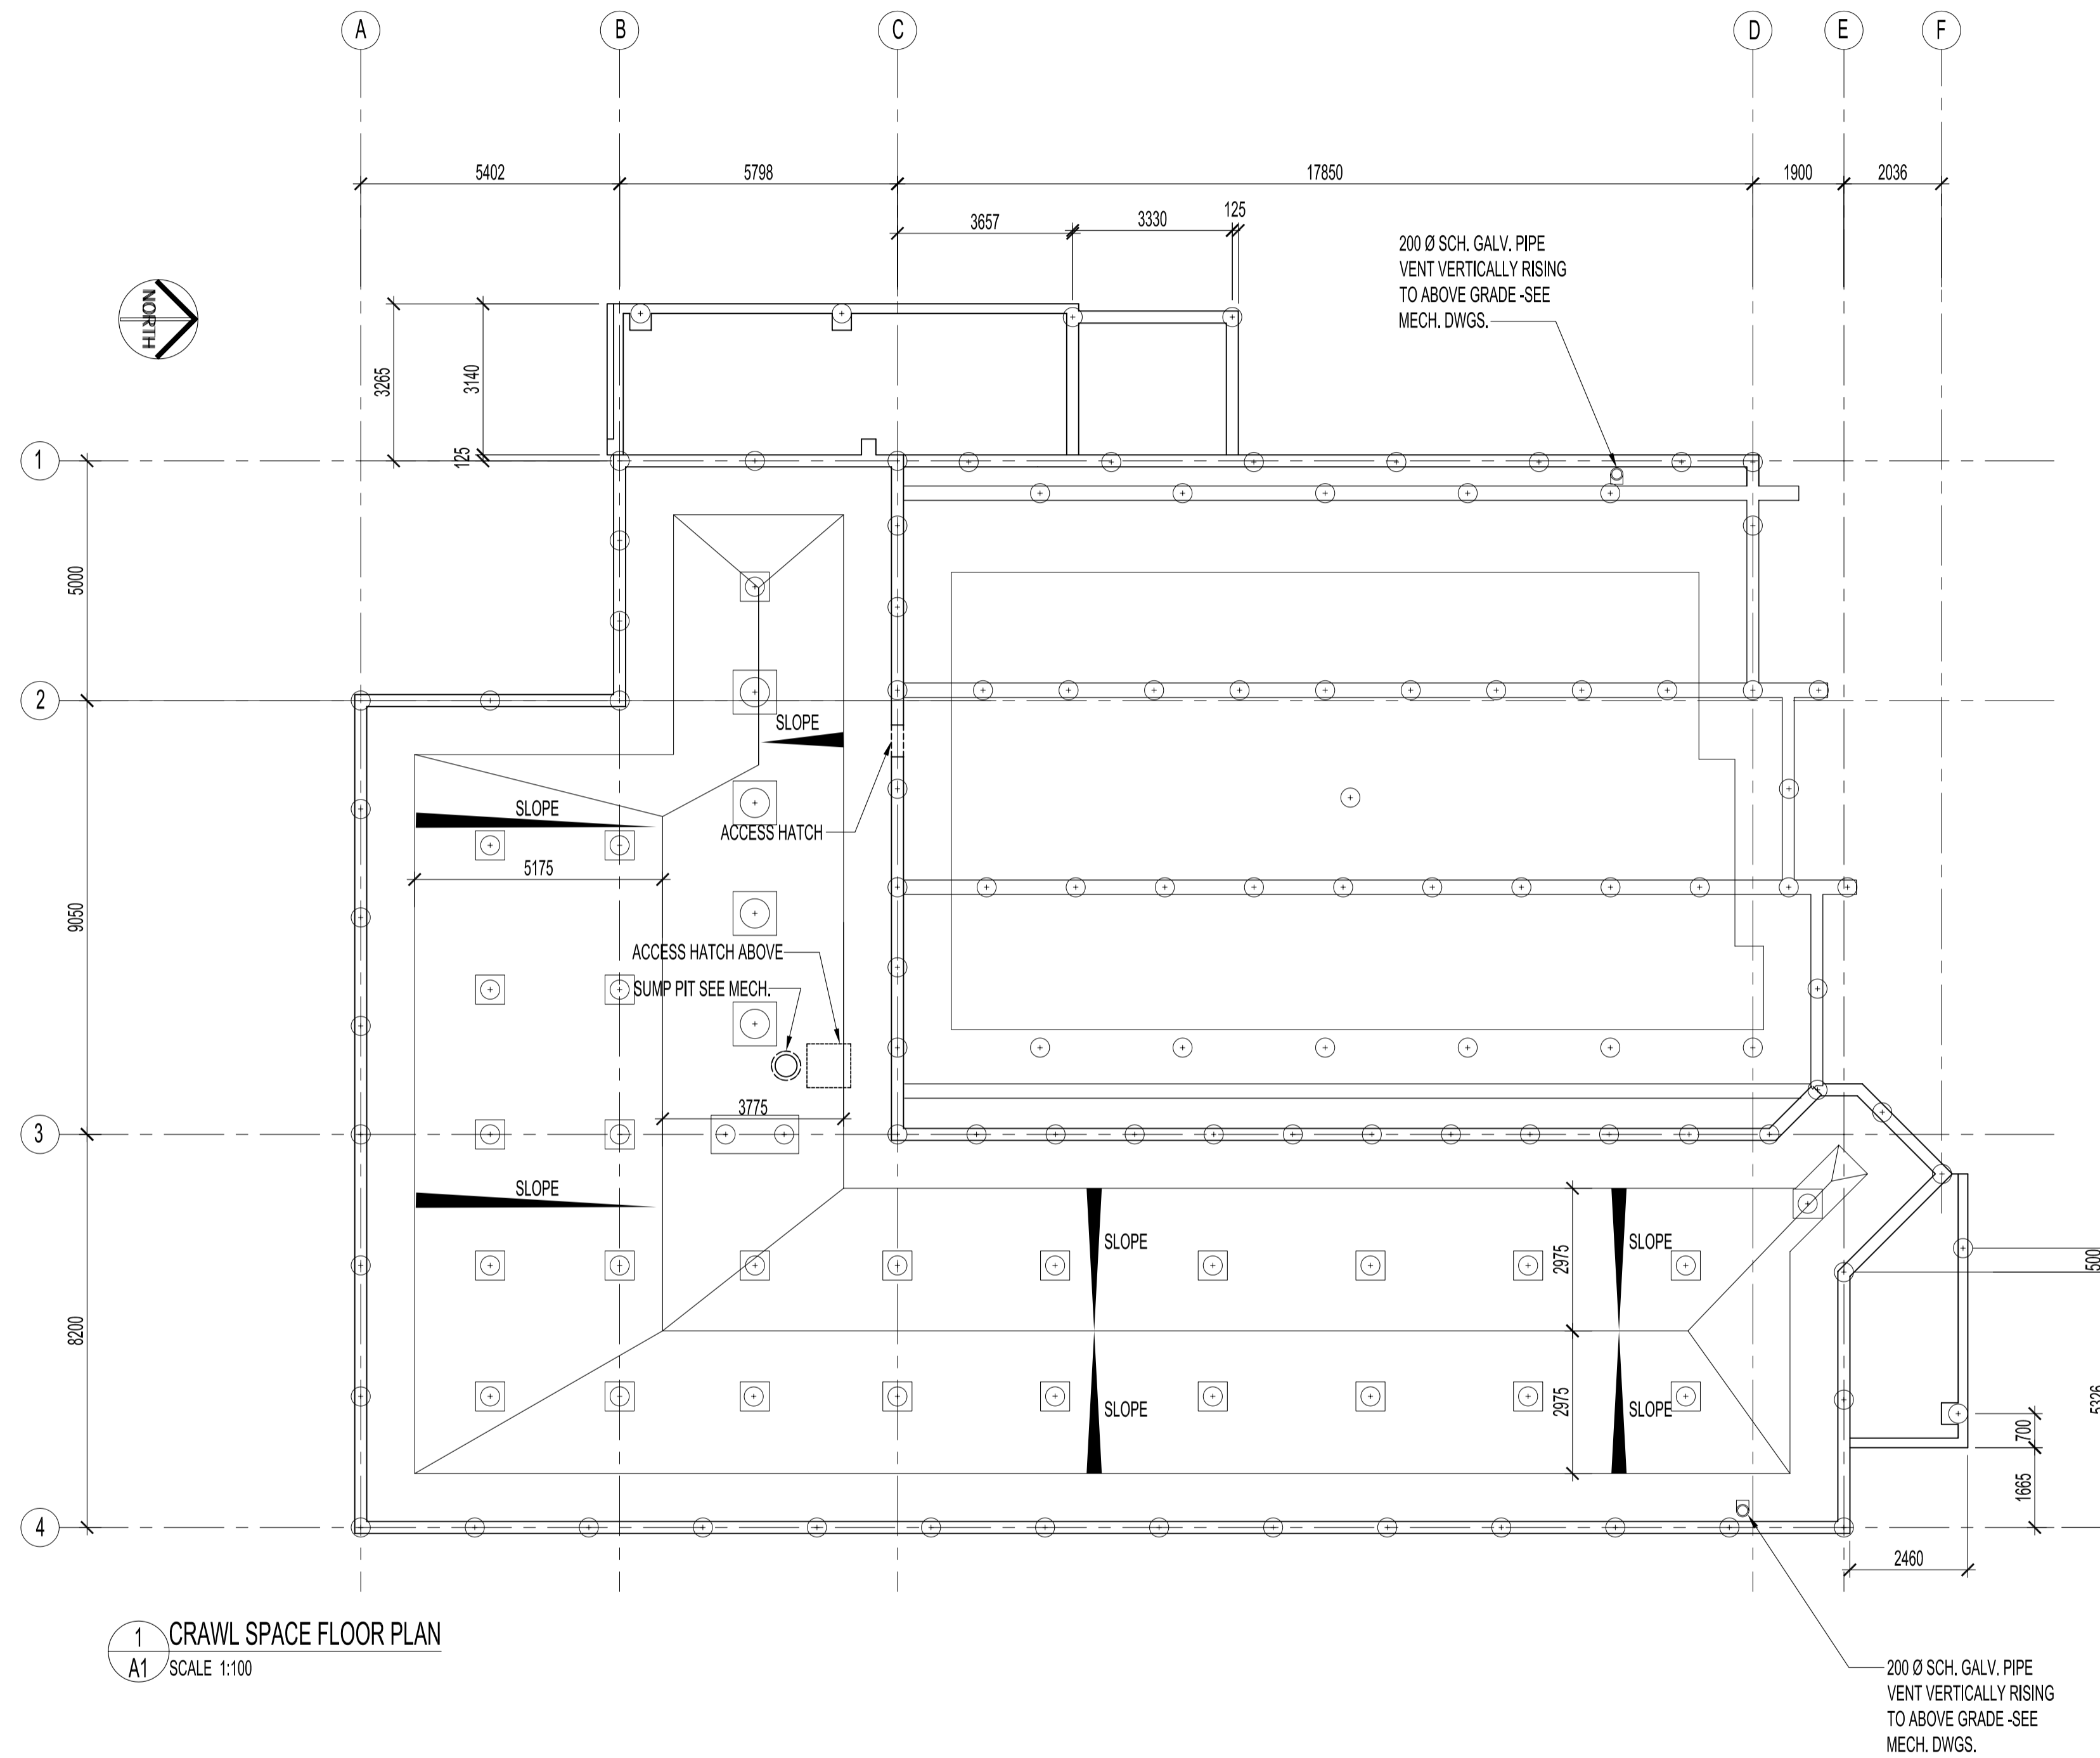

1 CRAWL SPACE FLOOR PLAN
 A1 SCALE 1:100

ORIGINAL STAMPED BY: R. K. FOK LI Arch.
 DATE: 2006.07.18

NO.	REVISION/DESCRIPTION	BY	DATE
SEALS			

DRAWN BY	CHECKED BY	APPROVED
MWK	USER	APPROVAL
DATE	2006.07.10	

CITY OF WINNIPEG
 PLANNING, PROPERTY &
 DEVELOPMENT DEPARTMENT
 CIVIC ACCOMMODATIONS DIVISION
 300 - 65 GARRY ST. R3C 4K4

PROJECT
 WEST TRANSCONA
 FIRE PARAMEDIC STATION 21

1446 REGENT AVENUE W.
 SHEET TITLE

CRAWL SPACE FLOOR PLAN

METRIC	SCALE	PROJECT NO.	SHEET NO.
WHOLE NUMBERS ARE IN MILLIMETRES, DECIMALIZED NUMBERS ARE IN METRES	AS SHOWN	2004-058	A1