




NOTES :

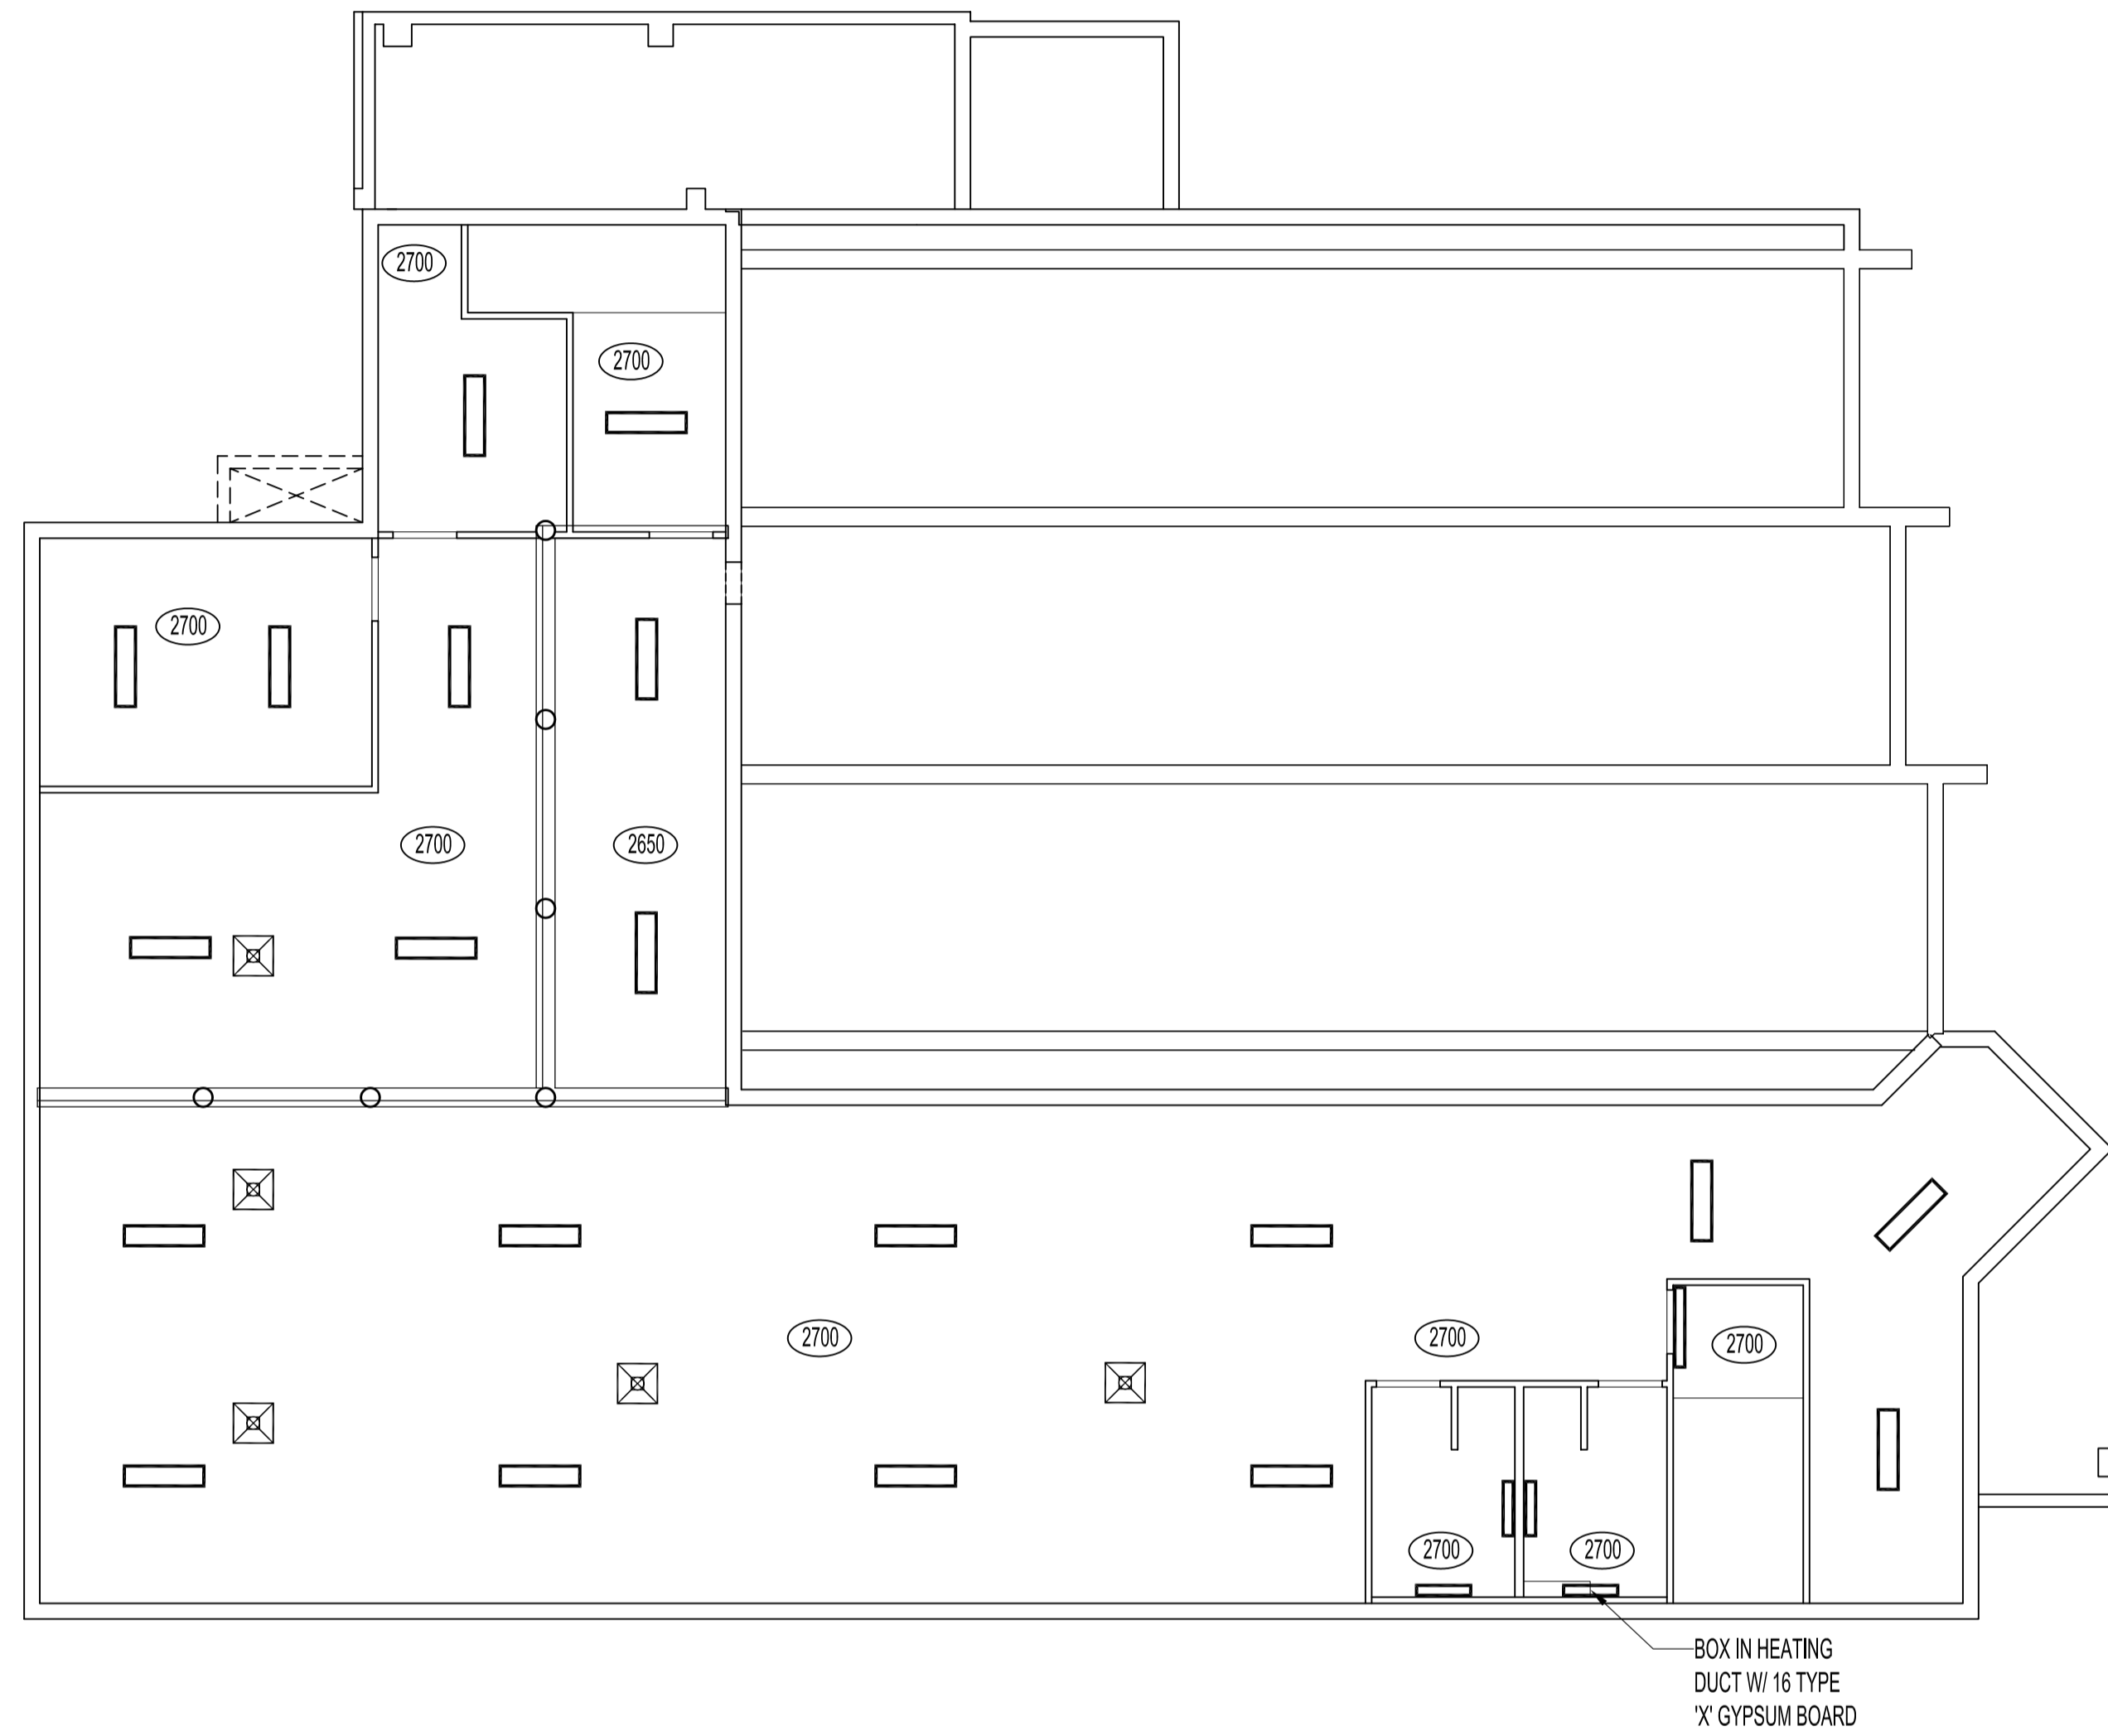

1 BASEMENT FLOOR PLAN -REFLECTED CEILING
A4 SCALE 1:100

CEILING LEGEND	
	CEILING HEIGHT
	CEILING LIGHT FIXTURES
	150 x 860 FLUORESCENT LIGHT FIXTURES
	150 x 1200 FLUORESCENT LIGHT FIXTURES
	300 x 1200 FLUORESCENT LIGHT FIXTURES
	AIR SUPPLY GRILLES

ORIGINAL STAMPED BY: R.K. FOK LI Arch.
DATE: 2006.07.18

NO.	REVISION/DESCRIPTION	BY	DATE
SEALS			

DRAWN BY	CHECKED BY	APPROVED
MWK		
DATE: 2006.07.10	USER APPROVAL	

CITY OF WINNIPEG
PLANNING, PROPERTY &
DEVELOPMENT DEPARTMENT
CIVIC ACCOMMODATIONS DIVISION
300 - 65 GARRY ST. R3C 4K4

PROJECT
WEST TRANSCONA
FIRE PARAMEDIC STATION 21

1446 REGENT AVENUE W.

SHEET TITLE
BASEMENT FLOOR PLAN
REFLECTED CEILING

METRIC
WHOLE NUMBERS ARE IN MILLIMETRES.
DECIMALIZED NUMBERS ARE IN METRES

SCALE	PROJECT NO.	SHEET NO.
AS SHOWN	2004-058	A4