


ADDRESS: 1446 REGENT AVE. WEST PROJECT No.: 2004-058-01 DESCRIPTION: CRAWL SPACE FLOOR PLAN: ELEC. AND LIGHTING DATE: 2006.07.14 FILE NAME: 2004058VE0.dwg/E2

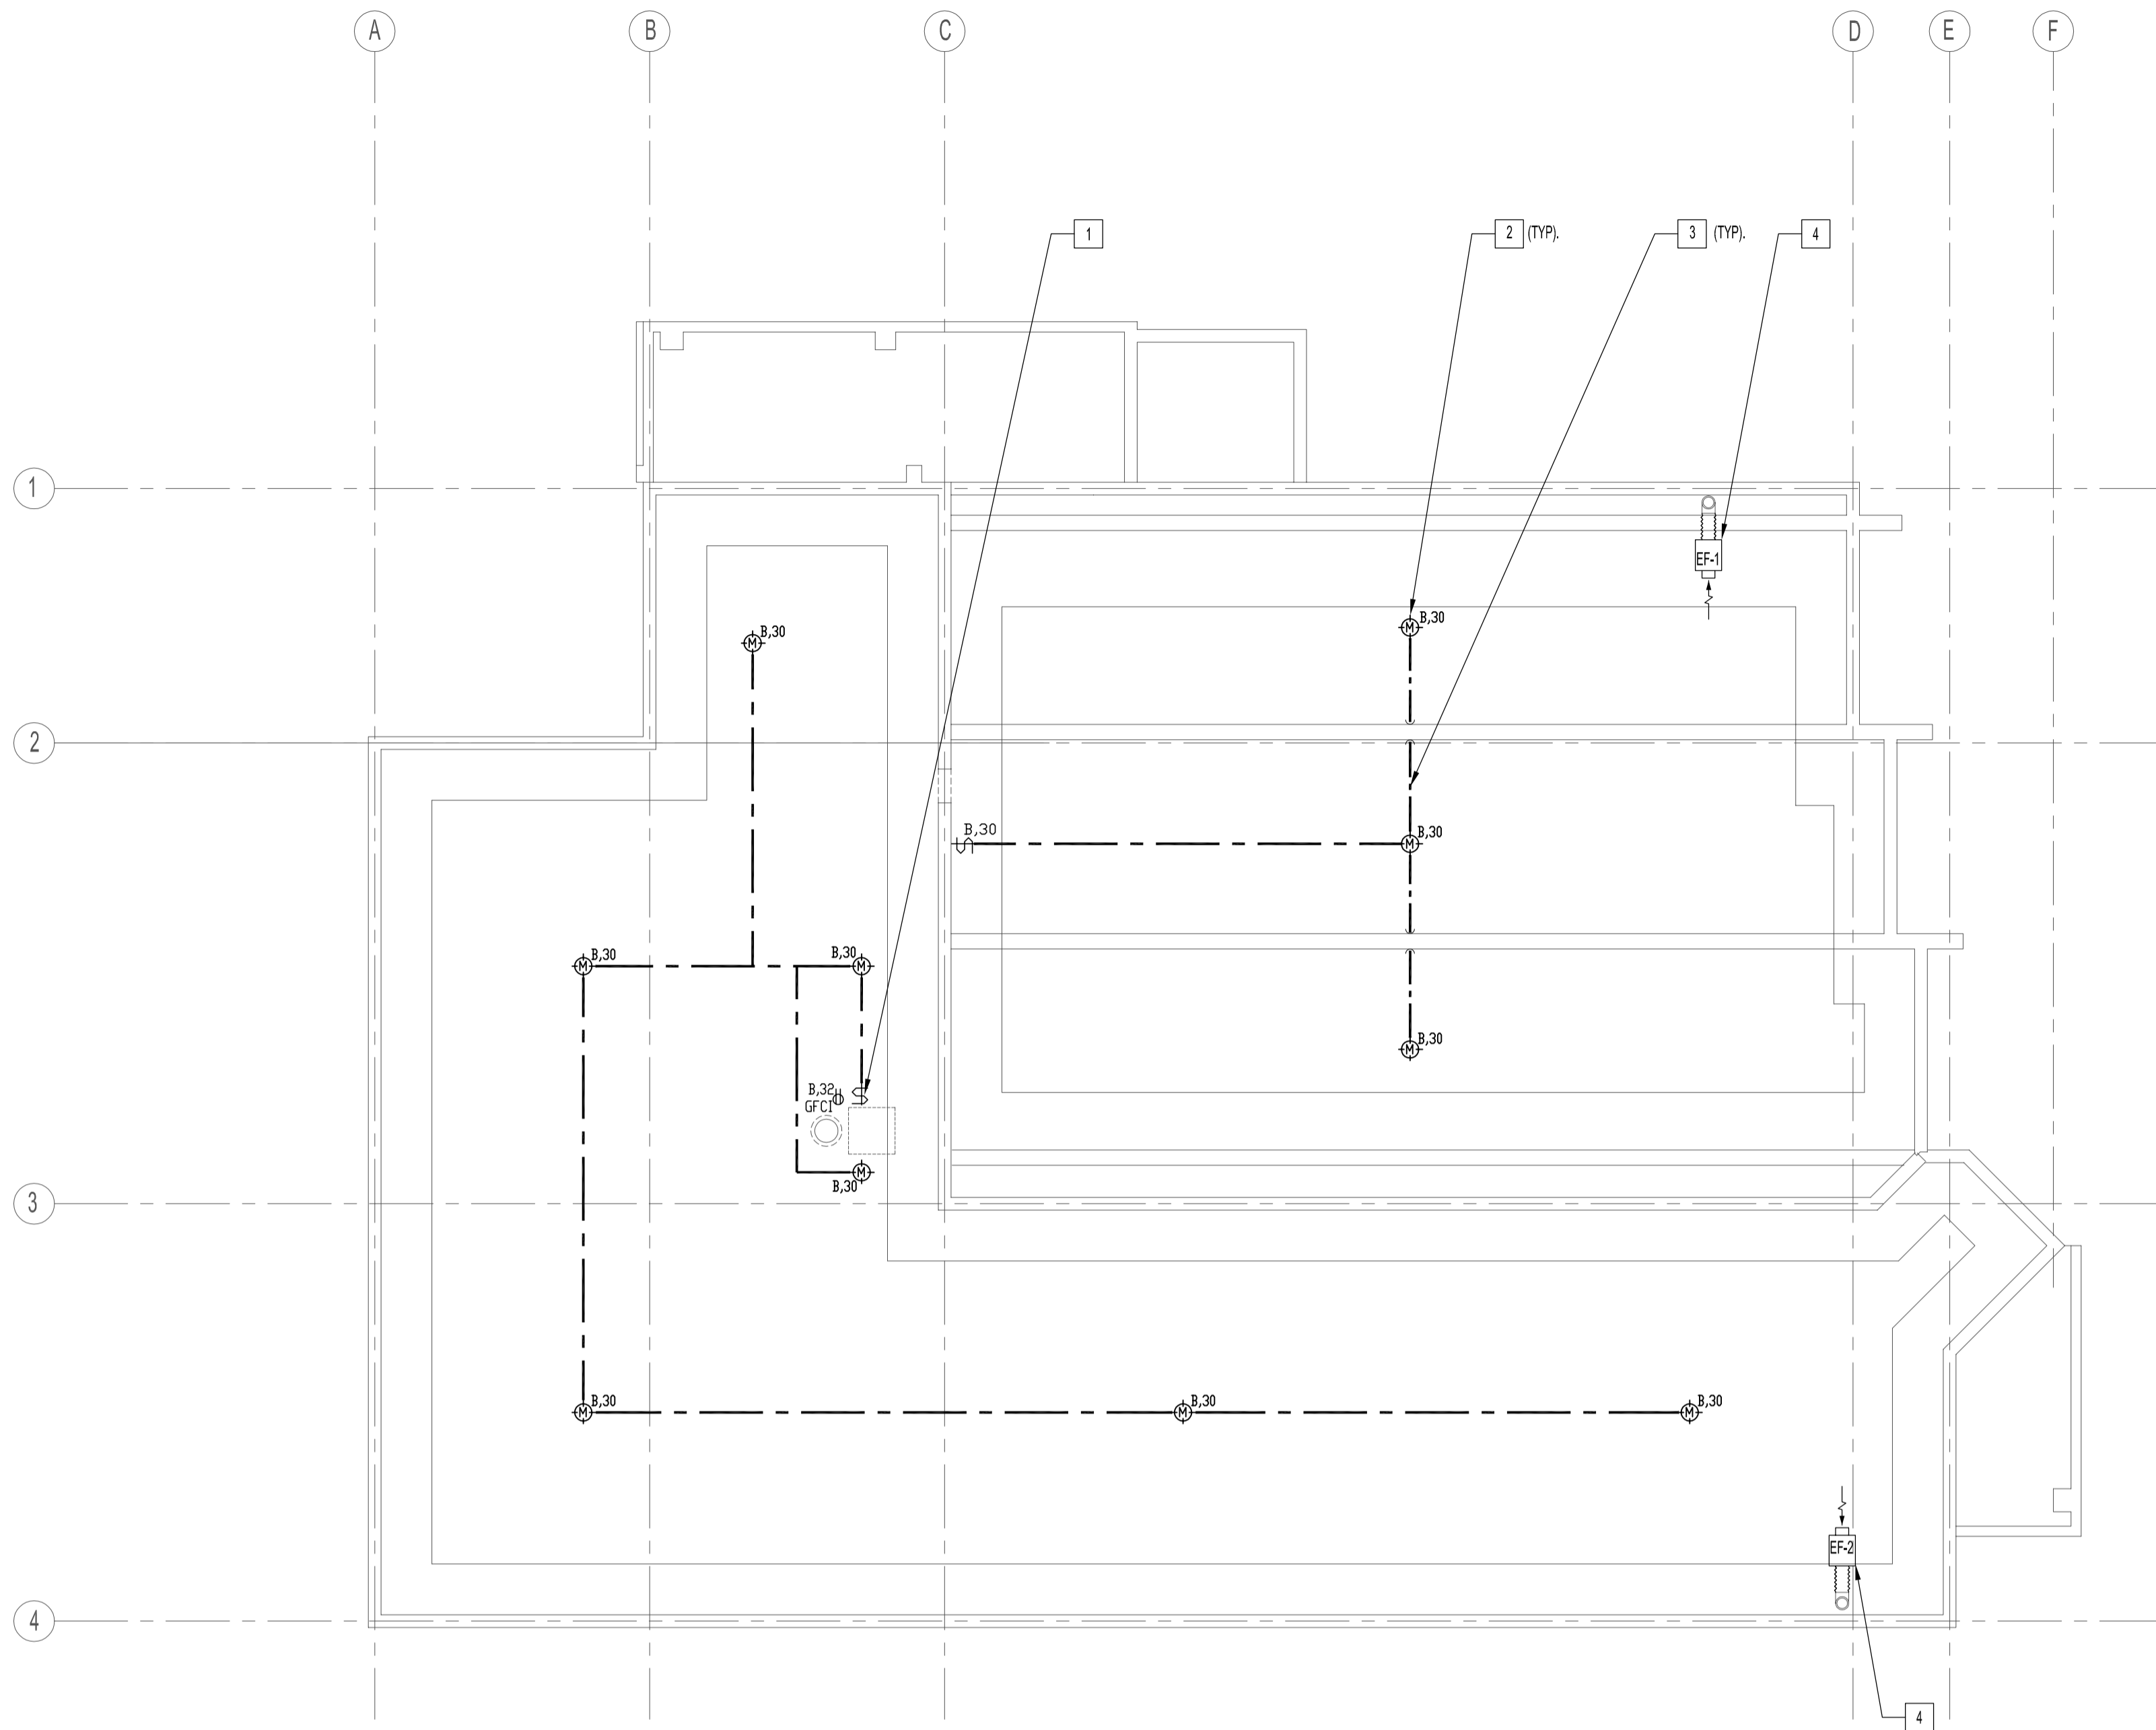

 CRAWL SPACE FLOOR PLAN - ELECTRICAL AND LIGHTING
SCALE: 1:100


- 1 SUPPLY & INSTALL PVC DEVICE BOXES FOR LIGHT SWITCH & RECEPTACLE UNDERSIDE OF BASEMENT FLOOR.
- 2 SUPPLY & INSTALL LIGHT FIXTURES, TYPE 'M' TO UNDERSIDE OF CRAWLSPACE CEILING.
- 3 RUN ALL ELECTRICAL WIRING IN 12MM Ø PVC CONDUIT FASTENED TO UNDERSIDE OF CRAWLSPACE CEILING. WHERE NECESSARY ROUTE ALL CONDUIT UNDER GRADE BEAMS. NO PENETRATIONS THROUGH CONCRETE STRUCTURE ARE ALLOWED. ALL ELECTRICAL WIRING BY DIVISION 26. SEE SPECIFICATIONS.
- 4 SUPPLY & INSTALL ELECTRICAL SERVICES FOR EF-1 & EF-2. SEE MECH. DWG. FOR INSTALLATION. ALL ELECTRICAL WIRING BY DIVISION 26. SEE SPECIFICATIONS.

NOTES :
SEE NOTES ON DRAWING E1.

ORIGINAL STAMPED BY: DOUG PALEY, P.ENG.
DATE: 2006.07.14

NO.	REVISION/DESCRIPTION	BY	DATE
SEALS			

DRAWN BY	CHECKED BY	APPROVED
RCP/DTA		
DATE	2006.07.14	USER APPROVAL

 CITY OF WINNIPEG
PLANNING, PROPERTY &
DEVELOPMENT DEPARTMENT
CIVIC ACCOMMODATIONS DIVISION
300 - 65 GARRY ST. R3C 4K4

PROJECT
WEST TRANSCONA
FIRE PARAMEDIC STATION 21

1446 REGENT AVE. WEST

SHEET TITLE
CRAWL SPACE FLOOR PLAN
ELECTRICAL & LIGHTING

METRIC
WHOLE NUMBERS ARE IN MILLIMETRES,
DECIMALIZED NUMBERS ARE IN METRES

SCALE	PROJECT NO.	SHEET NO.
AS SHOWN	2004-058-01	E2

DRAWING SHEET SIZE: A1 (841mm x 594mm) PLOT 1:1