



NOTES :
SEE DRAWING M1.

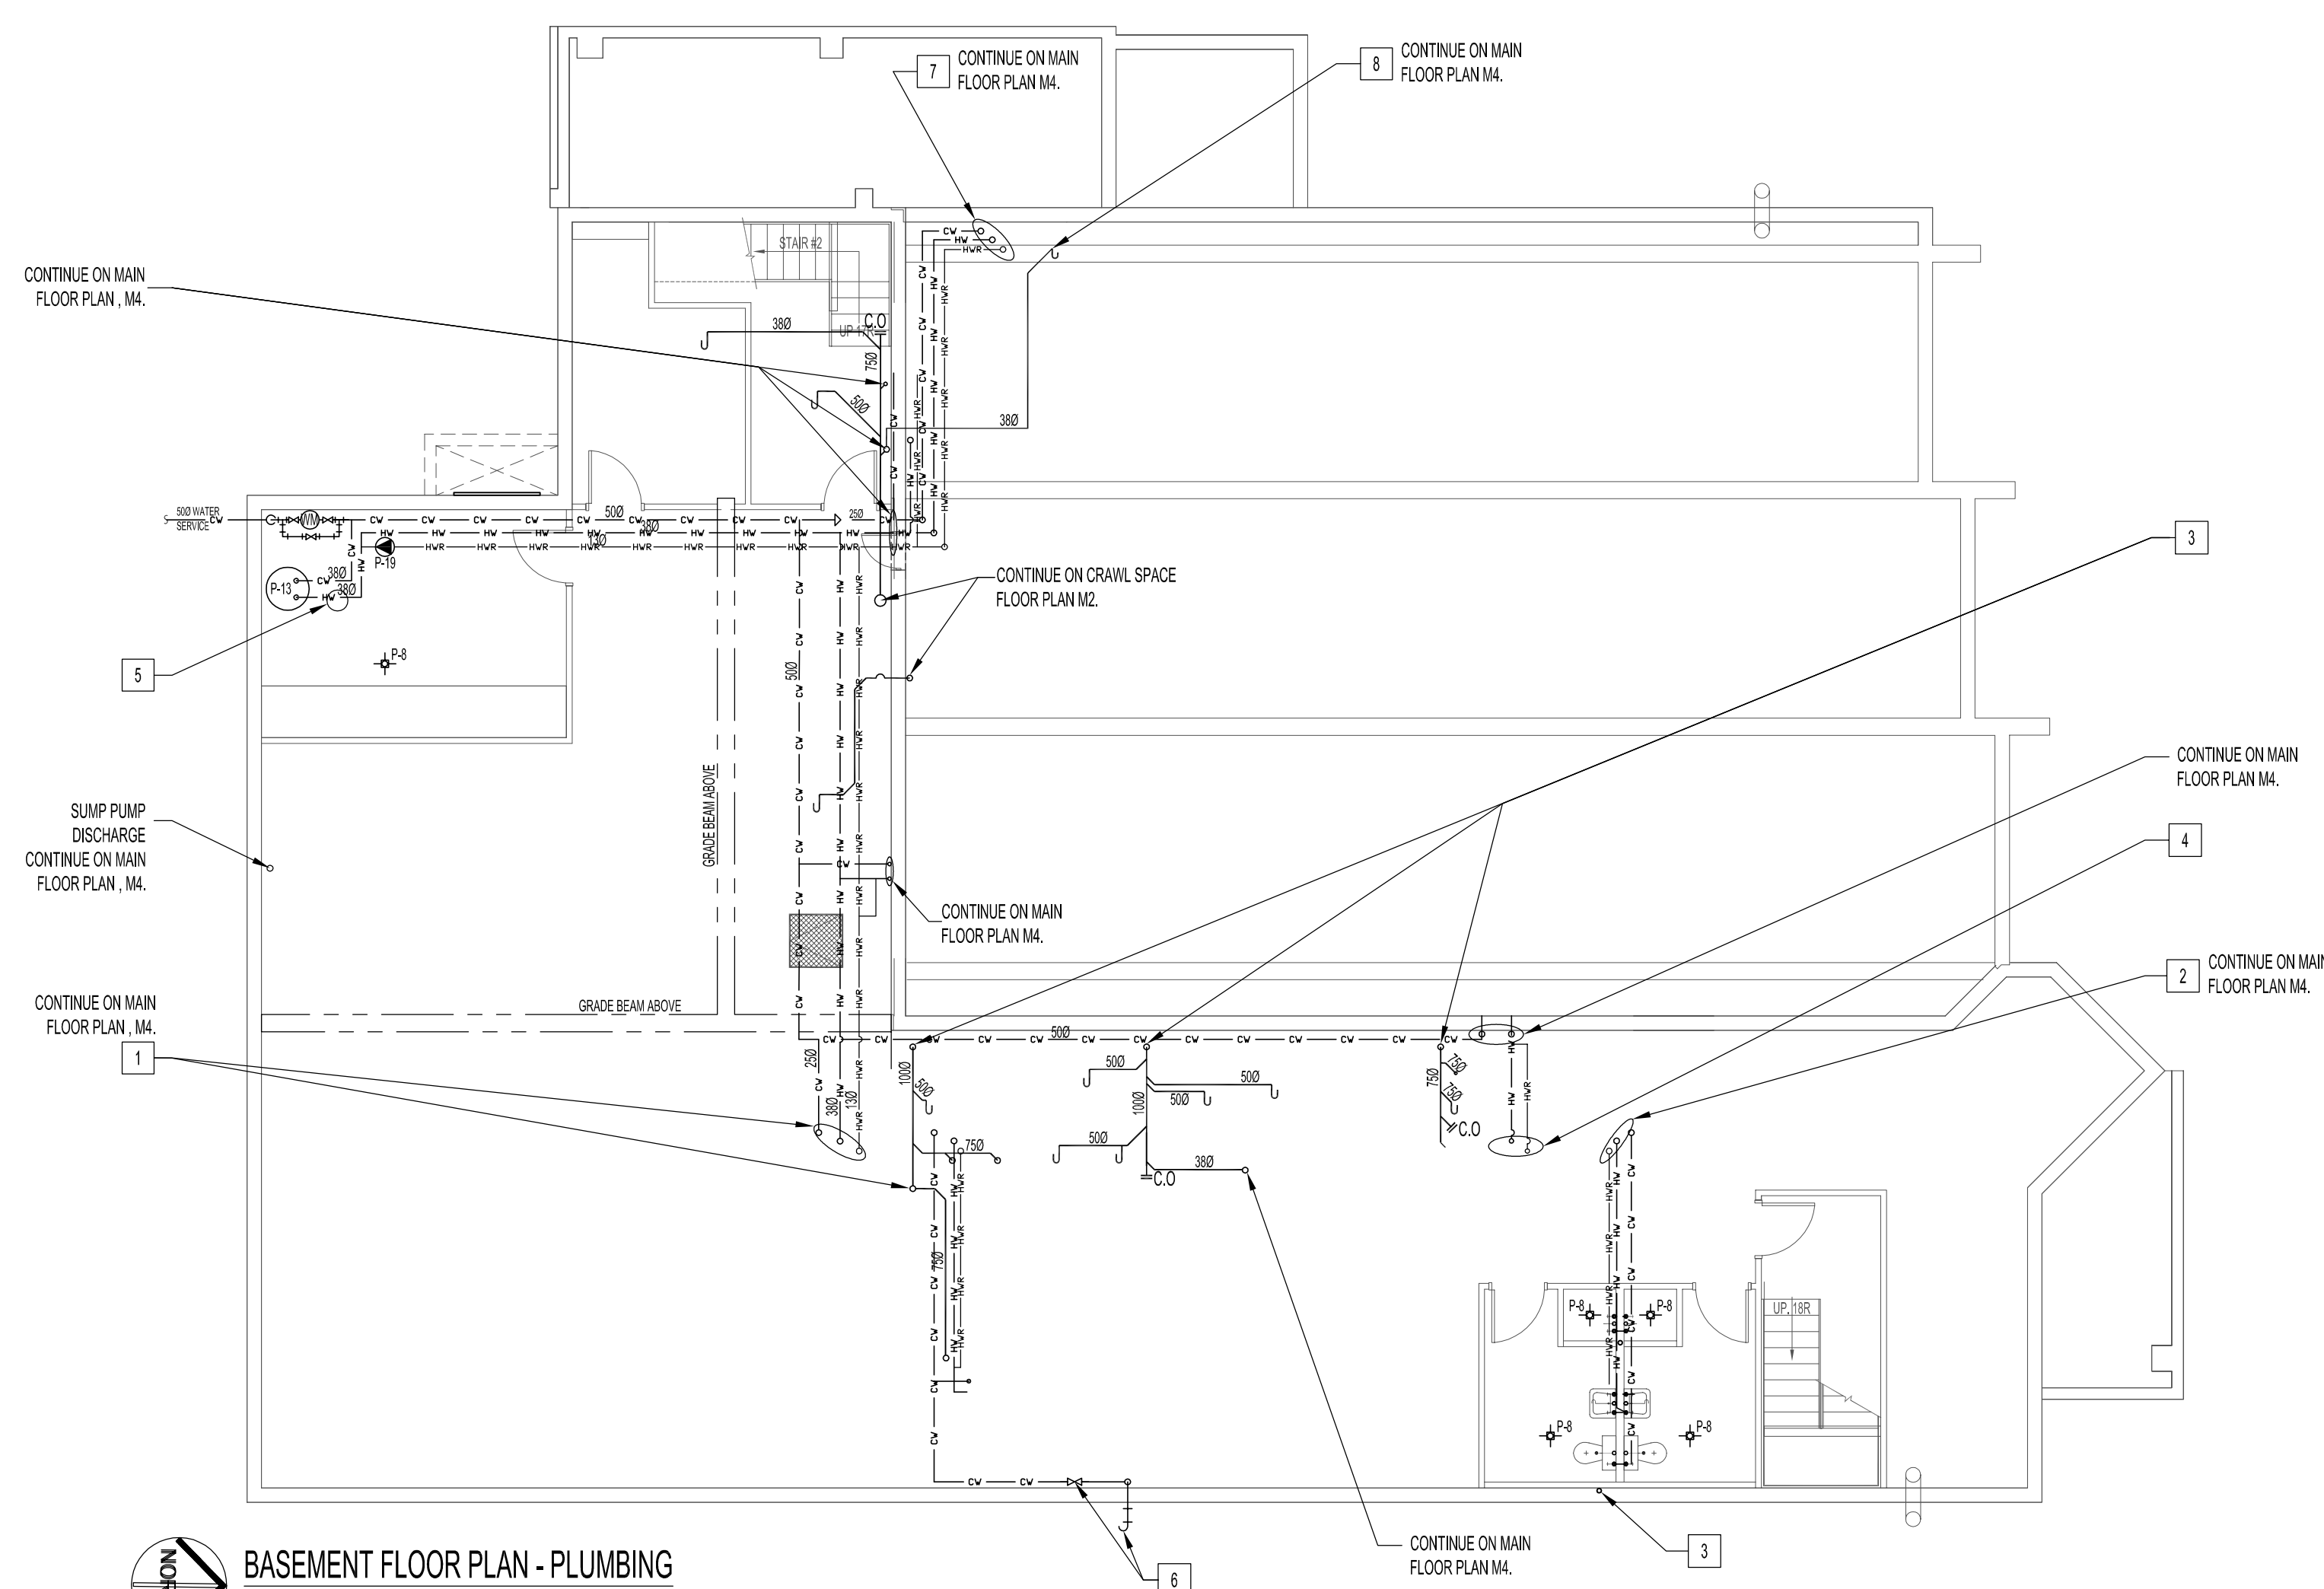

BASEMENT FLOOR PLAN - PLUMBING
SCALE: 1:50

- 1 SUPPLY & RETURN WATER LINES INSIDE MAIN FLOOR WALL. ALL FIXTURES REQUIRING HOT WATER SHALL BE CONNECTED TO THE HOT WATER RETURN (HWR) FOR RECIRCULATION.
- 2 RUN SUPPLY & RETURN WATER LINES ABOVE CENTERLINE OF BASEMENT WASHROOM WALL AND INSIDE WASHROOM WALL. ALL FIXTURES REQUIRING HOT WATER SHALL BE CONNECTED TO THE HOT WATER RETURN (HWR) FOR RECIRCULATION.
- 3 VENT PIPE RUNS UP INTO ATTIC SPACE.
- 4 HW & HRW COMING DOWN FROM MAIN FLOOR WALL CAVITY TO BASEMENT CEILING THEN TO APPARATUS EAST WALL.
- 5 PROVIDE VALVE PIT FOR BACKWATER VALVE, P-15, CW SECURE COVER. ADDITIONAL HEIGHT OF CAST IRON PIPE BETWEEN CLEANOUT FERRULE & BACKWATER VALVE BODY TO BRING CLEANOUT UP TO ACCESSIBLE SURFACE HEIGHT. LOCATION MAYBE IN CRAWL SPACE. SUPPLY & INSTALL.
- 6 WALL HYDRANT, P-11, 450 ABOVE GRADE WITH SHUT-OFF VALVE UNDERSIDE OF MAIN FLOOR.
- 7 PENETRATION THRU APPARATUS FLOOR OF WATER SUPPLY & RETURN LINES SHALL BE FLUSH MOUNTED AGAINST WALL ABOVE.
- 8 EMERGENCY SHOWER/EYE WASH STATION. PROVIDE DRAIN LINE WITH P-TRAP IN APPARATUS CRAWL SPACE TO WASTE STACK SHOWN.

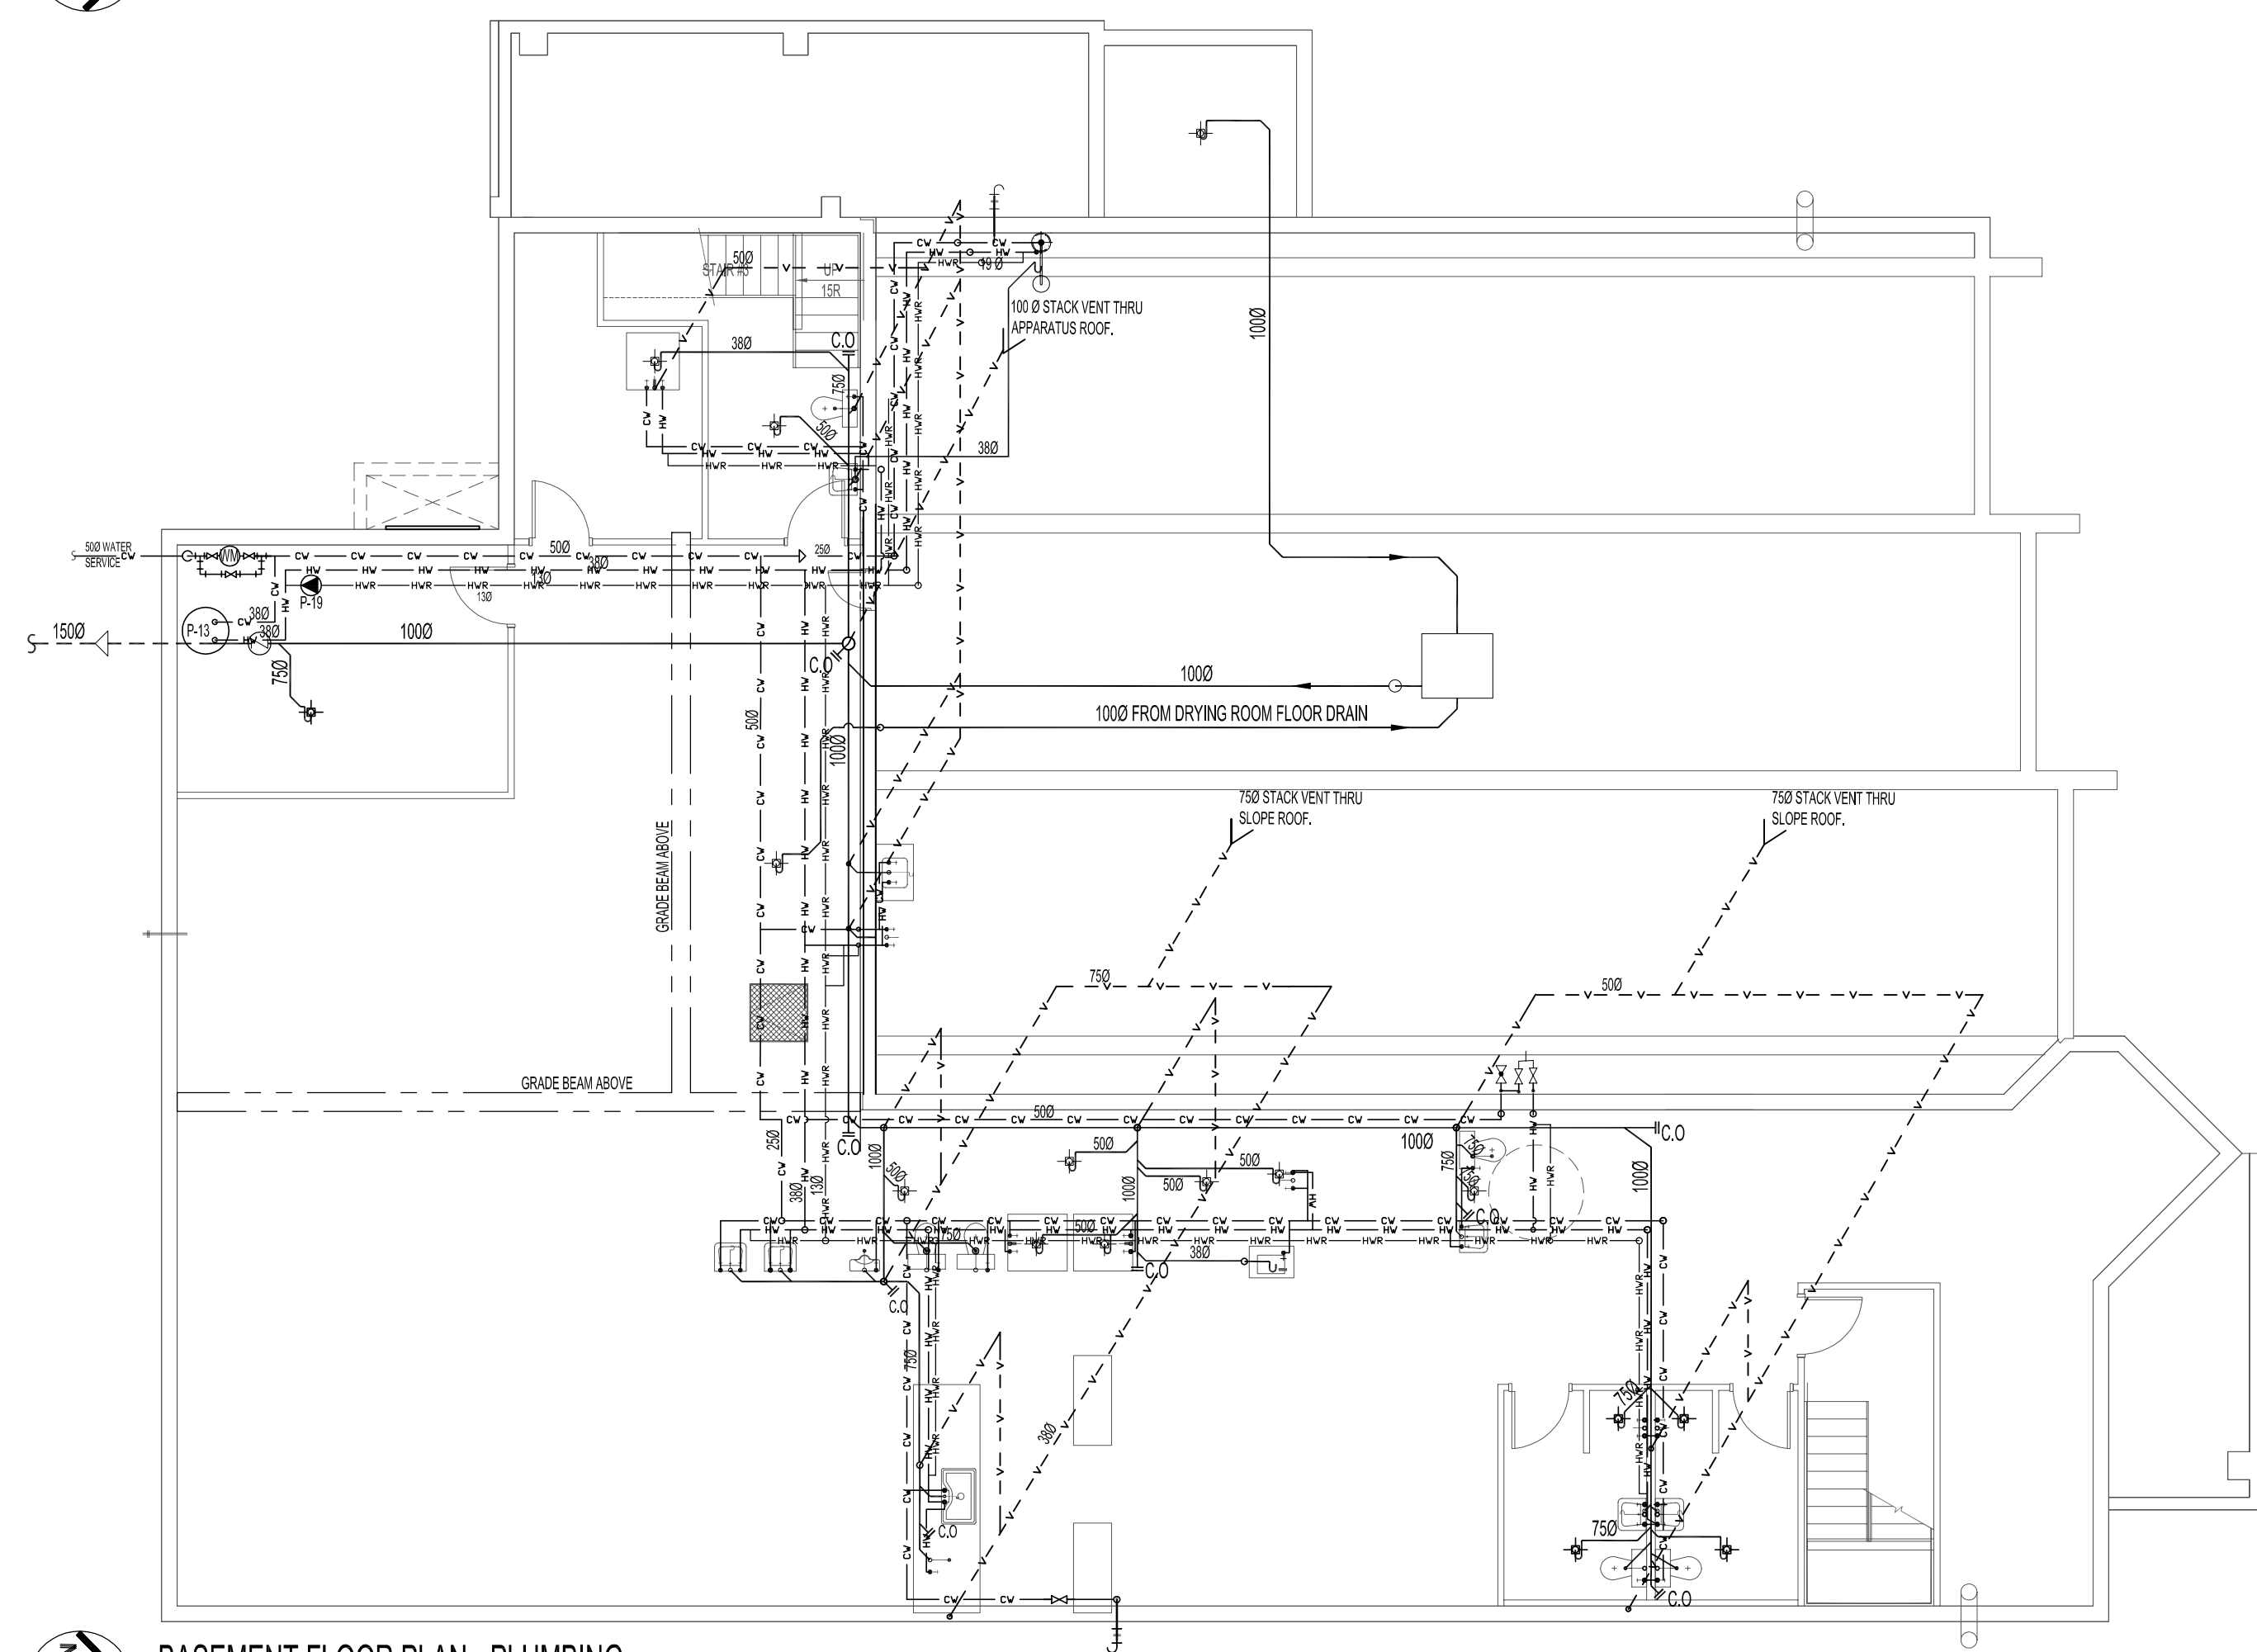

BASEMENT FLOOR PLAN - PLUMBING
SCALE: 1:50 (CRAWL SPACE & MAIN FLOOR PLUMBING FIXTURES SHOWN FOR CLARITY)

ORIGINAL STAMPED BY: DOUG PALEY, P.ENG
DATE: 2006.07.14

NO.	REVISION/DESCRIPTION	BY	DATE
SEALS			

DRAWN BY	CHECKED BY	APPROVED
RCPI/DTA	USER APPROVAL	
DATE	2006.07.14	

CITY OF WINNIPEG
 PLANNING, PROPERTY &
 DEVELOPMENT DEPARTMENT
 CIVIC ACCOMMODATIONS DIVISION
 300 - 65 GARRY ST. R3C 4K4

PROJECT
WEST TRANSCONA
 FIRE PARAMEDIC STATION 21

1446 REGENT AVE. WEST

SHEET TITLE
BASEMENT FLOOR PLAN
PLUMBING

SCALE	PROJECT NO.	SHEET NO.
AS SHOWN	2004-058-01	M3