



CRAWLSPACE FLOOR PLAN
1:100

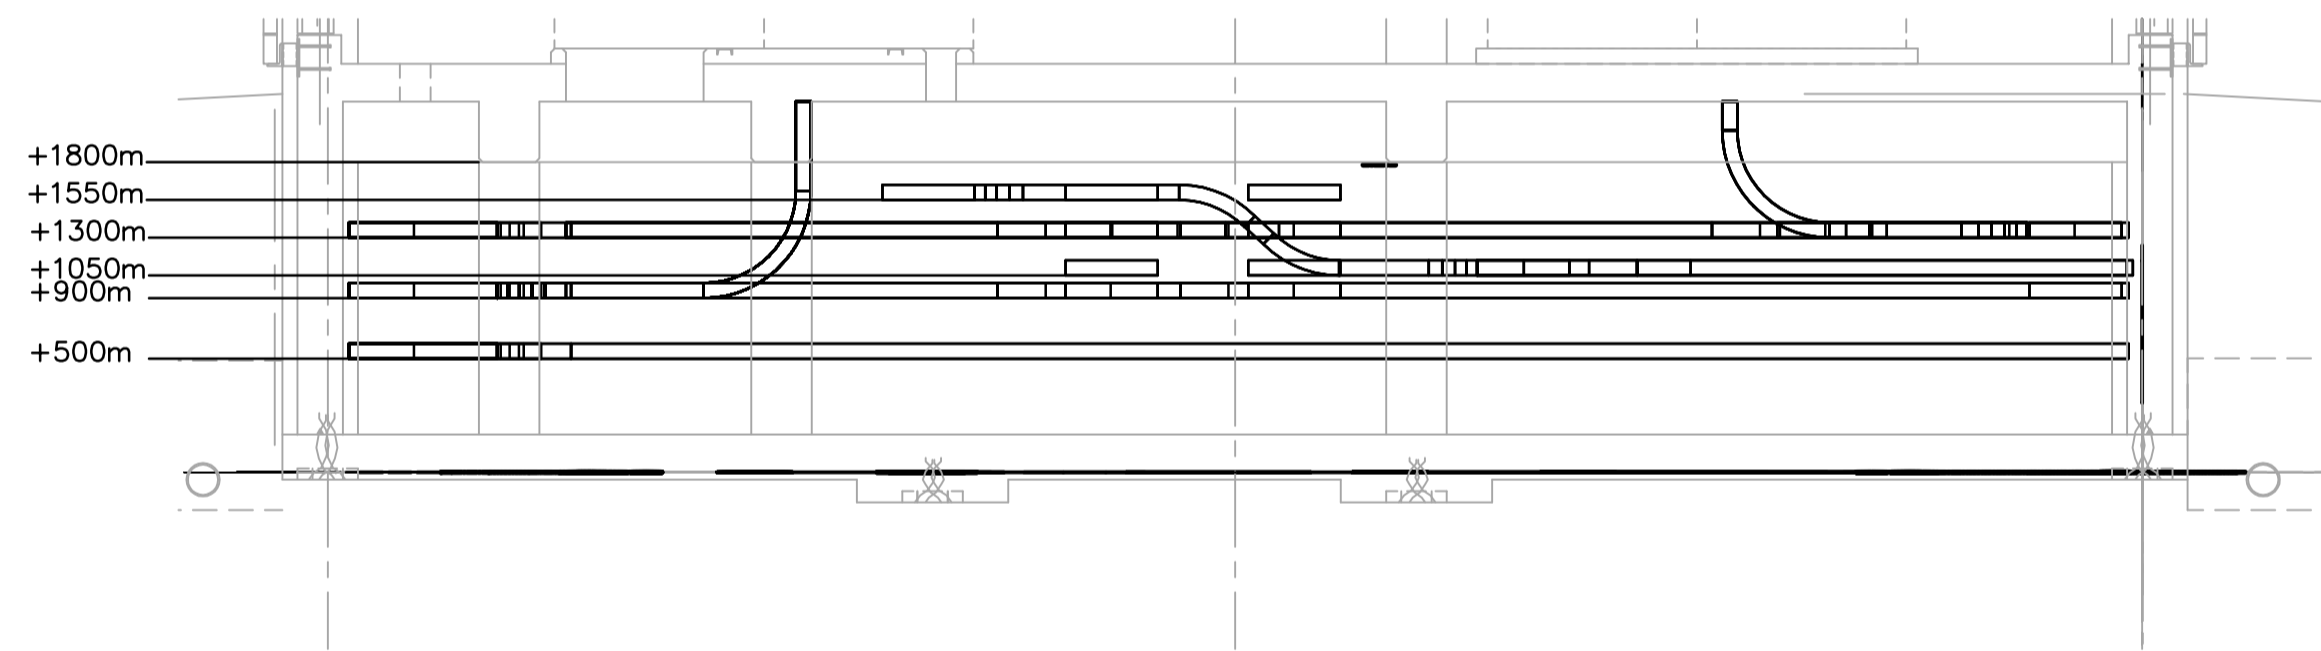

A SECTION
WG-E0102 1:50

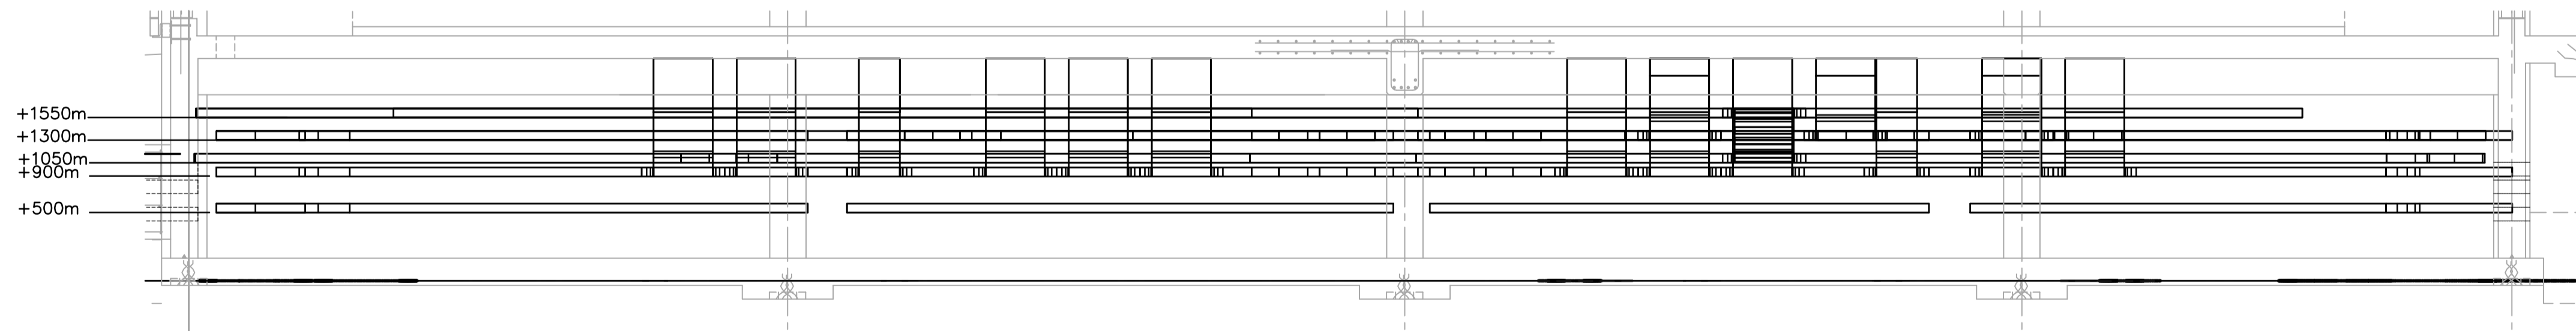

B SECTION
WG-E0102 1:50

DRAWING NOTES

1 REFER TO SHOP DRAWINGS OF CITY SUPPLIED EQUIPMENT SPECIFIED IN D2 FOR CABLE REQUIREMENTS. TECK CABLES SHALL BE USED IN PLACE OF METALLIC CONDUITS.

<p>Certificate of Authorization Earth Tech Canada Inc. No. 730 Expiry: April 30, 2007</p>	B.M. ELEV.		<p>Frederickson Cooper ARCHITECTS</p>	<p>A Type International Ltd. Company</p>	ENGINEER'S SEAL		<p>THE CITY OF WINNIPEG WATER AND WASTE DEPARTMENT ENGINEERING DIVISION</p>	CITY FILE NUMBER															
					DESIGNED BY: BLM	CHECKED BY: PS		ORIGINAL SIGNED BY: B.L. MOORE	SHEET OF														
			DRAWN BY: ERC	APPROVED BY: AHL	2006/08/30	CITY DRAWING NUMBER																	
	<table border="1"> <tr> <td>01</td> <td>498-2006 ADDENDUM 3</td> <td>06/09/29</td> <td>ERC</td> <td></td> <td></td> </tr> <tr> <td>00</td> <td>ISSUED FOR TENDER</td> <td>06/08/30</td> <td>ERC</td> <td></td> <td></td> </tr> <tr> <td>NO.</td> <td>REVISIONS</td> <td>DATE</td> <td>BY</td> <td>DATE</td> <td>2006/06/13</td> </tr> </table>		01	498-2006 ADDENDUM 3	06/09/29	ERC				00	ISSUED FOR TENDER	06/08/30	ERC			NO.	REVISIONS	DATE	BY	DATE	2006/06/13	SCALE: AS SHOWN	RELEASED FOR CONSTRUCTION BY: R. SOROKOWSKI
01	498-2006 ADDENDUM 3	06/09/29	ERC																				
00	ISSUED FOR TENDER	06/08/30	ERC																				
NO.	REVISIONS	DATE	BY	DATE	2006/06/13																		