


MAIN FLOOR PLAN

1:100

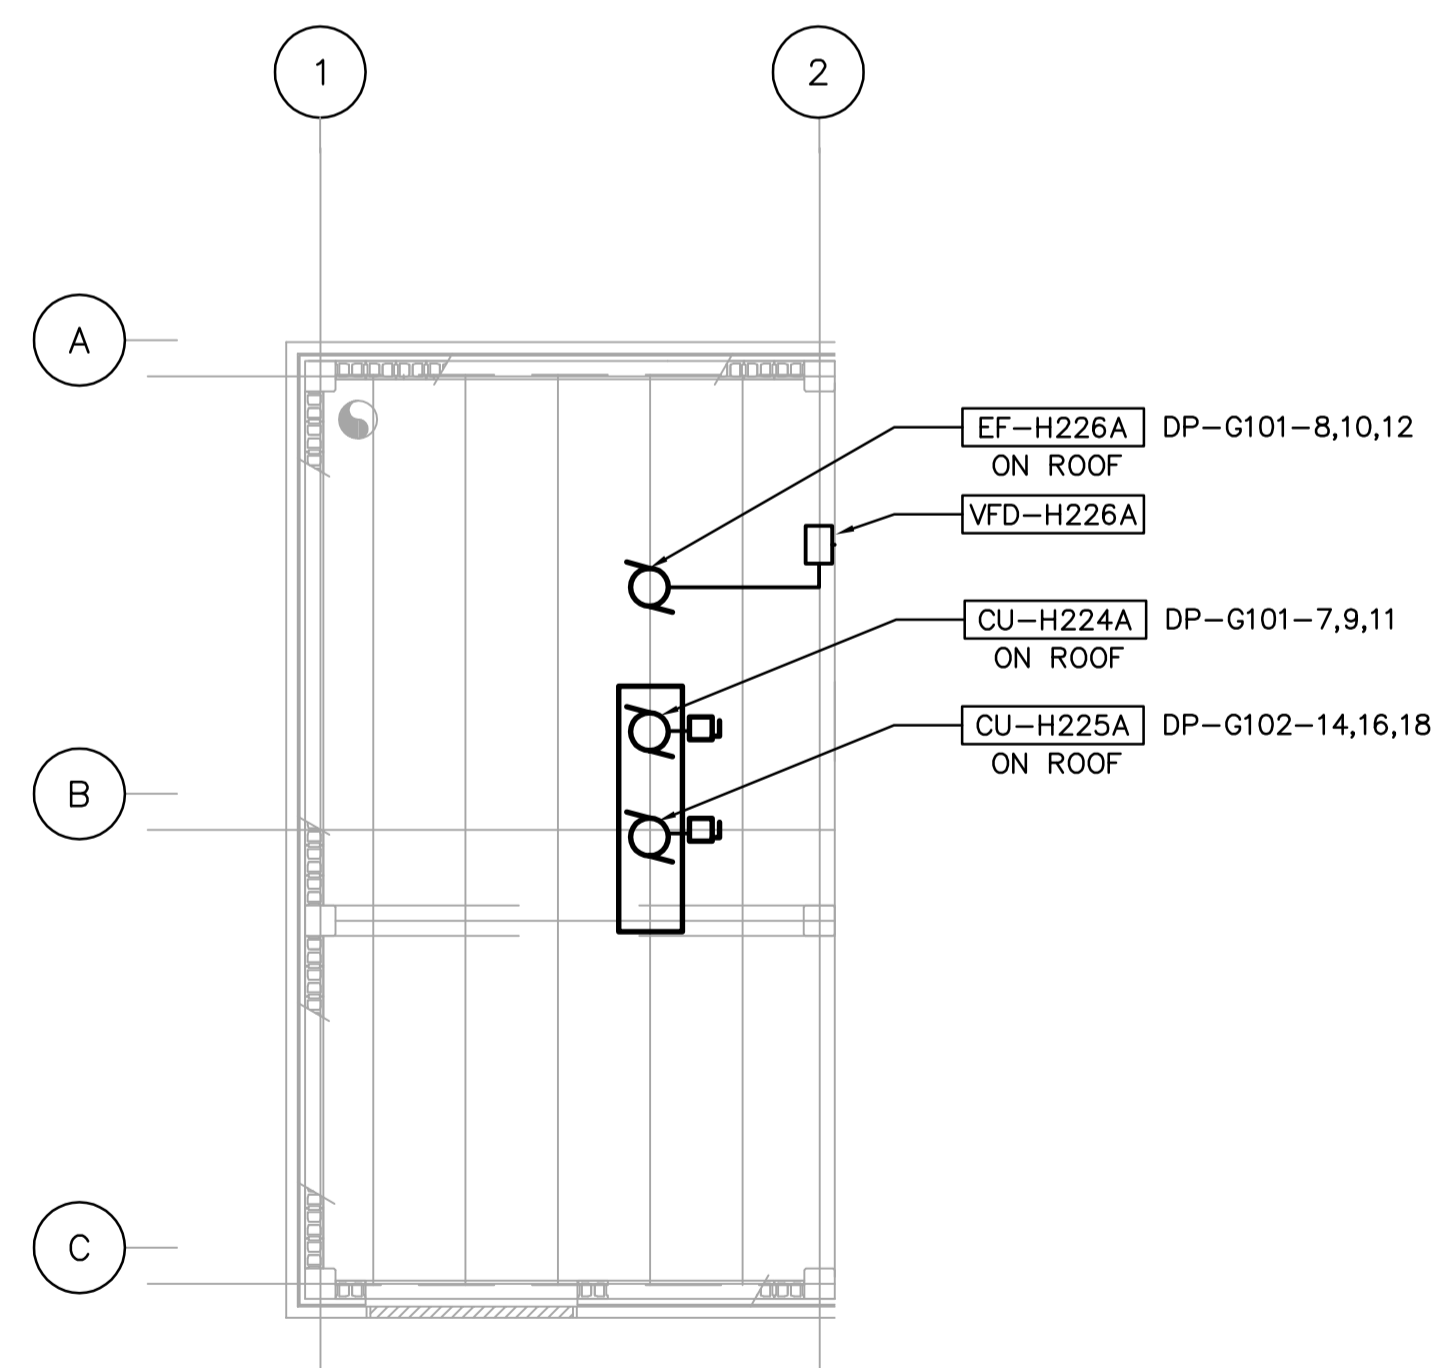

ROOF POWER PLAN

1:100

<p>Certificate of Authorization Earth Tech Canada Inc. No. 730 Expiry: April 30, 2007</p>	B.M. ELEV.	<p>Frederickson Cooper ARCHITECTS</p>	<p>A Type International Ltd. Company</p>	ENGINEER'S SEAL	<p>THE CITY OF WINNIPEG WATER AND WASTE DEPARTMENT ENGINEERING DIVISION</p>		
				DESIGNED BY BLM		CHECKED BY PS	ORIGINAL SIGNED BY B.L. MOORE
				DRAWN BY ERC		APPROVED BY AHL	2006/08/30
				SCALE: NTS		RELEASED FOR CONSTRUCTION BY: R. SOROKOWSKI	CONSULTANT DRAWING NO. WG-E0112
01 498-2006 ADDENDUM 3 06/09/29 ERC					CITY FILE NUMBER		
00 ISSUED FOR TENDER 06/08/30 ERC					SHEET OF		
NO. REVISIONS	DATE	BY	DATE	2005/10/03	2006/08/30	CITY DRAWING NUMBER	
						1-0601G-A-E0112-001-010	