




1 CRAWLSPACE PLUMBING PLAN  
1:100

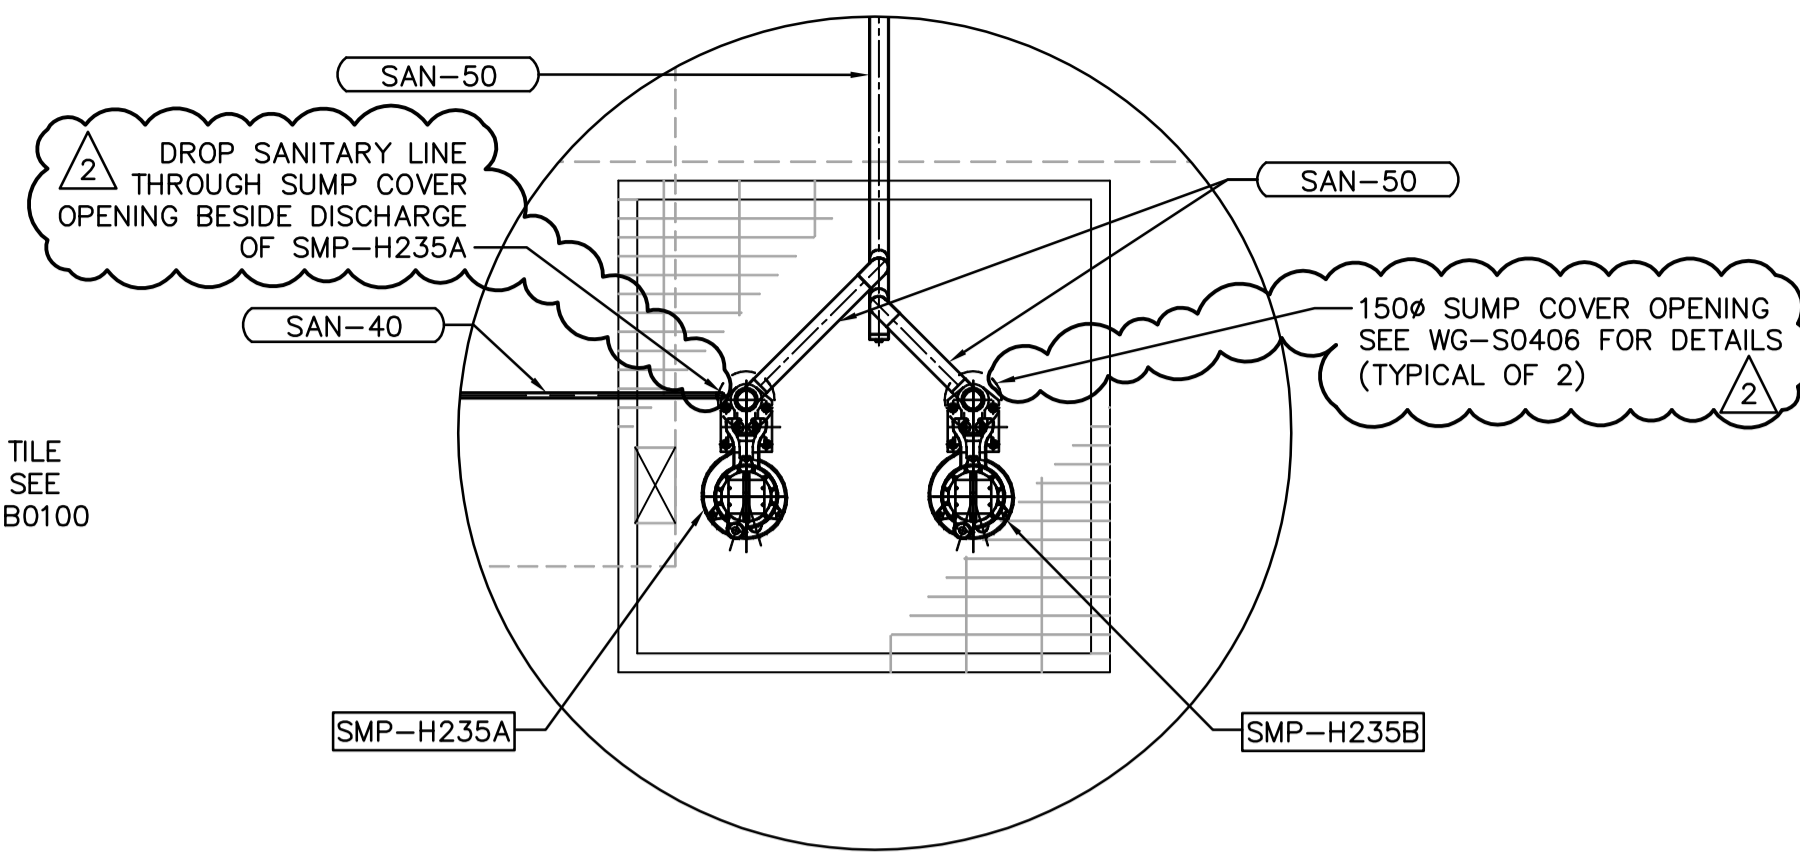

A SUMP PUMP PARTIAL PLAN  
1:20

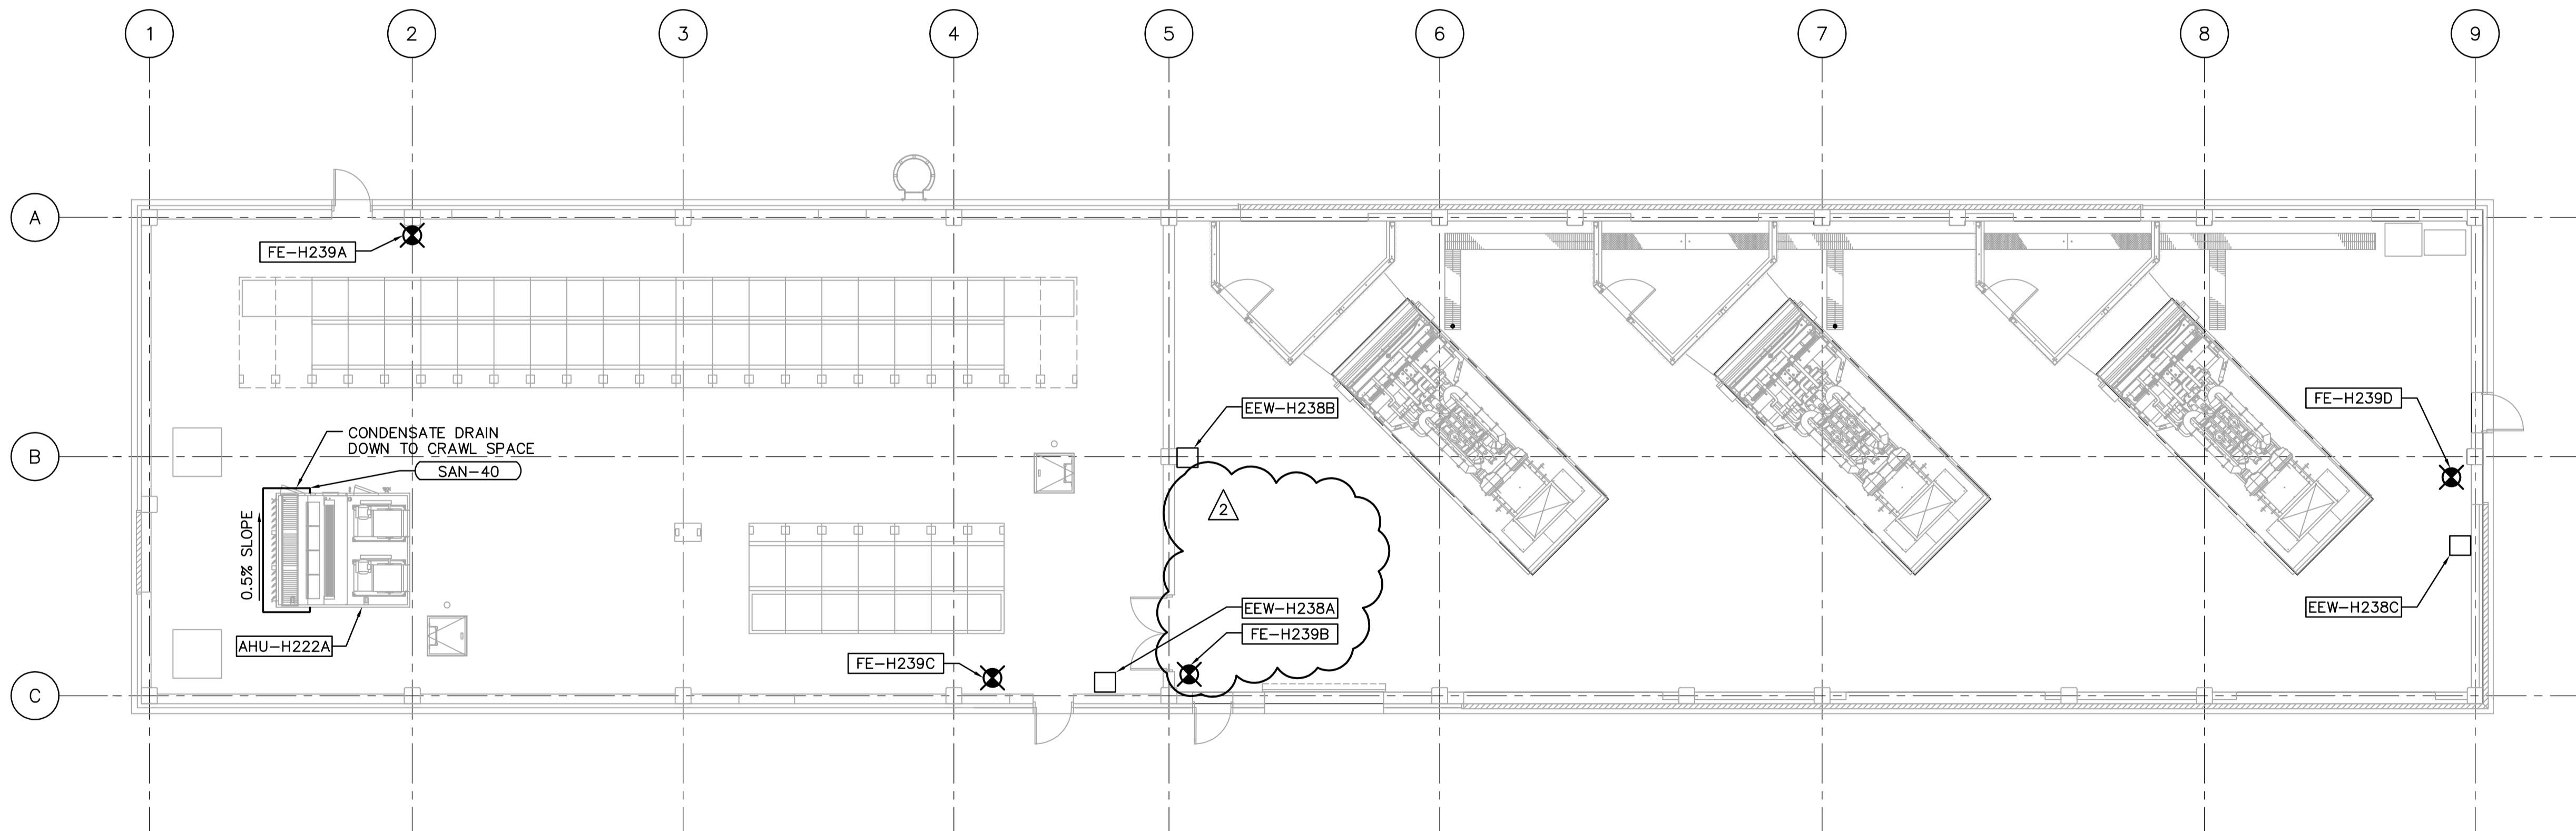

2 MAIN FLOOR FIRE PROTECTION PLAN  
1:100

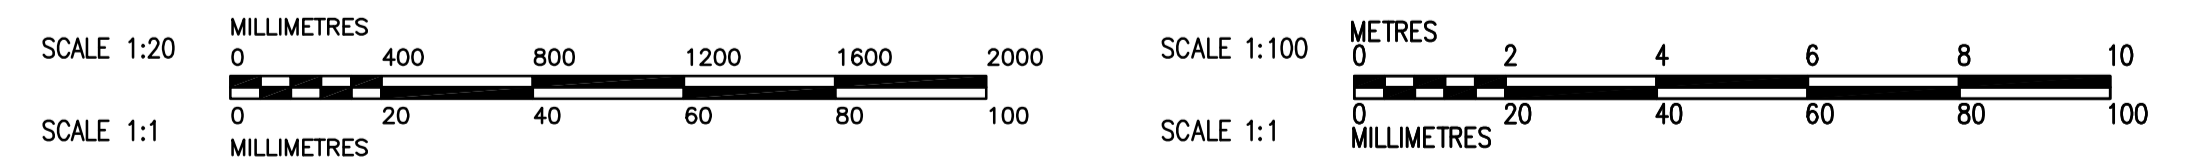

B.M. ELEV.		 Frederickson Cooper ARCHITECTS		 A Tyco International Ltd. Company		ENGINEER'S SEAL ORIGINAL SIGNED BY A. BURACHYNSKY 2006/08/30		 <b>THE CITY OF WINNIPEG</b> WATER AND WASTE DEPARTMENT ENGINEERING DIVISION	
DESIGNED BY AB		CHECKED BY AMA, PVL		APPROVED BY AHL		CONSULTANT DRAWING NO. WG-H0100		CITY FILE NUMBER	
DRAWN BY DJP		SCALE: AS NOTED		RELEASED FOR CONSTRUCTION BY: R. SOROKOWSKI		MECHANICAL PLUMBING PLAN CRAWLSPACE PLAN AND MAIN LEVEL PLAN		SHEET OF	
NO. REVISIONS		DATE BY		DATE 2006/05/15		DATE 2006/08/30		CITY DRAWING NUMBER 1-0601G-A-H0100-001-02D	