



MAIN FLOOR PLAN
1:100

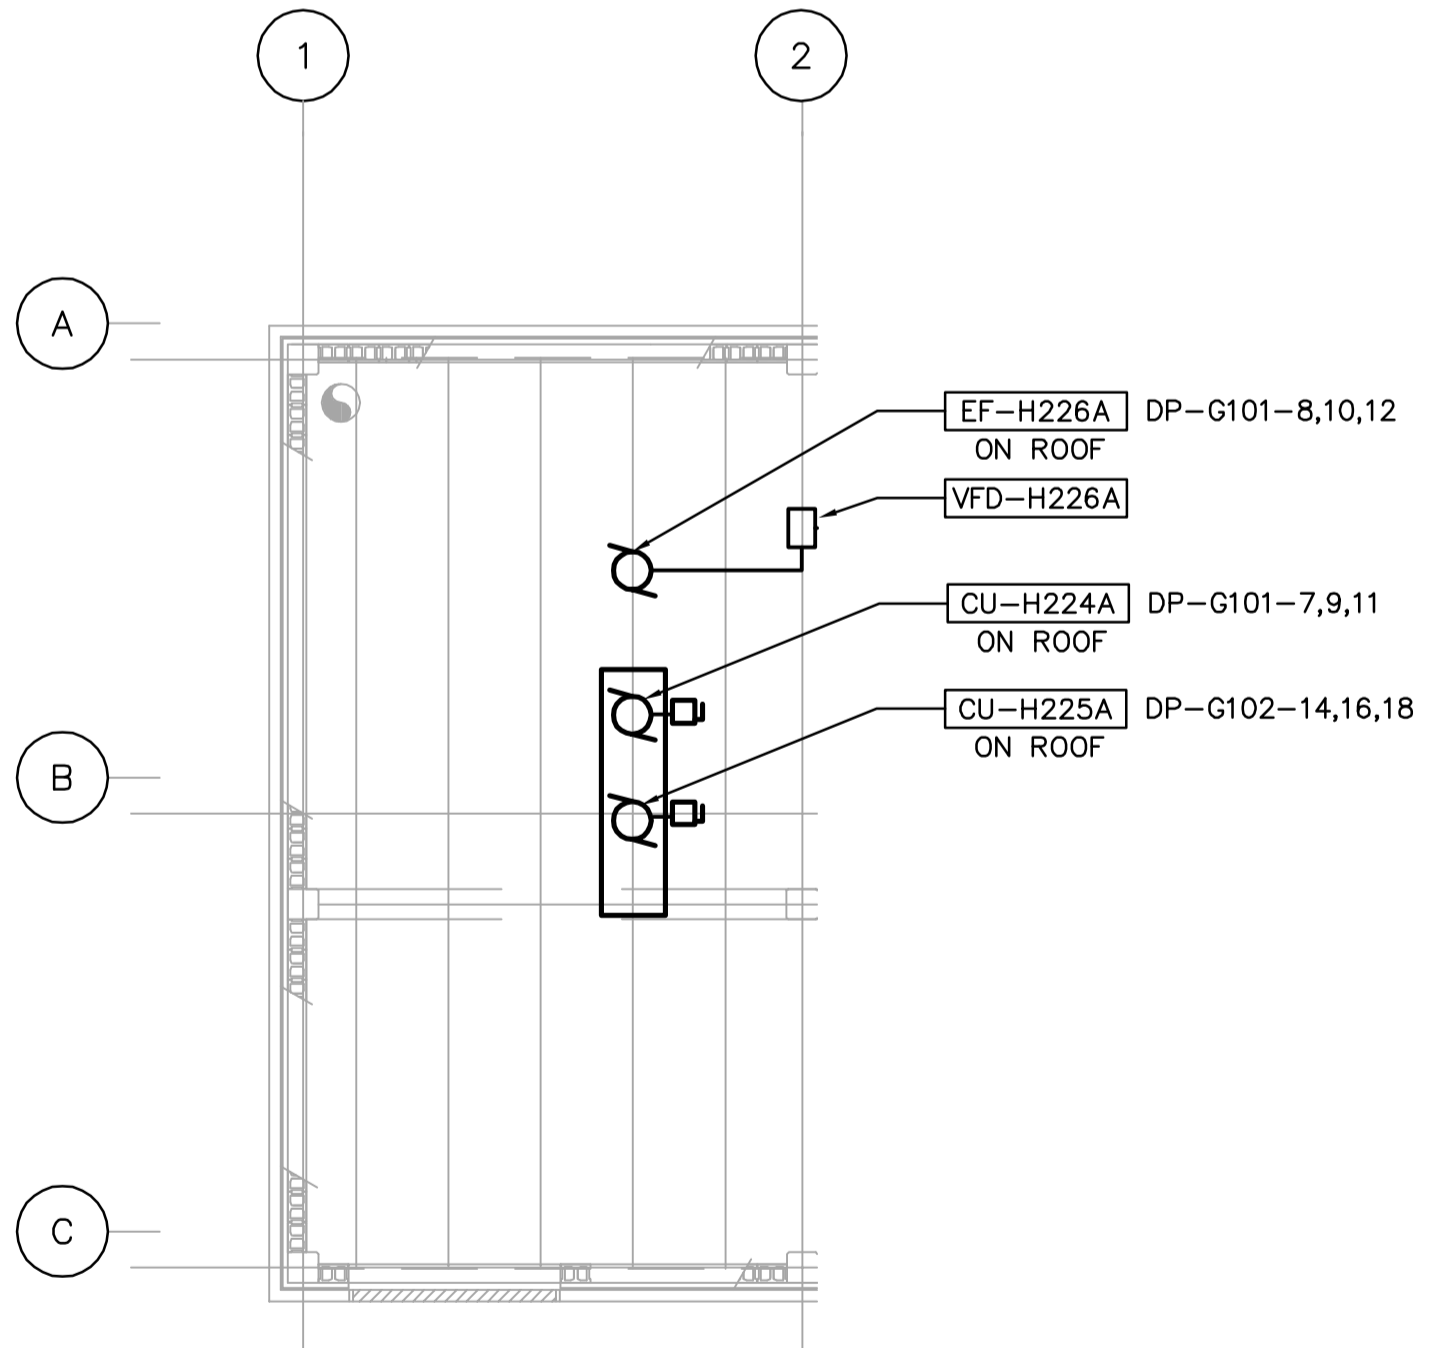

ROOF POWER PLAN
1:100

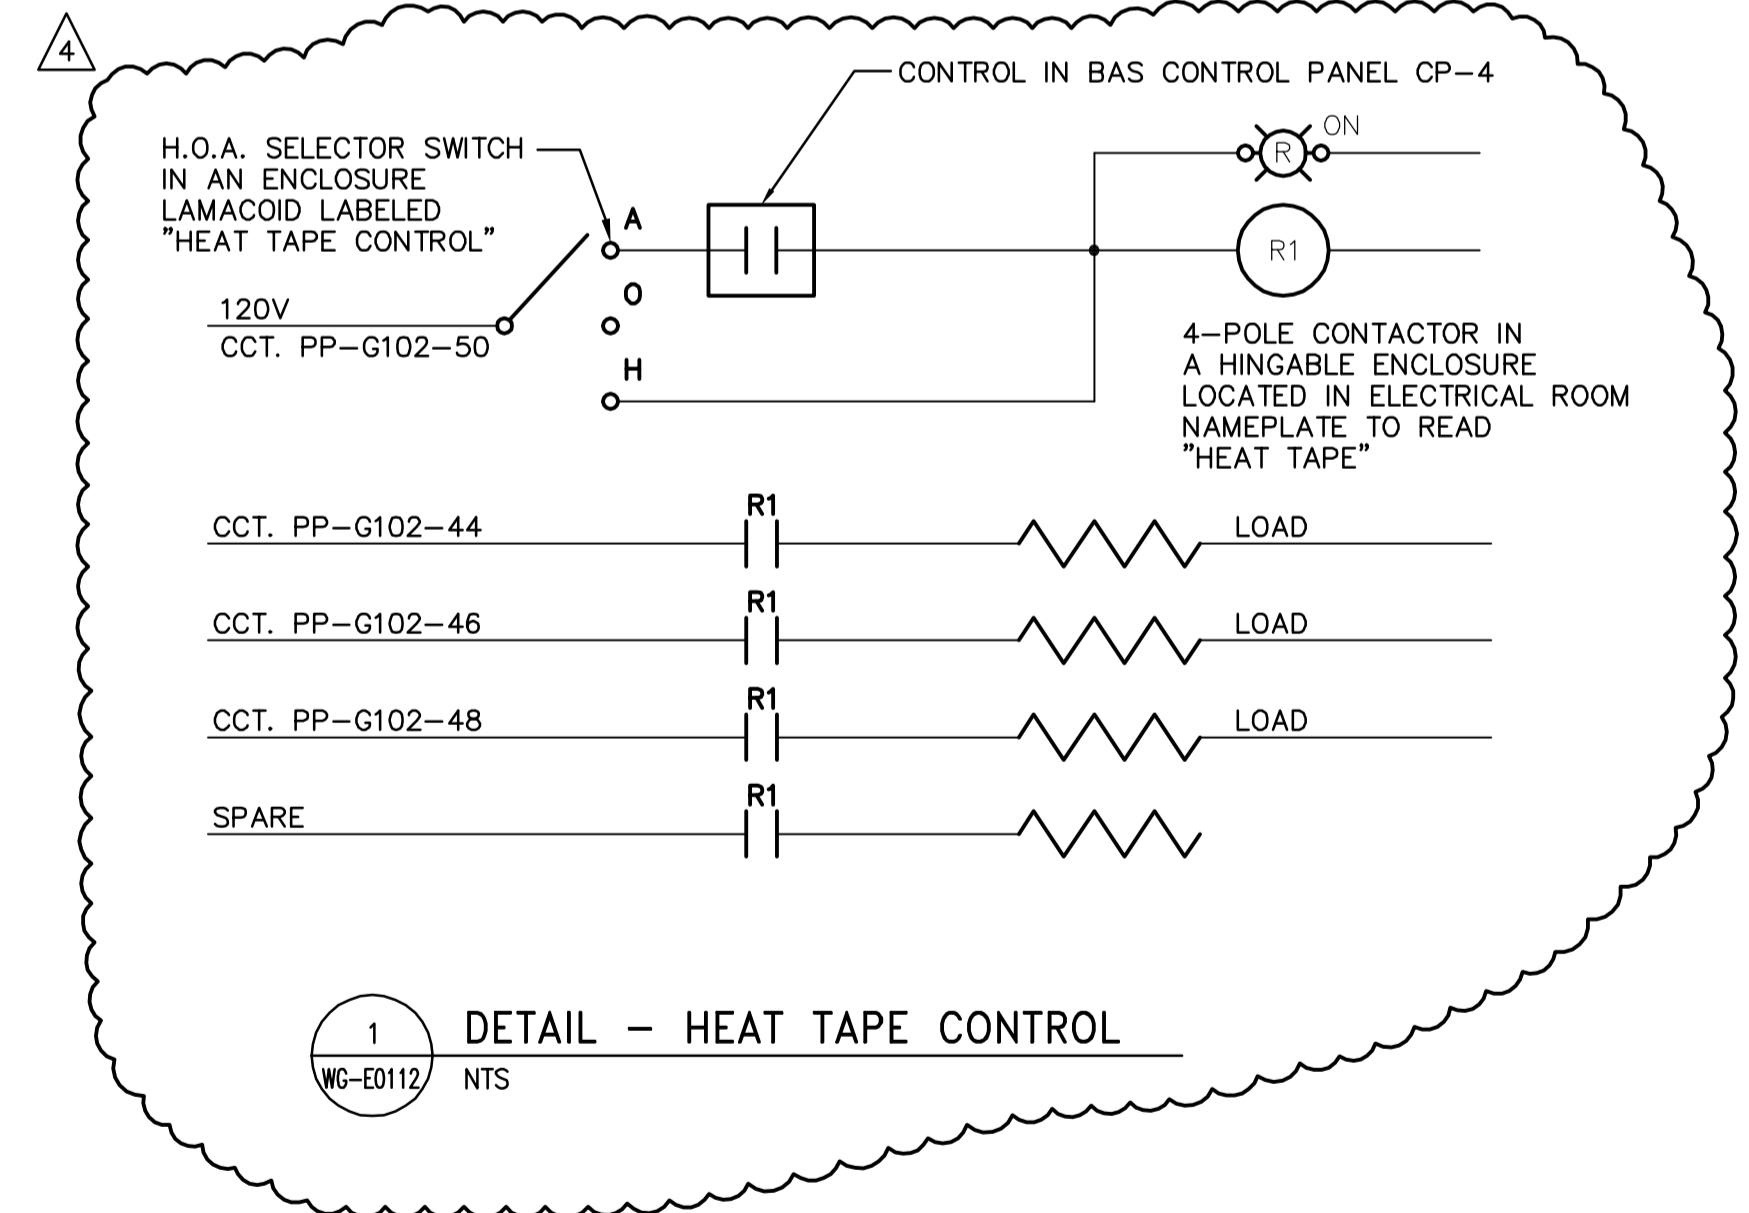

1
WG-E0112 NTS
DETAIL - HEAT TAPE CONTROL

<p>Certificate of Authorization Earth Tech Canada Inc. No. 730 Expiry: April 30, 2007</p>	<p>B.M. ELEV.</p>		<p>Frederickson Cooper ARCHITECTS</p>	<p>A Tech International Ltd. Company</p>	<p>ENGINEER'S SEAL</p>		<p>THE CITY OF WINNIPEG WATER AND WASTE DEPARTMENT ENGINEERING DIVISION</p>	<p>WATER TREATMENT PLANT STANDBY POWER GENERATOR GENERATOR BUILDING</p>	CITY FILE NUMBER
	<p>DESIGNED BY BLM CHECKED BY PS</p>				<p>ORIGINAL SIGNED BY B.L. MOORE 2006/08/30</p>	SHEET OF			
	<p>DRAWN BY ERC APPROVED BY AHL</p>				<p>CONSULTANT DRAWING NO. WG-E0112</p>	CITY DRAWING NUMBER			
	<p>SCALE: NTS RELEASED FOR CONSTRUCTION BY: R. SOROKOWSKI</p>				<p>DATE 2005/10/03 DATE 2006/08/30</p>	1-0601G-A-E0112-001-04D			
<p>NO. REVISIONS DATE BY</p>		<p>DATE 2005/10/03 DATE 2006/08/30</p>		<p>DATE 2005/10/23 ERC 03 498-2006 ADDENDUM 7 06/10/19 ERC 02 498-2006 ADDENDUM 4 06/10/10 ERC 01 498-2006 ADDENDUM 3 06/09/29 ERC 00 ISSUED FOR TENDER 06/08/30 ERC</p>		<p>ELECTRICAL MAIN FLOOR POWER PLAN</p>			