




4 ROOF/WALL SECTION DETAIL
WG-B0202 1:20

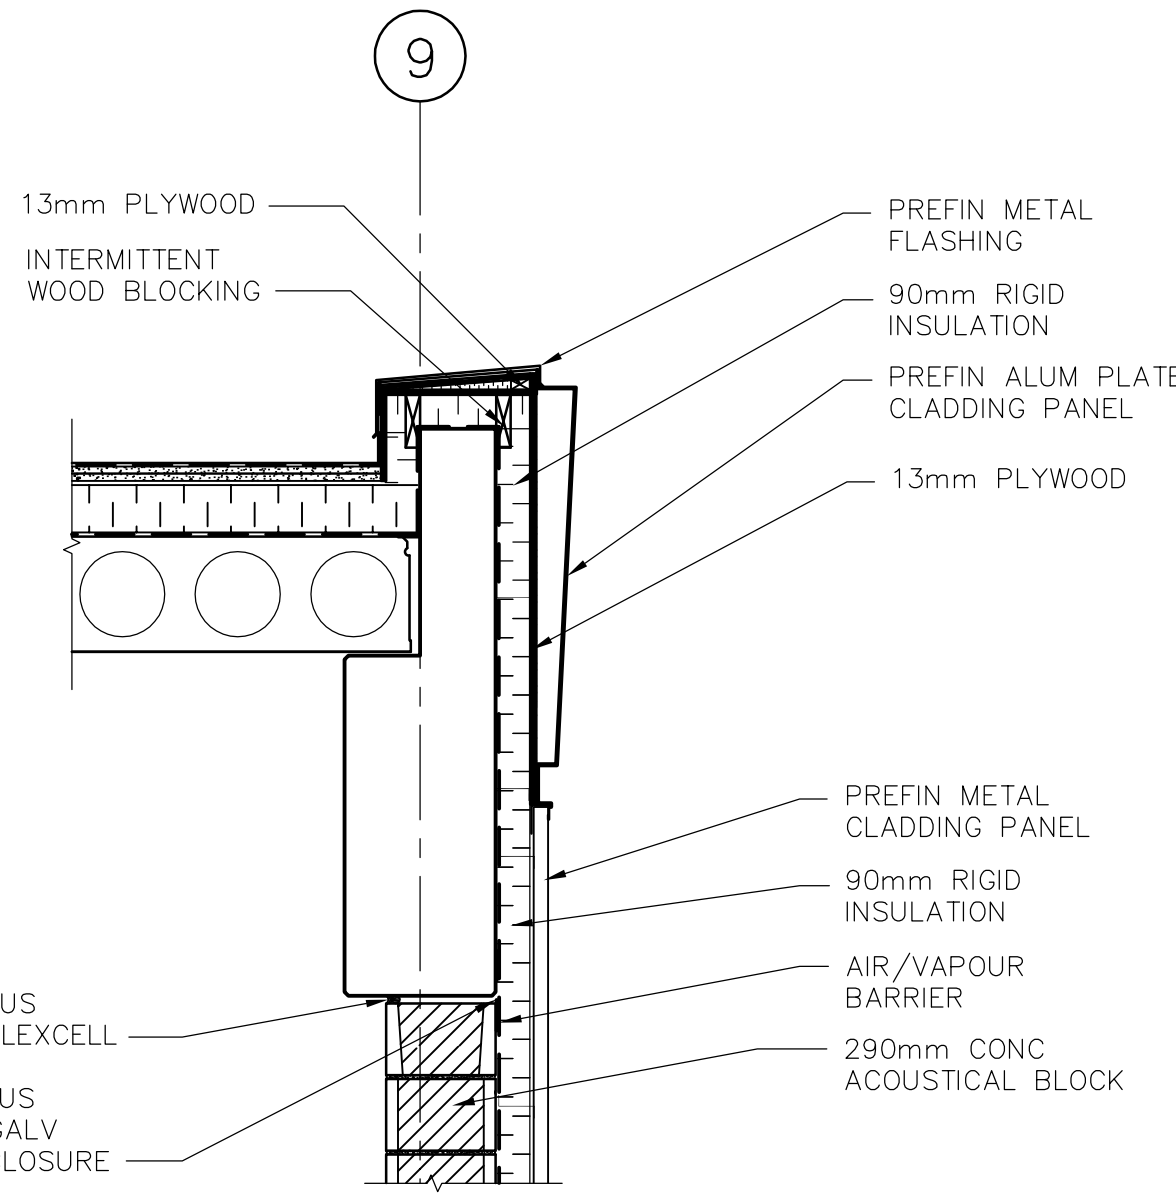


5 ROOF/WALL SECTION DETAIL
WG-B0202 1:20

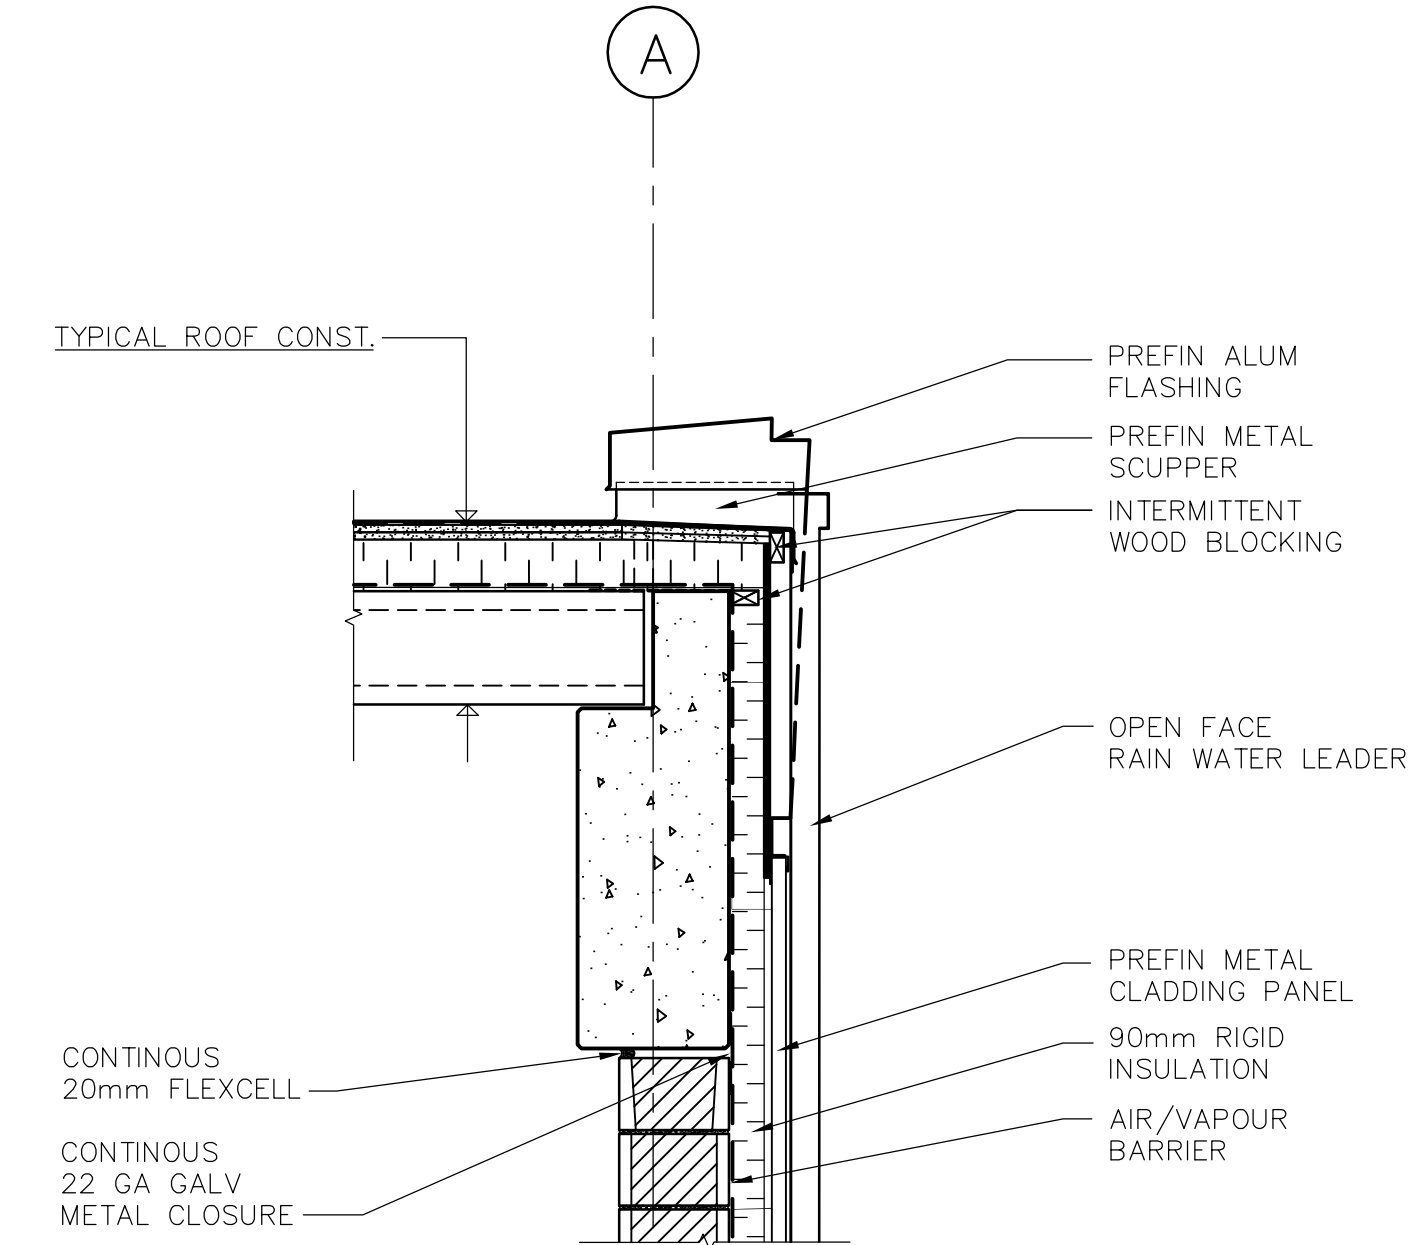


6 SCUPPER DETAIL
WG-B0140 1:20

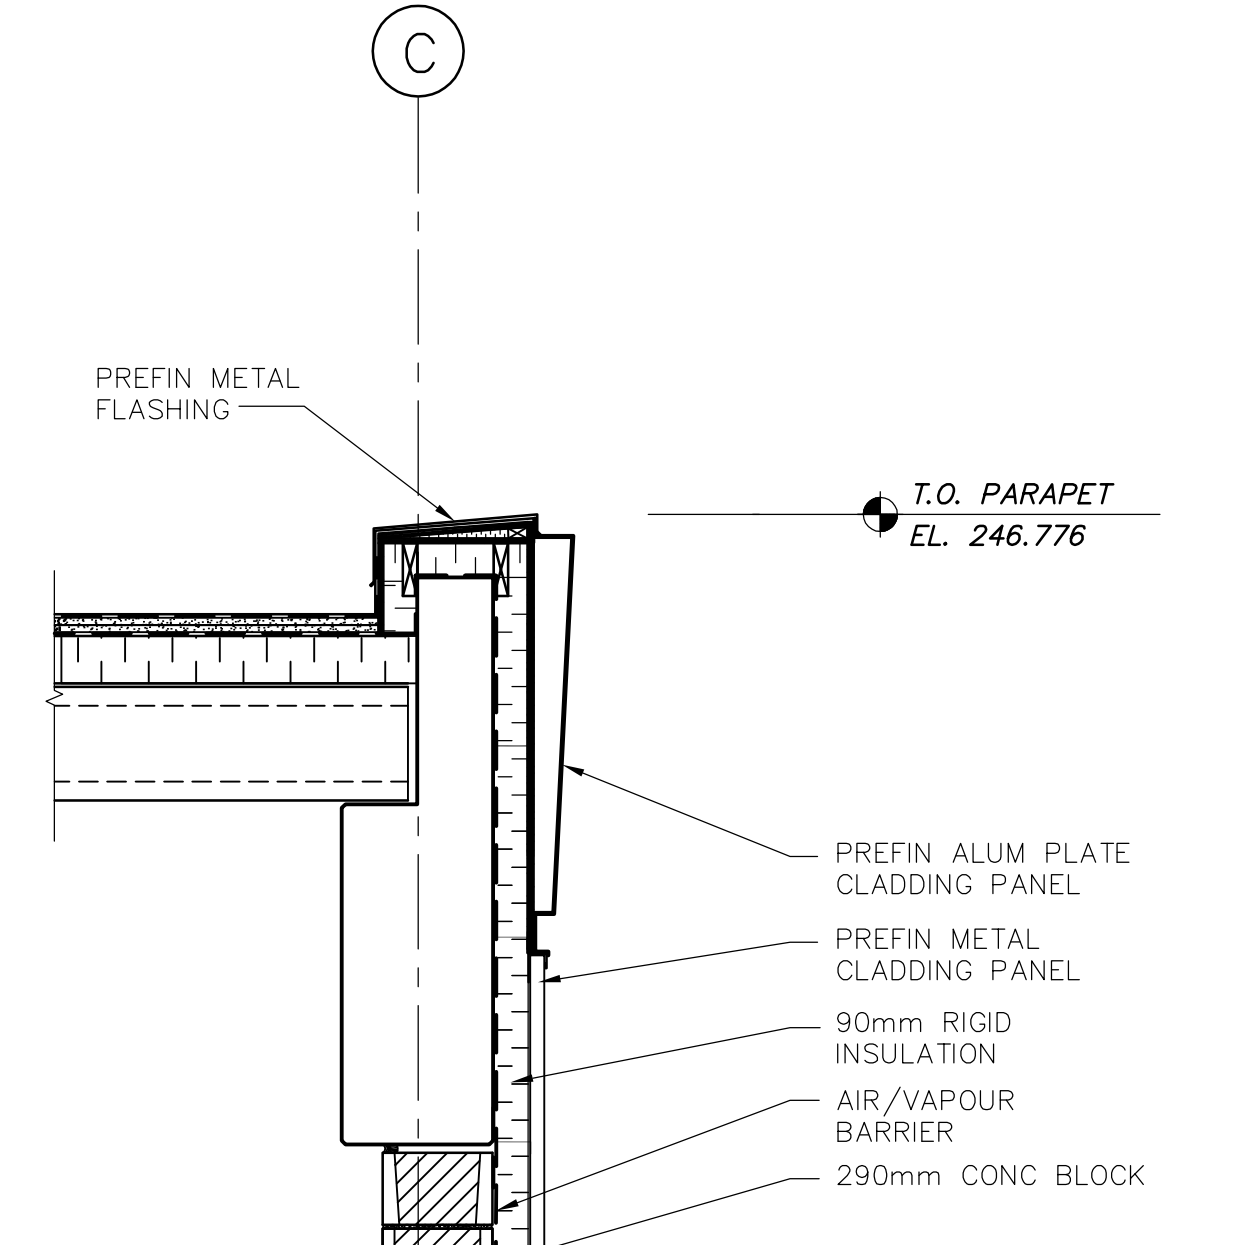


7 WALL SECTION DETAIL
WG-B0203 1:20

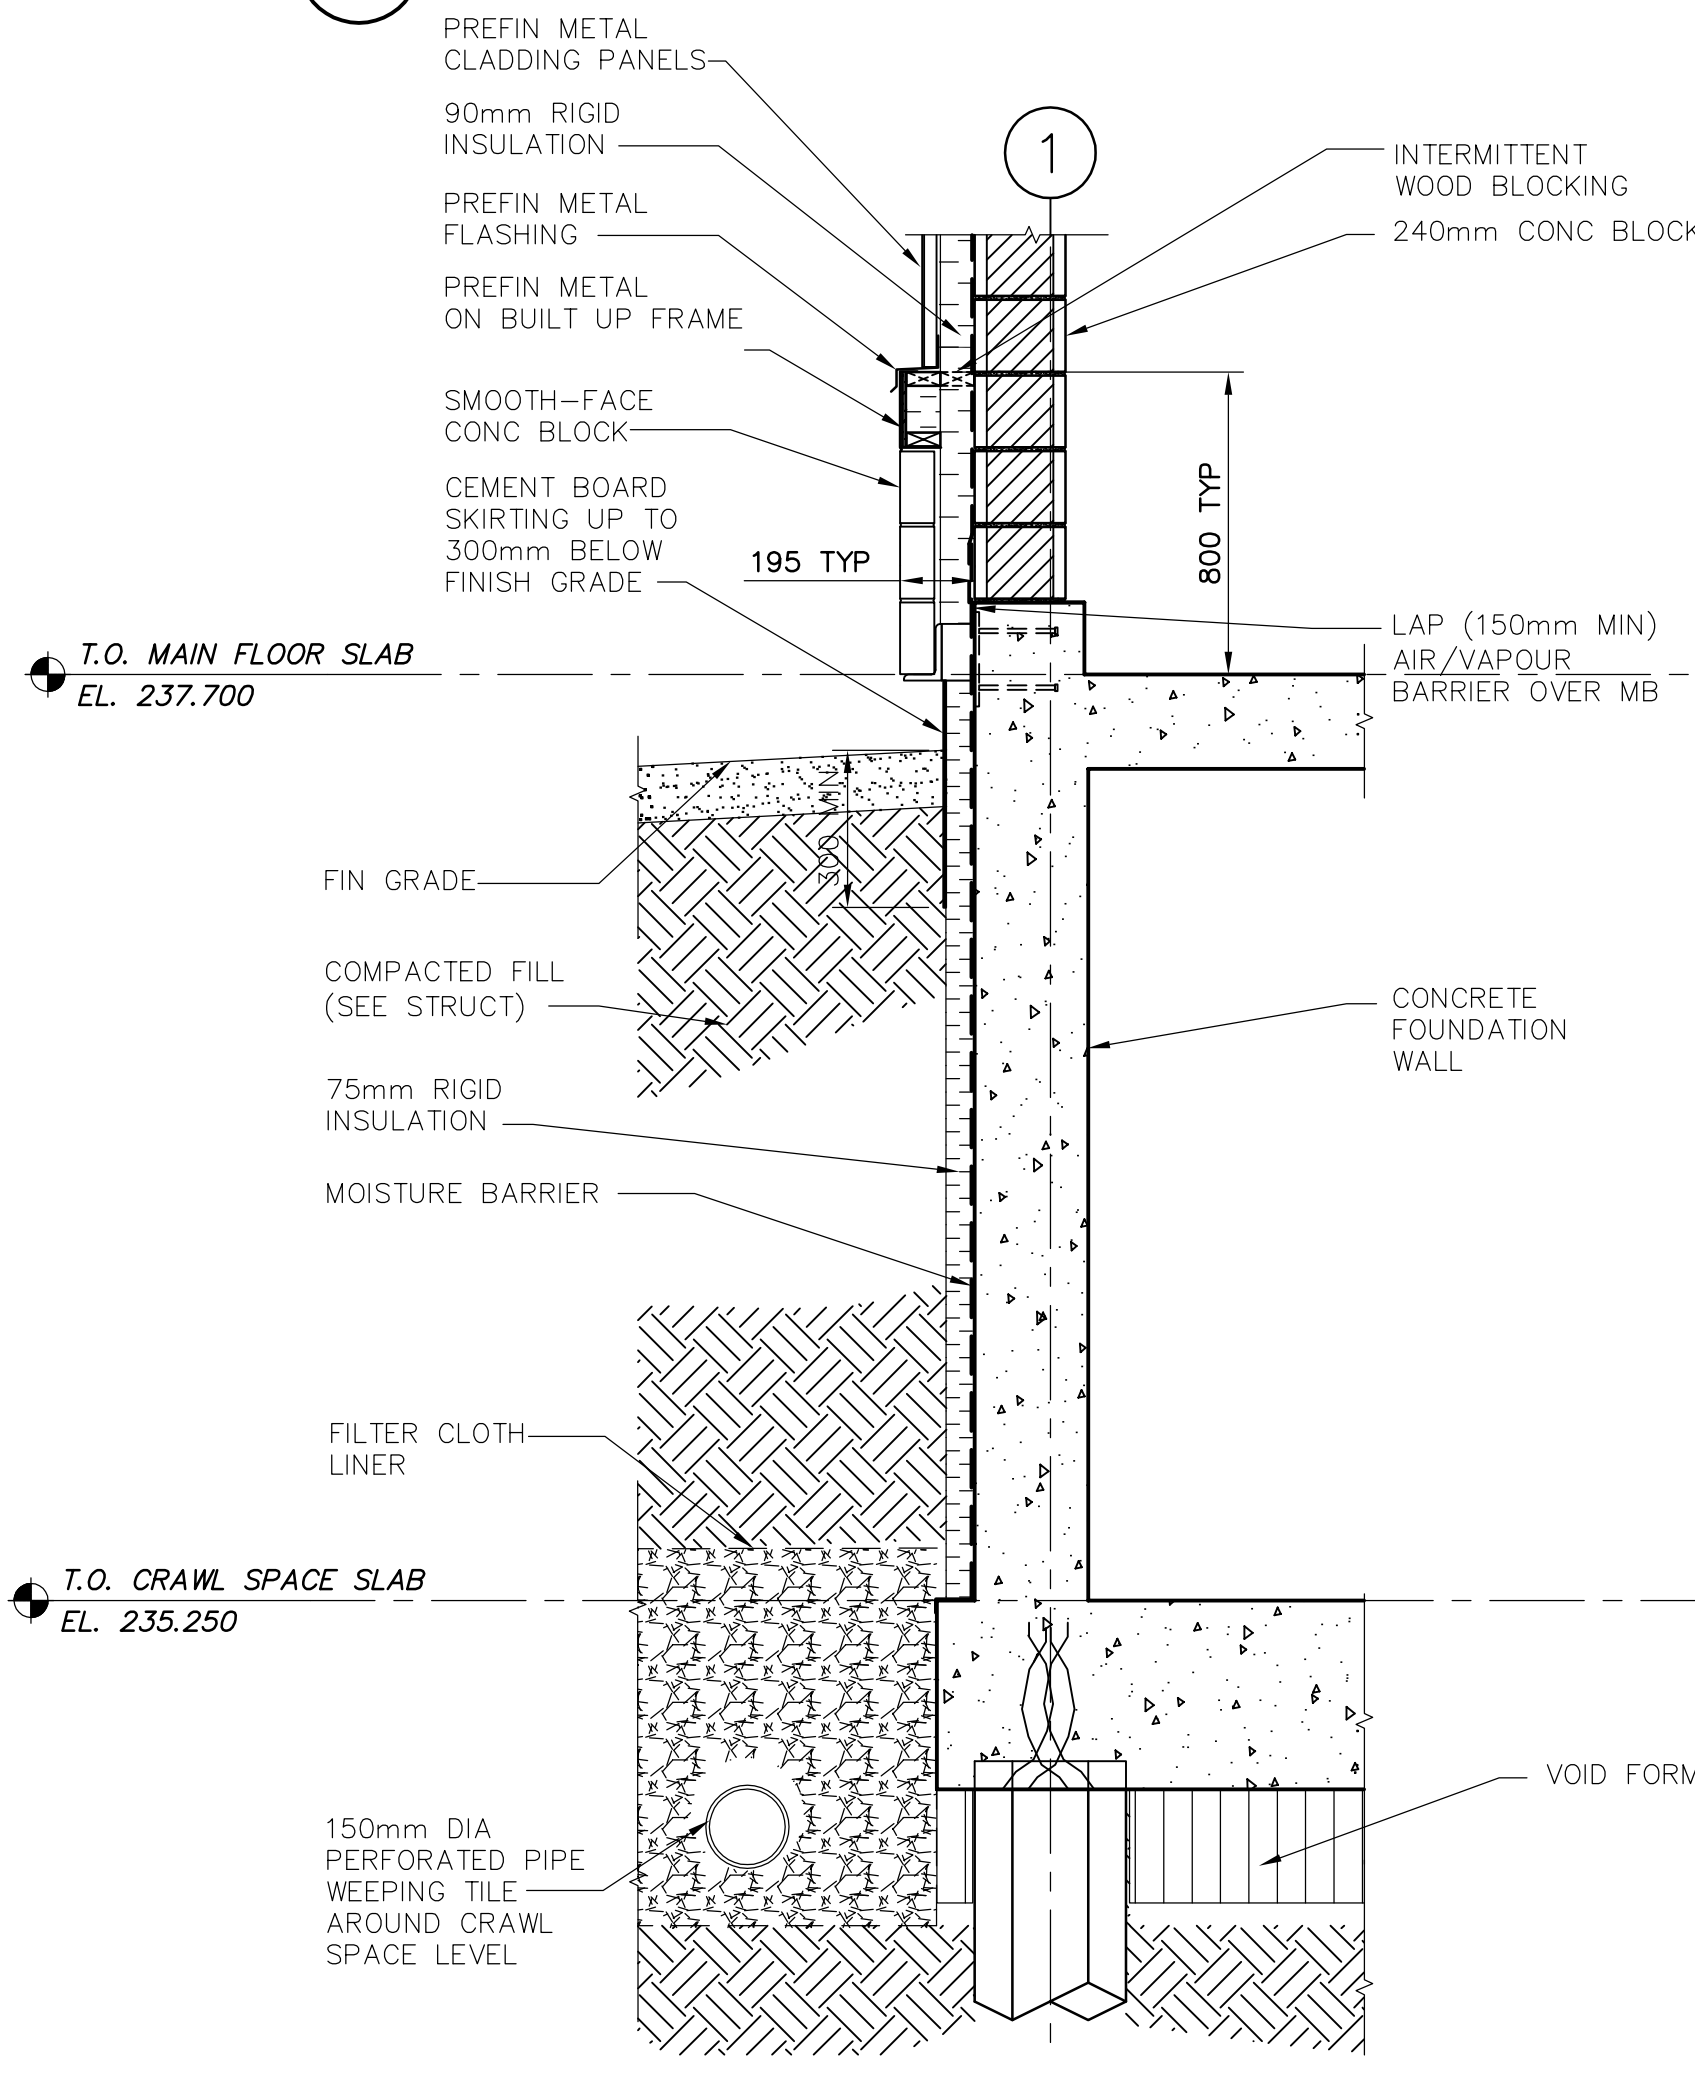

1 FOUNDATION WALL SECTION DETAIL
WG-B0202 1:20

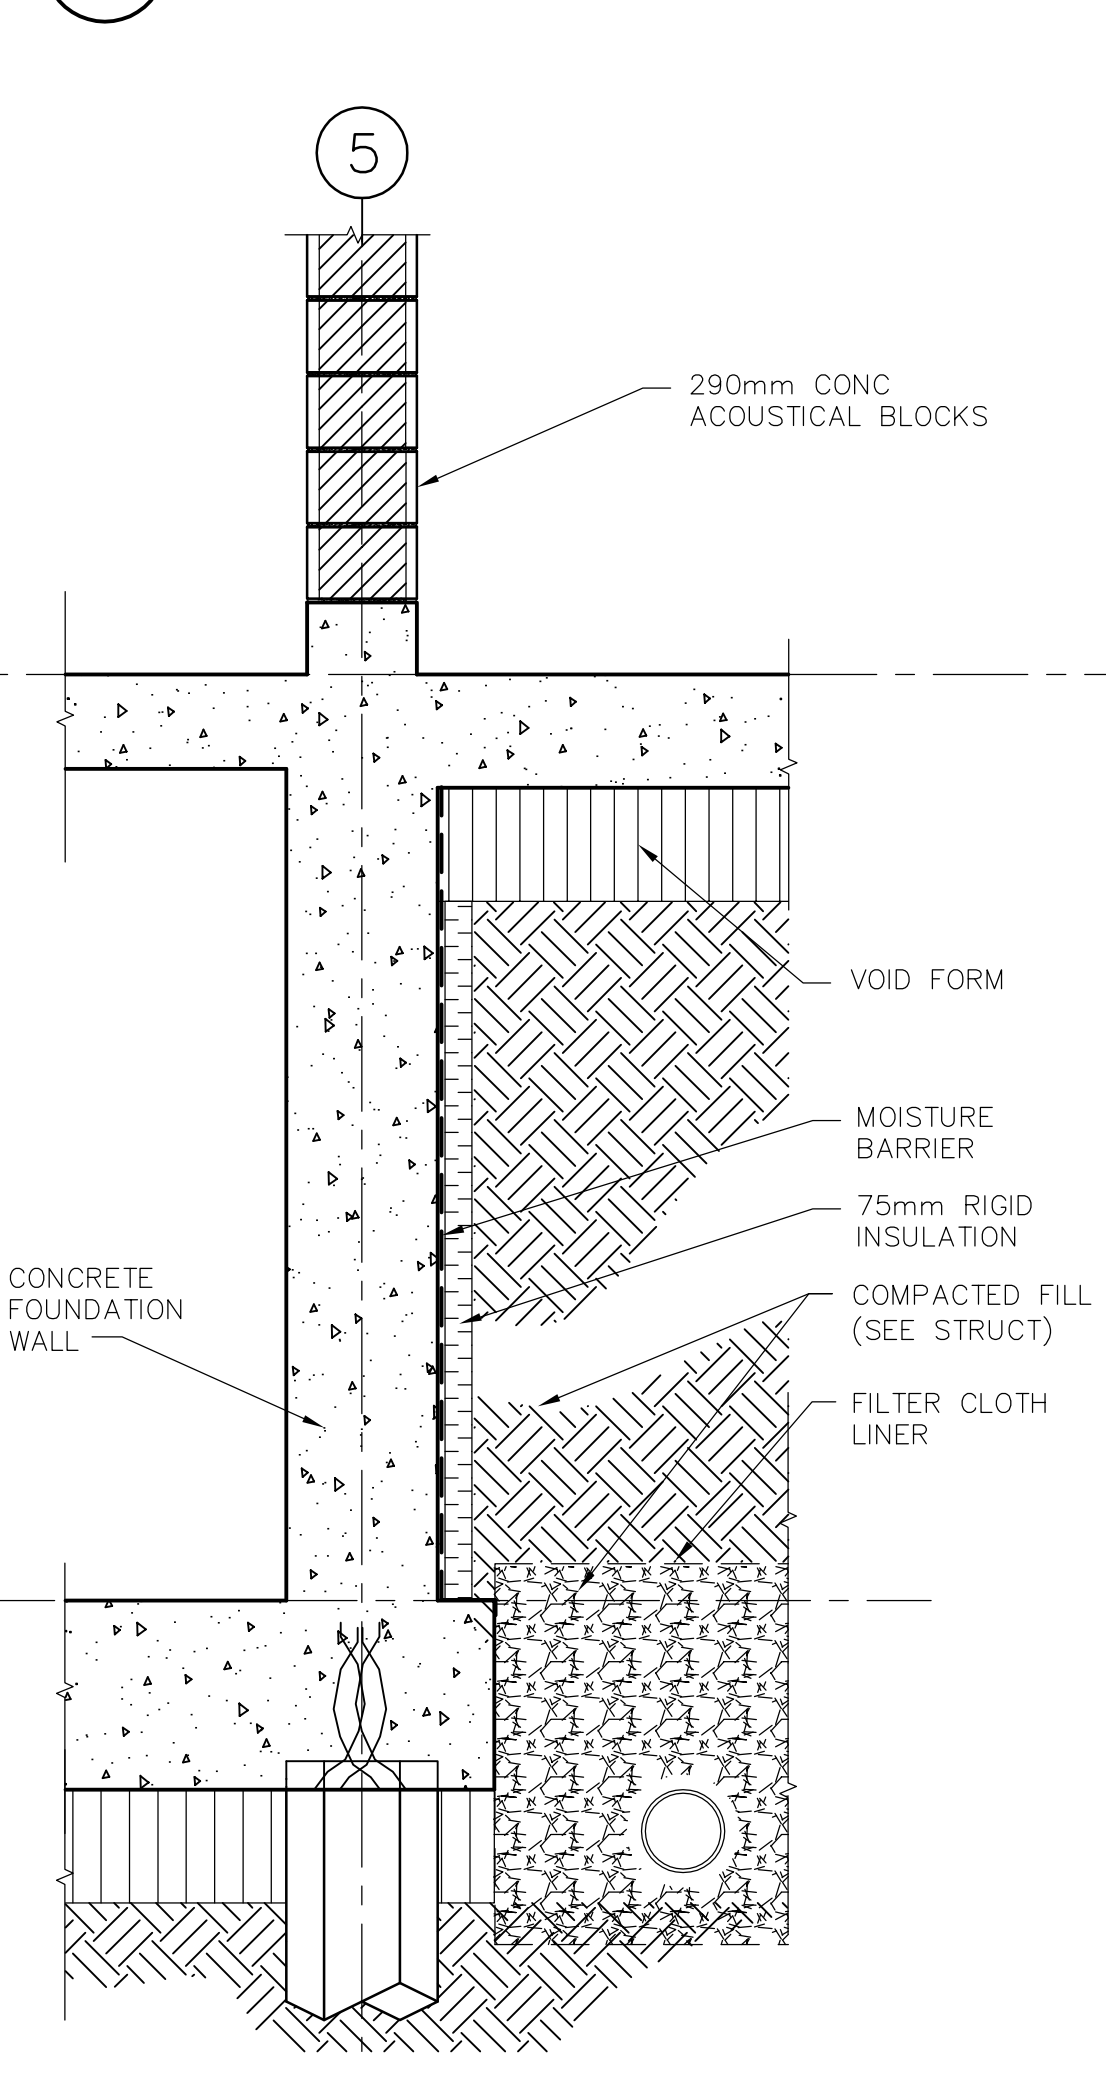

2 FOUNDATION WALL SECTION DETAIL
WG-B0202 1:20

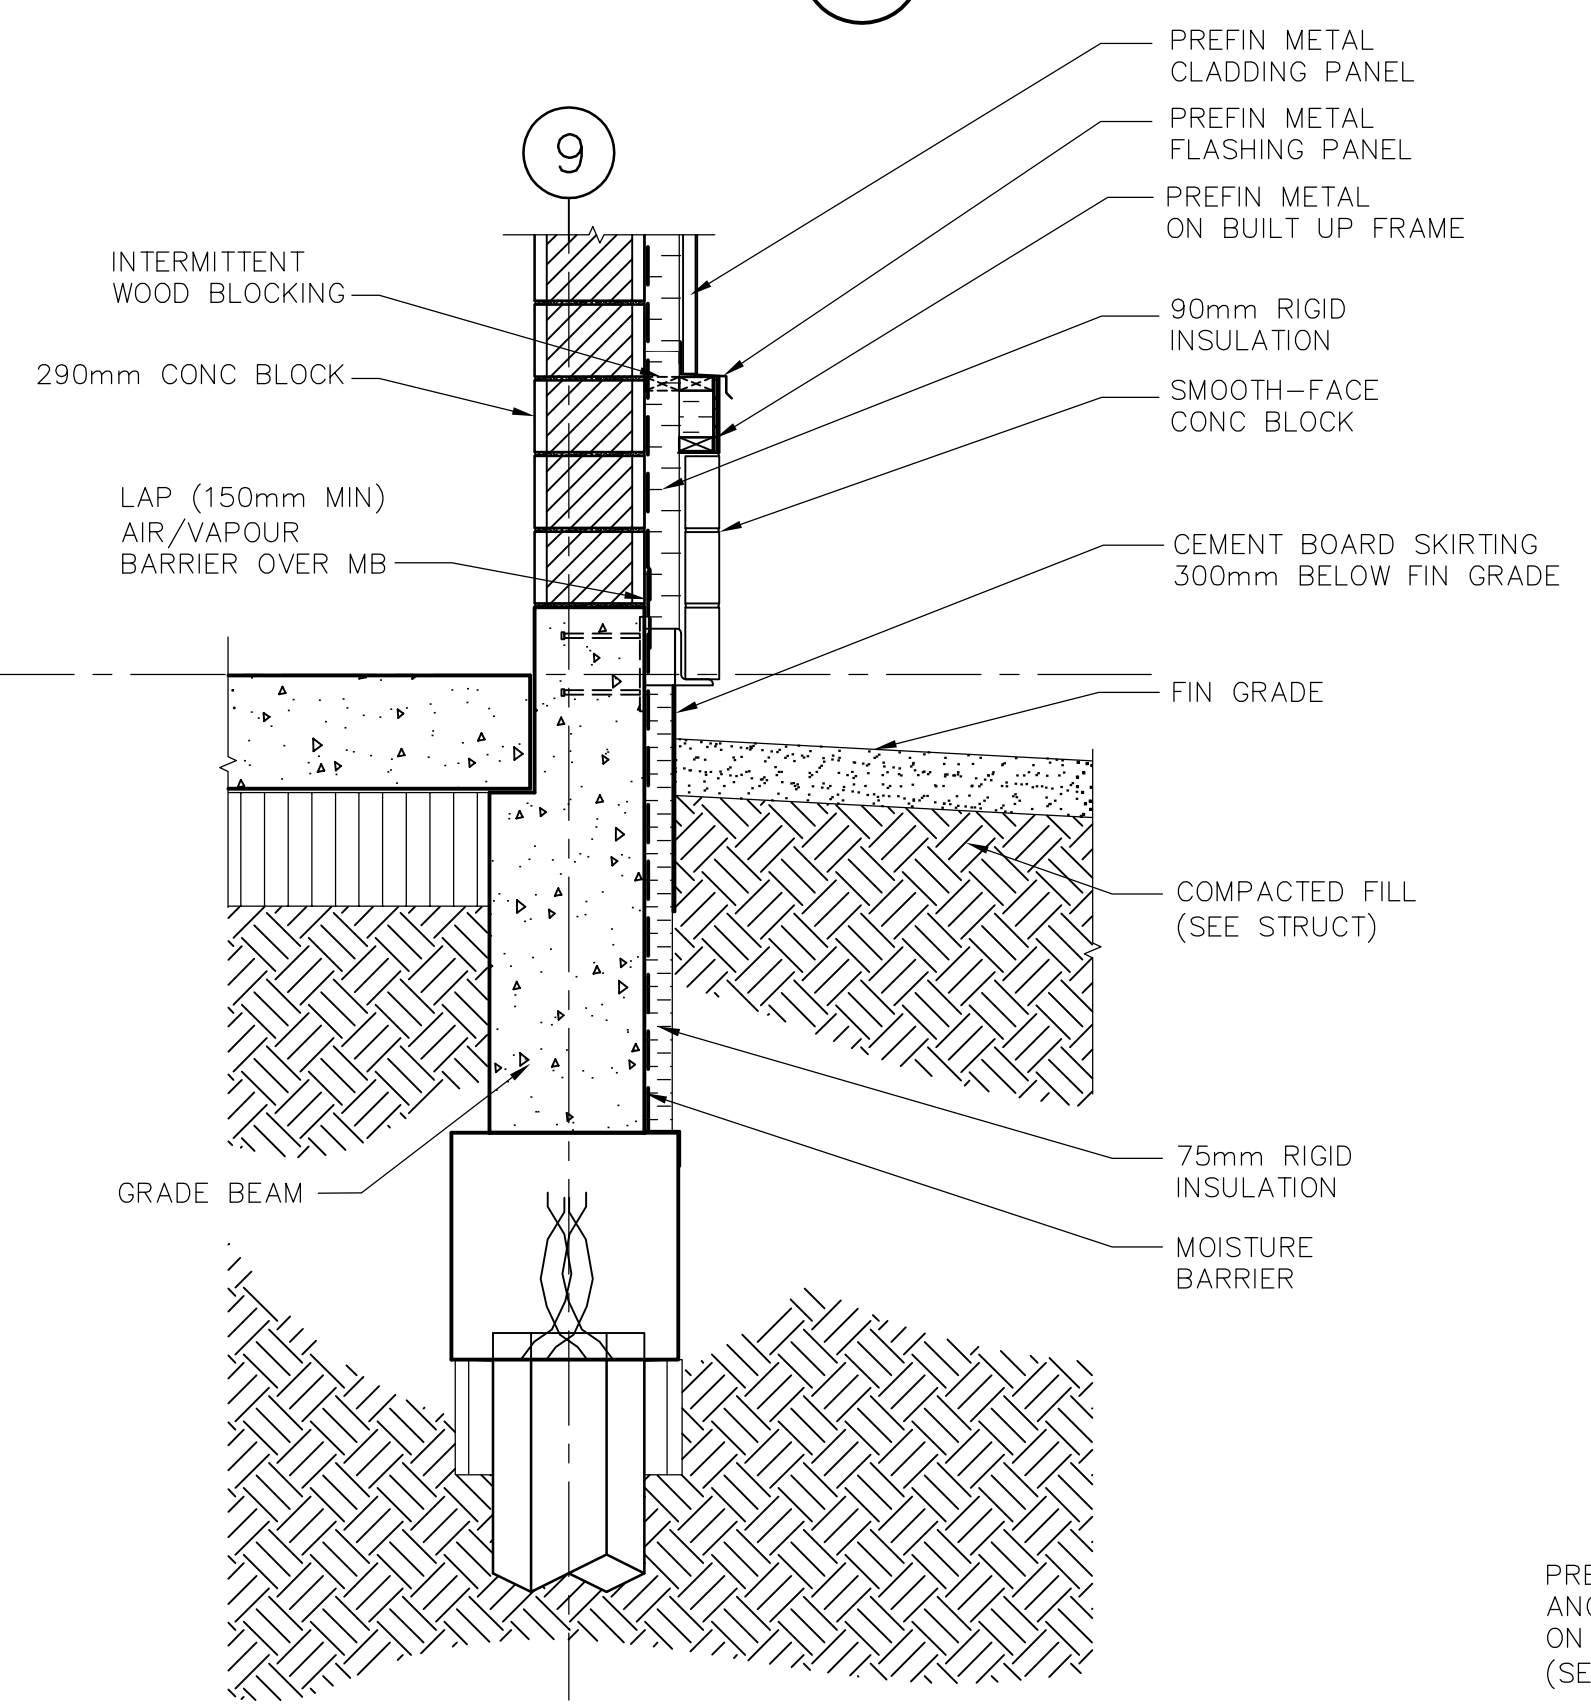

3 FOUNDATION WALL SECTION DETAIL
WG-B0202 1:20

<p>B.M. ELEV.</p>		<p>CH2MHILL Frederickson Cooper ARCHITECTS</p>		<p>ENGINEER'S SEAL</p>		<p>THE CITY OF WINNIPEG WATER AND WASTE DEPARTMENT ENGINEERING DIVISION</p>	
<p>DESIGNED BY: NC</p>		<p>CHECKED BY: LK</p>		<p>ORIGINAL SIGNED BY: N. COOPER</p>		<p>CITY FILE NUMBER</p>	
<p>DRAWN BY: AL</p>		<p>APPROVED BY: AHL</p>		<p>2006/08/30</p>		<p>SHEET OF</p>	
<p>SCALE: AS SHOWN</p>		<p>RELEASED FOR CONSTRUCTION BY: R. SOROKOWSKI</p>		<p>CONSULTANT DRAWING NO. WG-B0401</p>		<p>CITY DRAWING NUMBER 1-0601G-A-B0401-001-000</p>	
<p>00 ISSUED FOR TENDER 06/08/28 AL</p>		<p>2006/06/01</p>		<p>2006/08/30</p>		<p>ARCHITECTURAL WALL SECTION AND DETAILS</p>	