


MAIN FLOOR PLAN

1:100

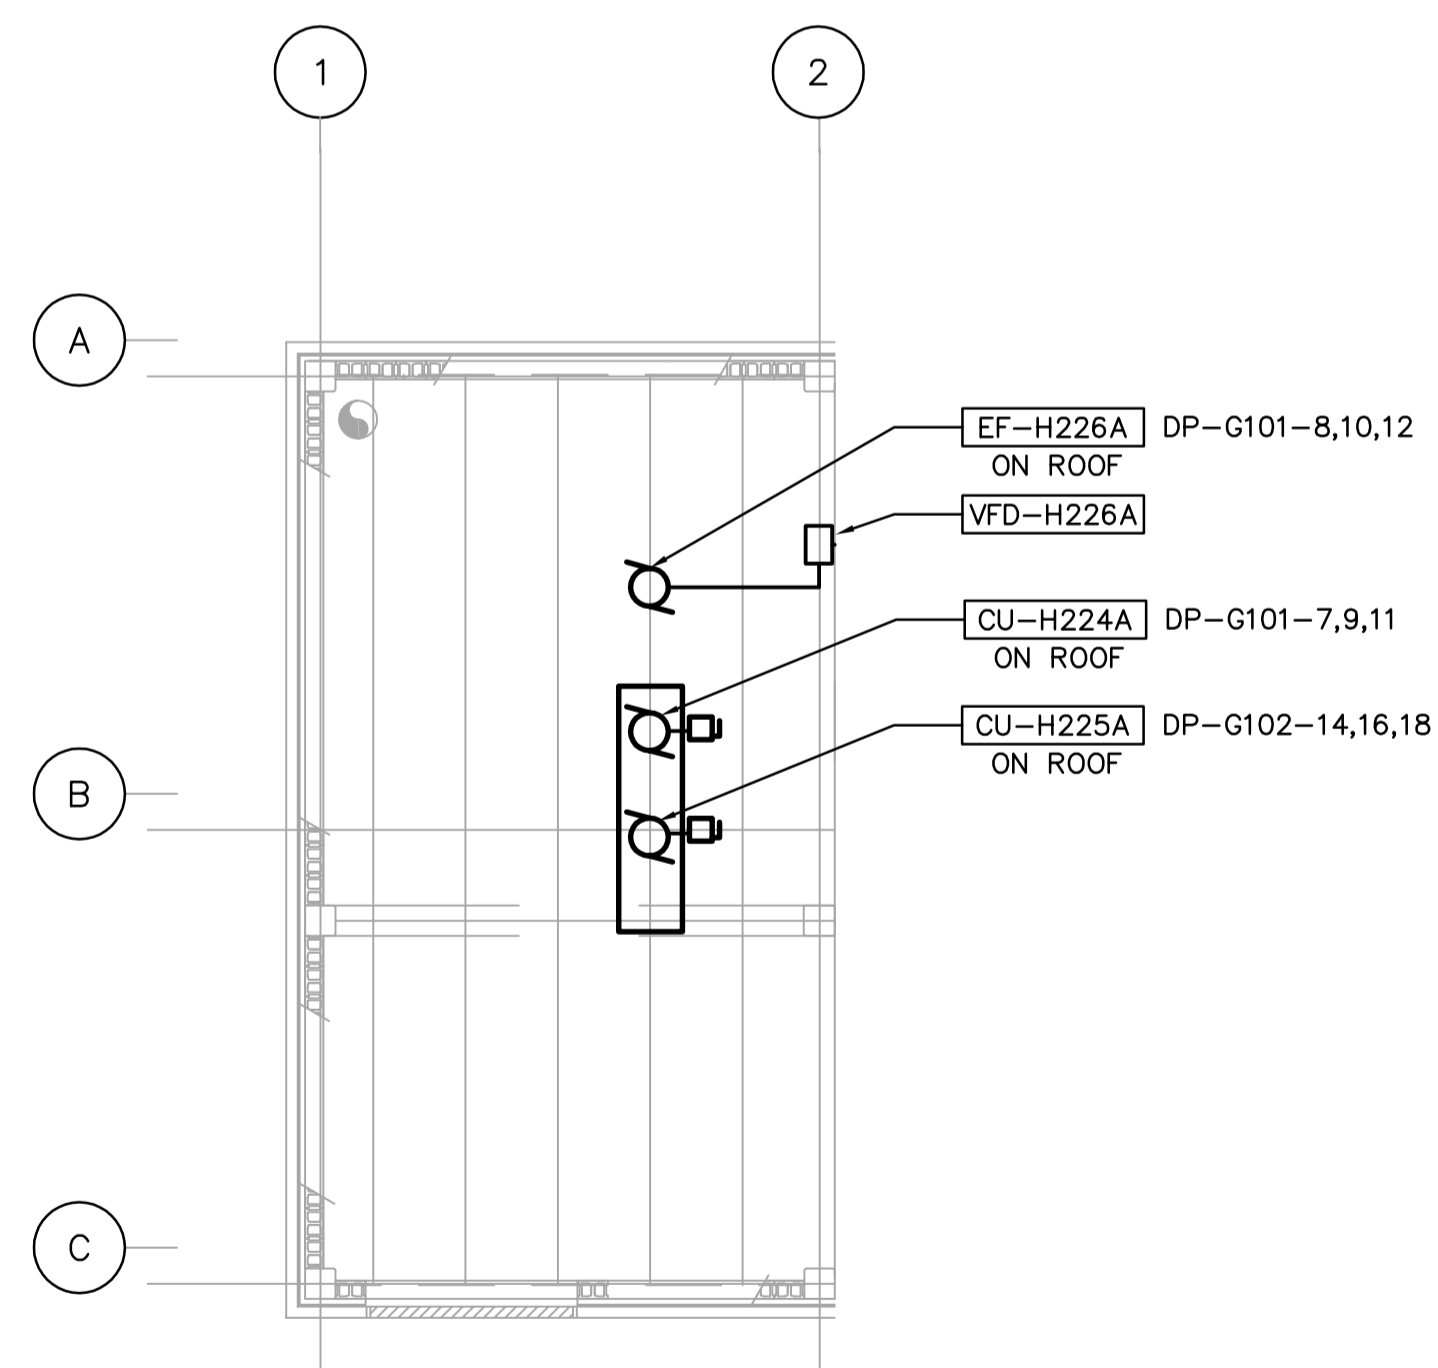

ROOF POWER PLAN

1:100

<p>Certificate of Authorization Earth Tech Canada Inc. No. 730 Expiry: April 30, 2007</p>	B.M. ELEV.	<p>Frederickson Cooper ARCHITECTS</p>	<p>A Type International Ltd. Company</p>	ENGINEER'S SEAL	<p>THE CITY OF WINNIPEG WATER AND WASTE DEPARTMENT ENGINEERING DIVISION</p>		
				DESIGNED BY: BLM		CHECKED BY: PS	ORIGINAL SIGNED BY: B.L. MOORE
				DRAWN BY: ERC		APPROVED BY: AHL	2006/08/30
				SCALE: NTS		RELEASED FOR CONSTRUCTION BY: R. SOROKOWSKI	CONSULTANT DRAWING NO. WG-E0112
	00 ISSUED FOR TENDER 06/08/30 ERC	DATE 2005/10/03	DATE 2006/08/30		<p>WATER TREATMENT PLANT STANDBY POWER GENERATOR GENERATOR BUILDING</p> <p>ELECTRICAL MAIN FLOOR POWER PLAN</p>	<p>CITY FILE NUMBER</p> <p>SHEET OF</p> <p>CITY DRAWING NUMBER 1-0601G-A-E0112-001-000</p>	