




1 CRAWLSPACE PLUMBING PLAN  
WG-H0100 1:100

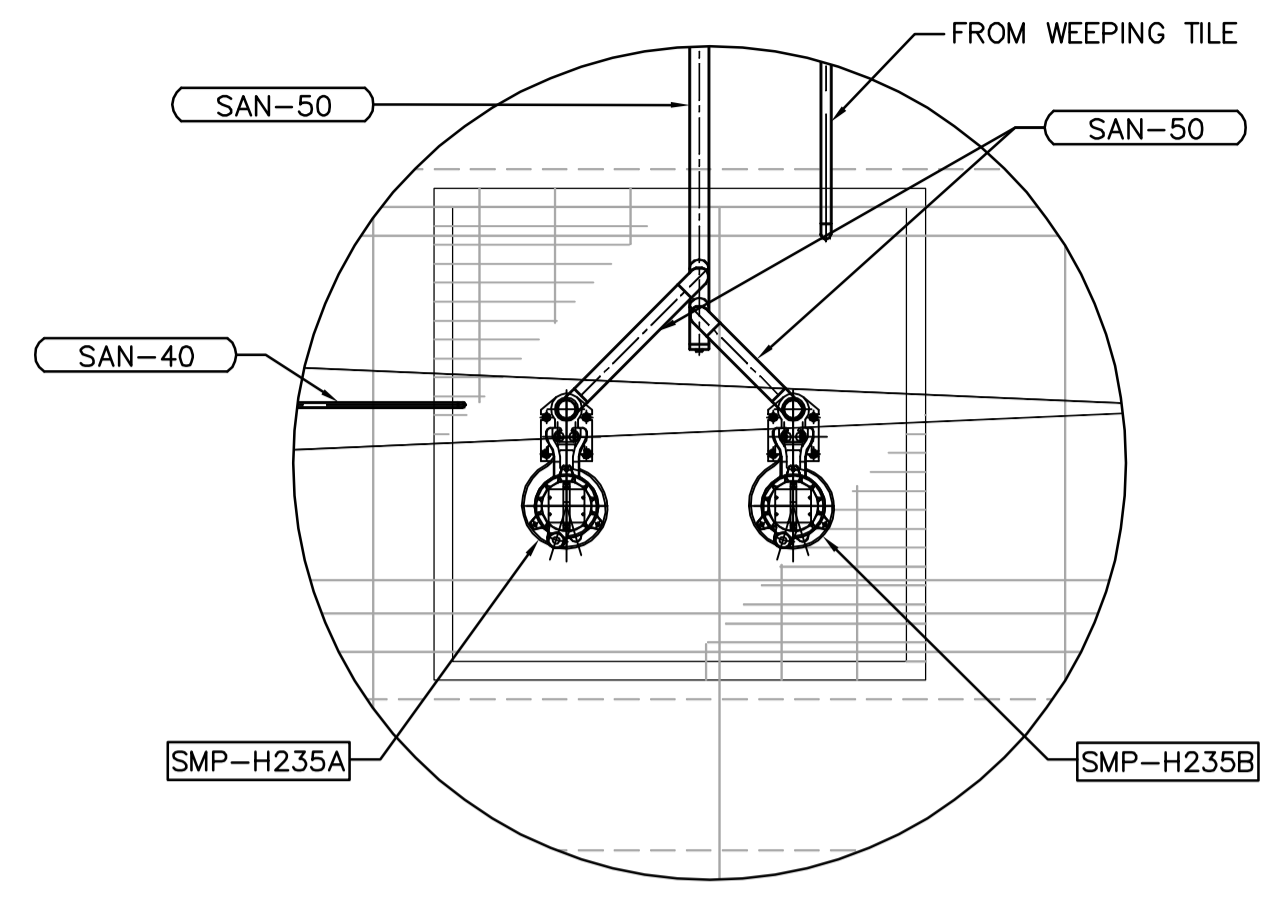

A SUMP PUMP PARTIAL PLAN  
1:20

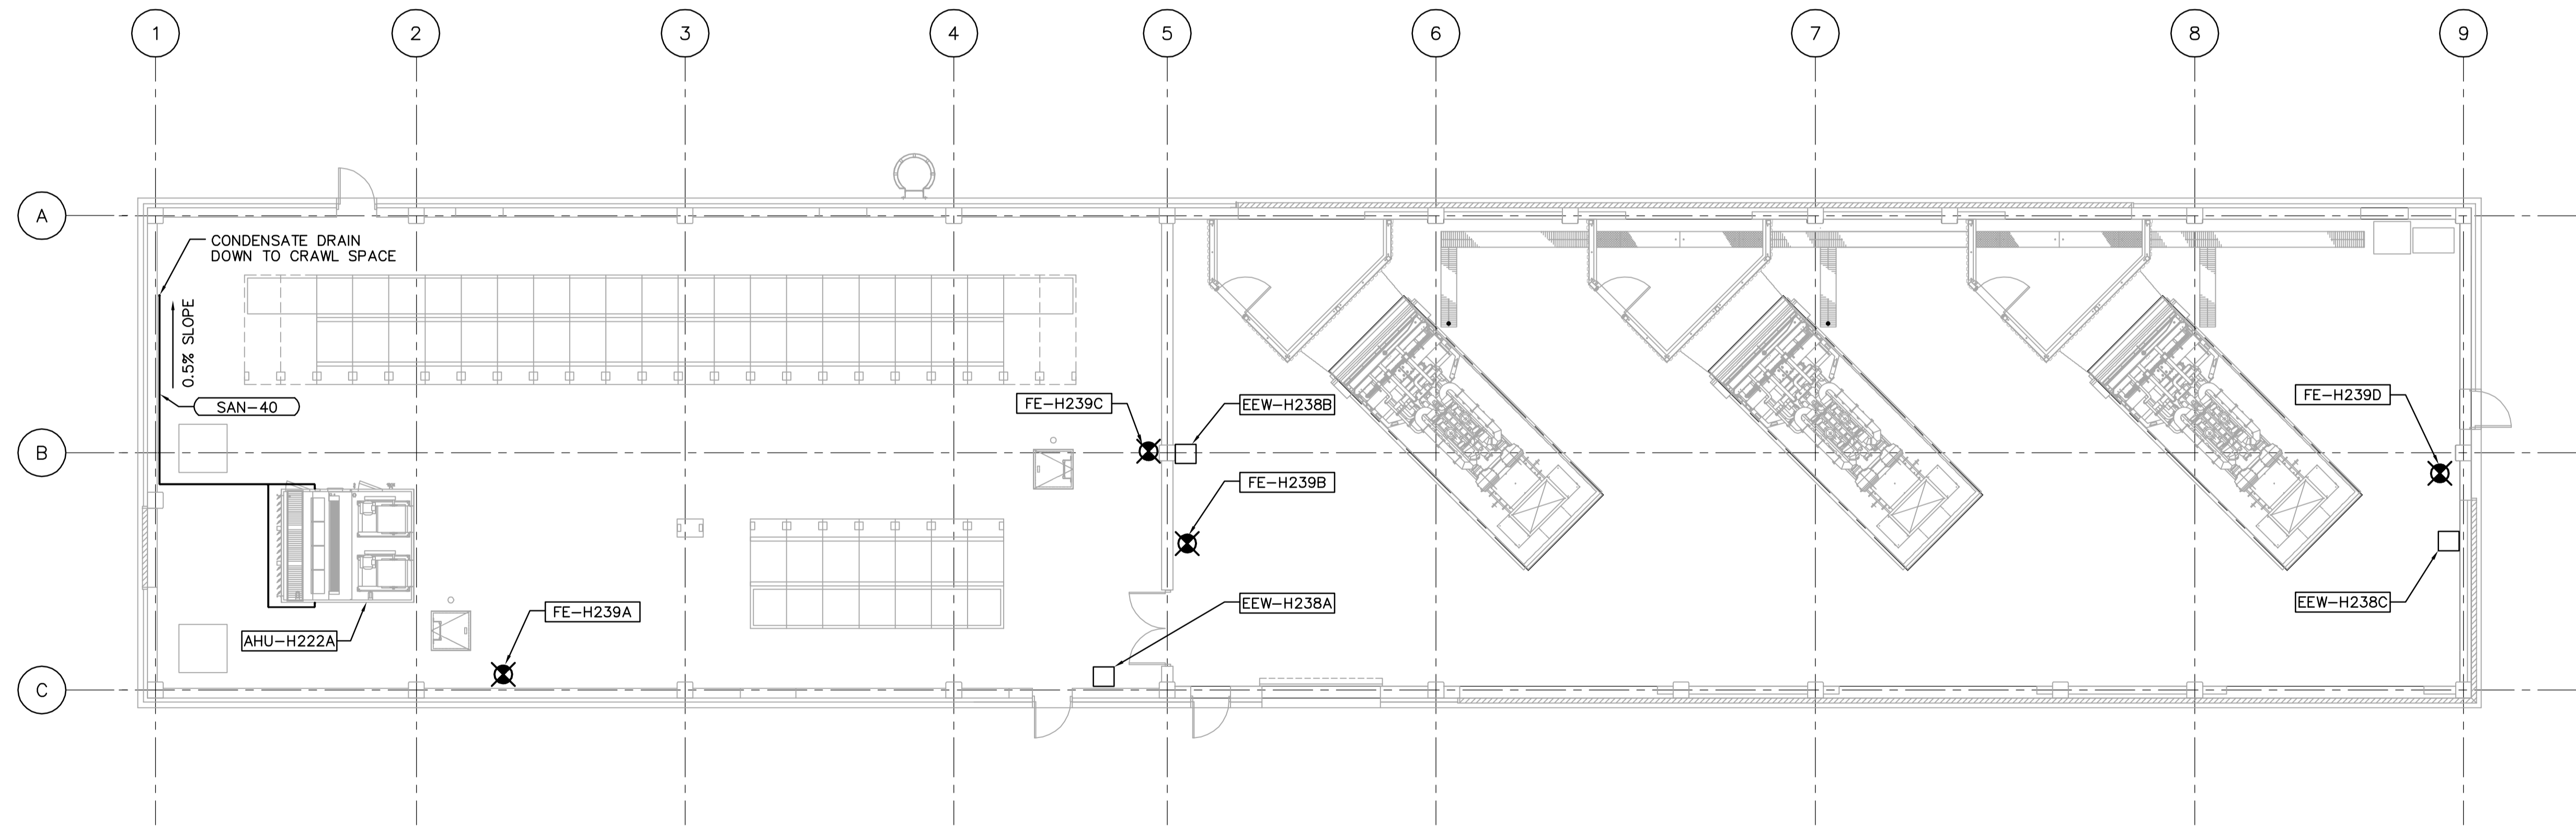

2 MAIN FLOOR FIRE PROTECTION PLAN  
1:100

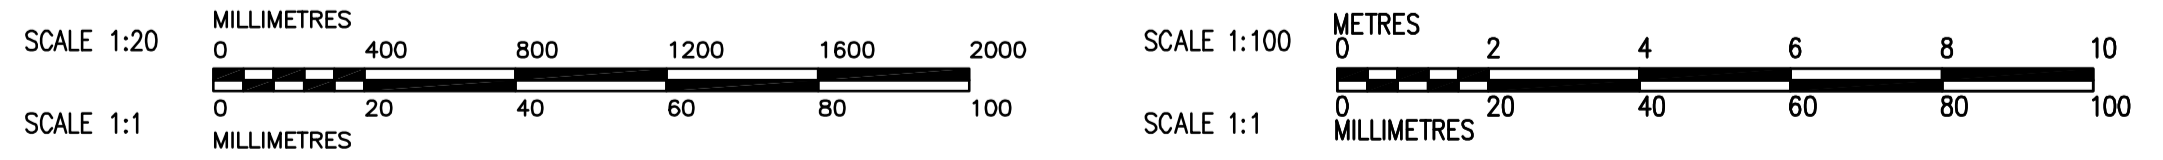

B.M. ELEV.					
00	ISSUED FOR TENDER	06/08/28	LJW		
NO.	REVISIONS	DATE	BY	DATE	2006/05/15

DESIGNED BY	AB	CHECKED BY	AMA, PVL
DRAWN BY	DJP	APPROVED BY	AHL
SCALE:	AS NOTED	RELEASED FOR CONSTRUCTION BY:	R. SOROKOWSKI
		DATE	2006/08/30

**CH2M HILL**  
Frederickson Cooper ARCHITECTS

**EarthTech**  
A Tech International Ltd. Company

ENGINEER'S SEAL  
ORIGINAL SIGNED BY  
A. BURACHYNSKY  
2006/08/30

CONSULTANT DRAWING NO.  
WG-H0100

**THE CITY OF WINNIPEG**  
WATER AND WASTE DEPARTMENT  
ENGINEERING DIVISION

WATER TREATMENT PLANT  
STANDBY POWER GENERATOR

CITY FILE NUMBER  
SHEET OF

MECHANICAL  
PLUMBING PLAN  
CRAWLSPACE PLAN AND MAIN LEVEL PLAN

CITY DRAWING NUMBER  
1-0601G-A-H0100-001-000