



1 WALL SECTION DETAIL AT AIR SHAFT LOUVER  
WT-B0006 1:25

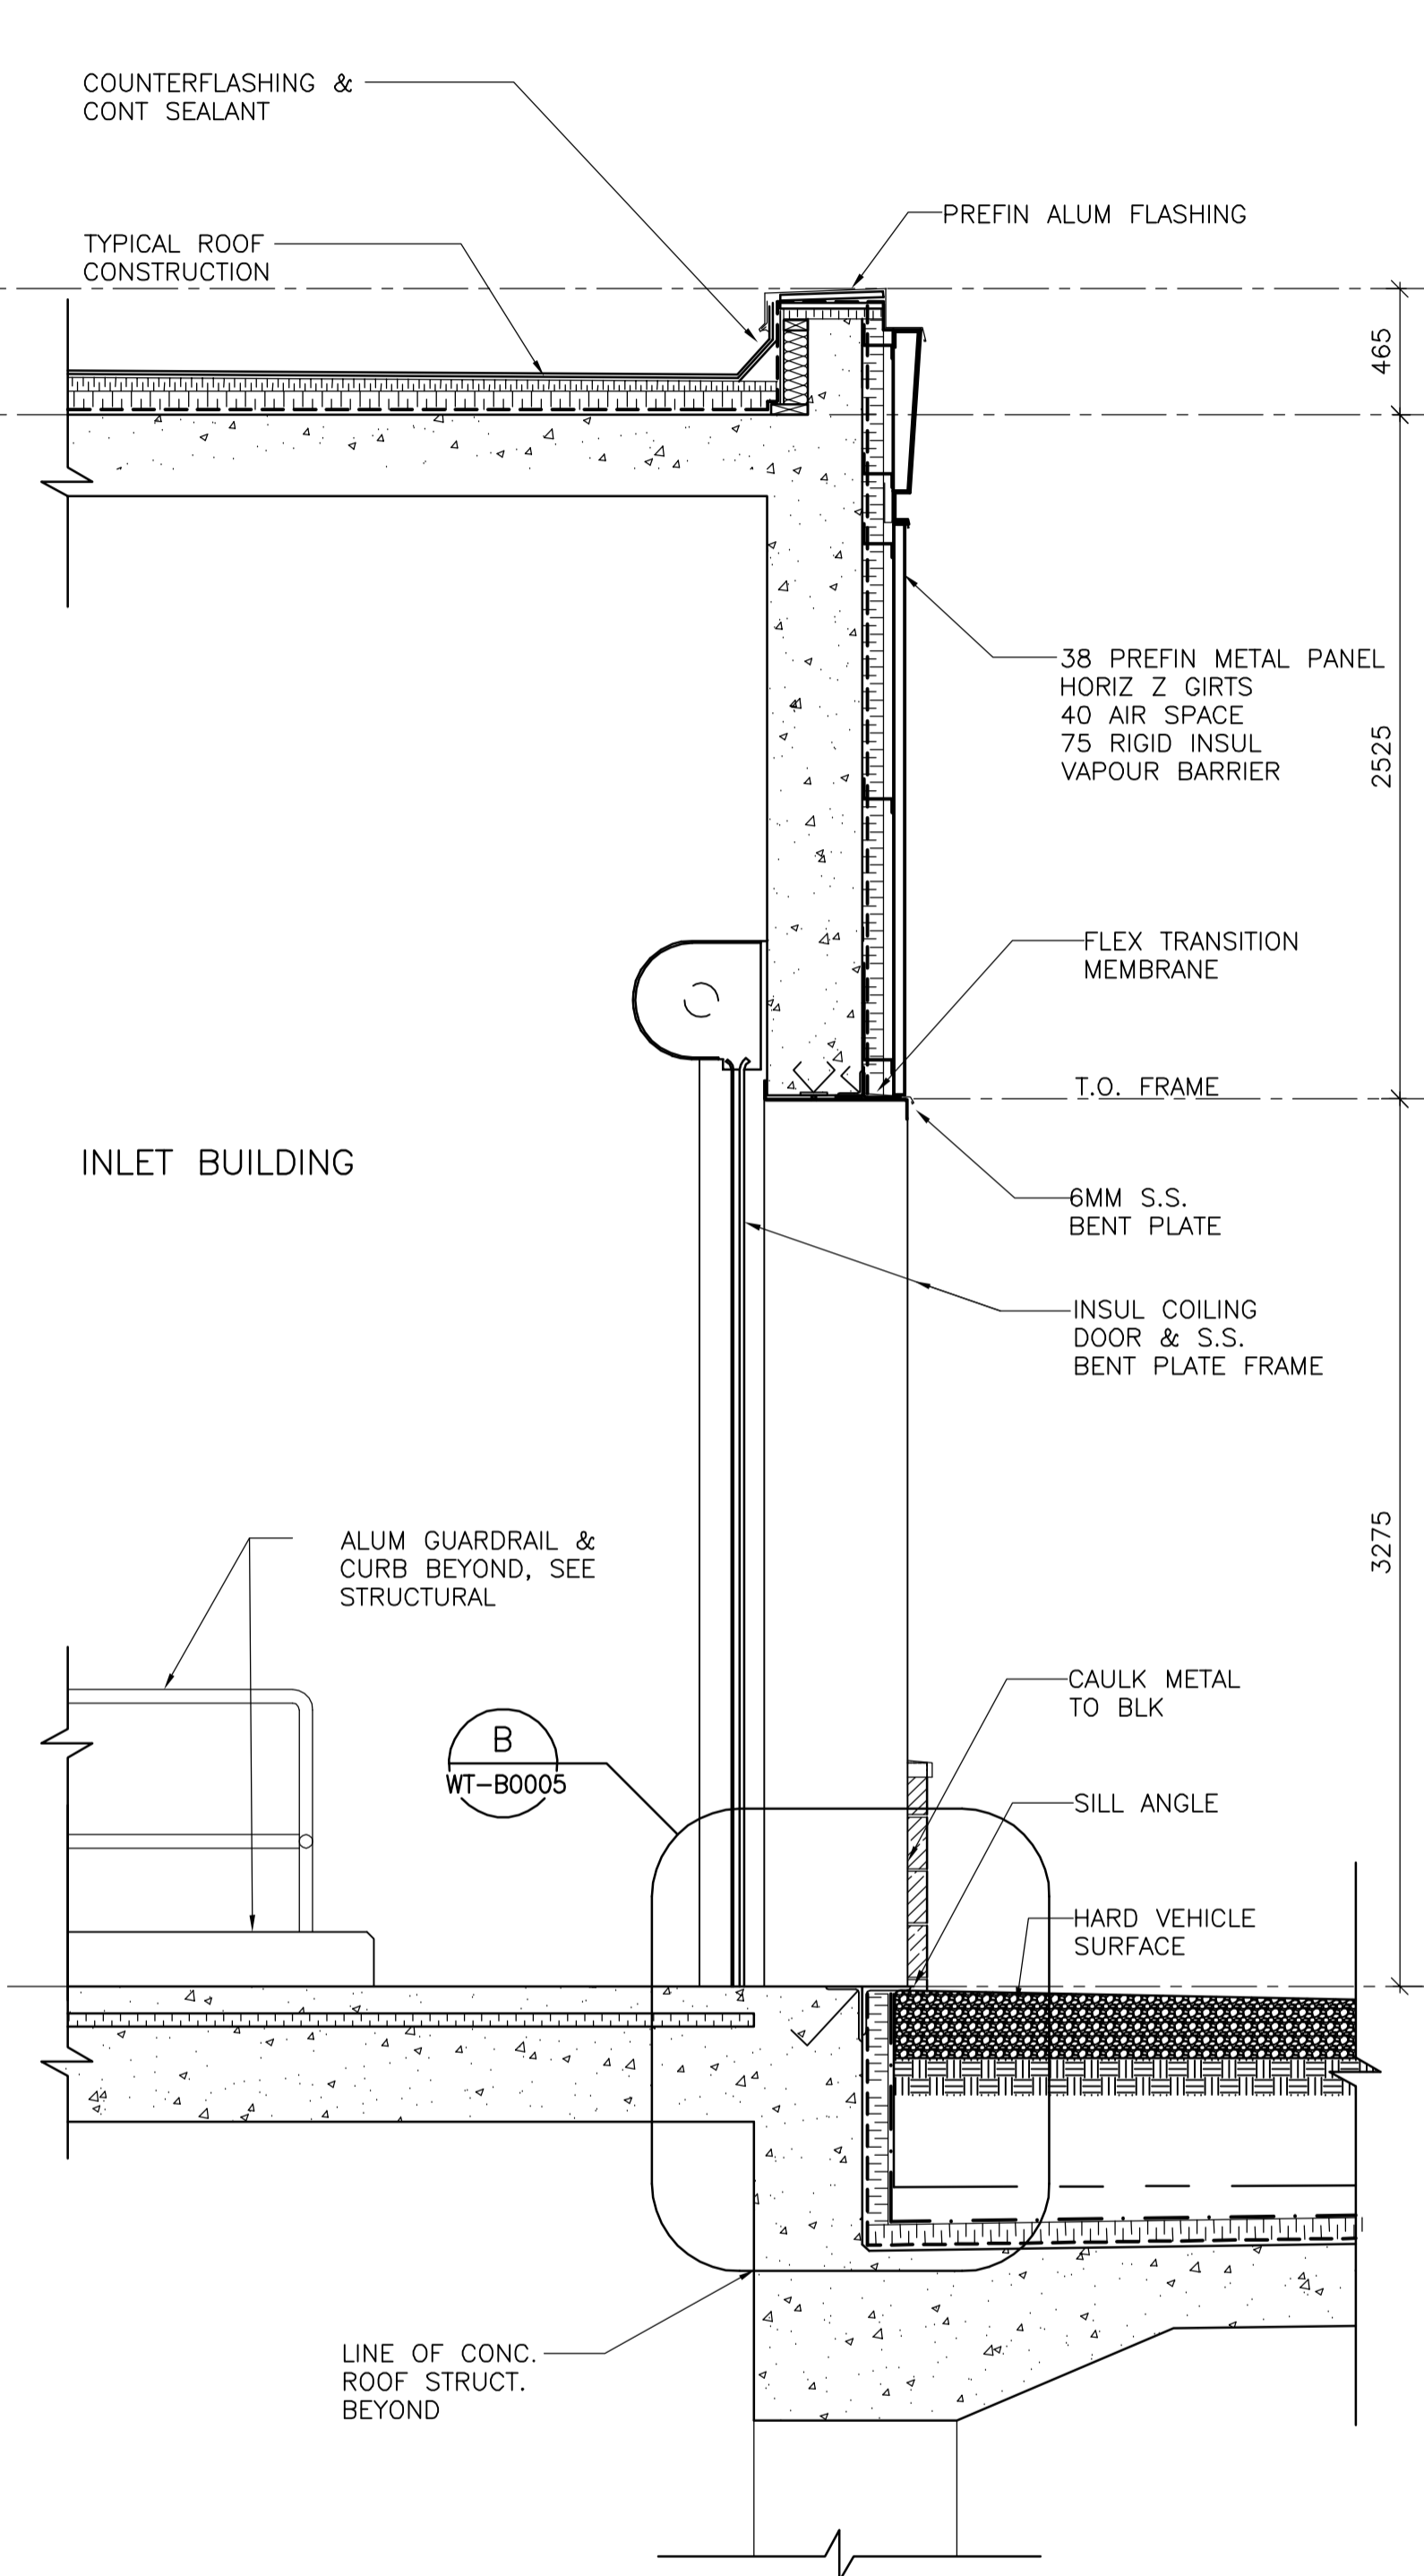

2 WALL SECTION DETAIL AT VERTICAL COILING DOOR  
WT-B0006 1:25

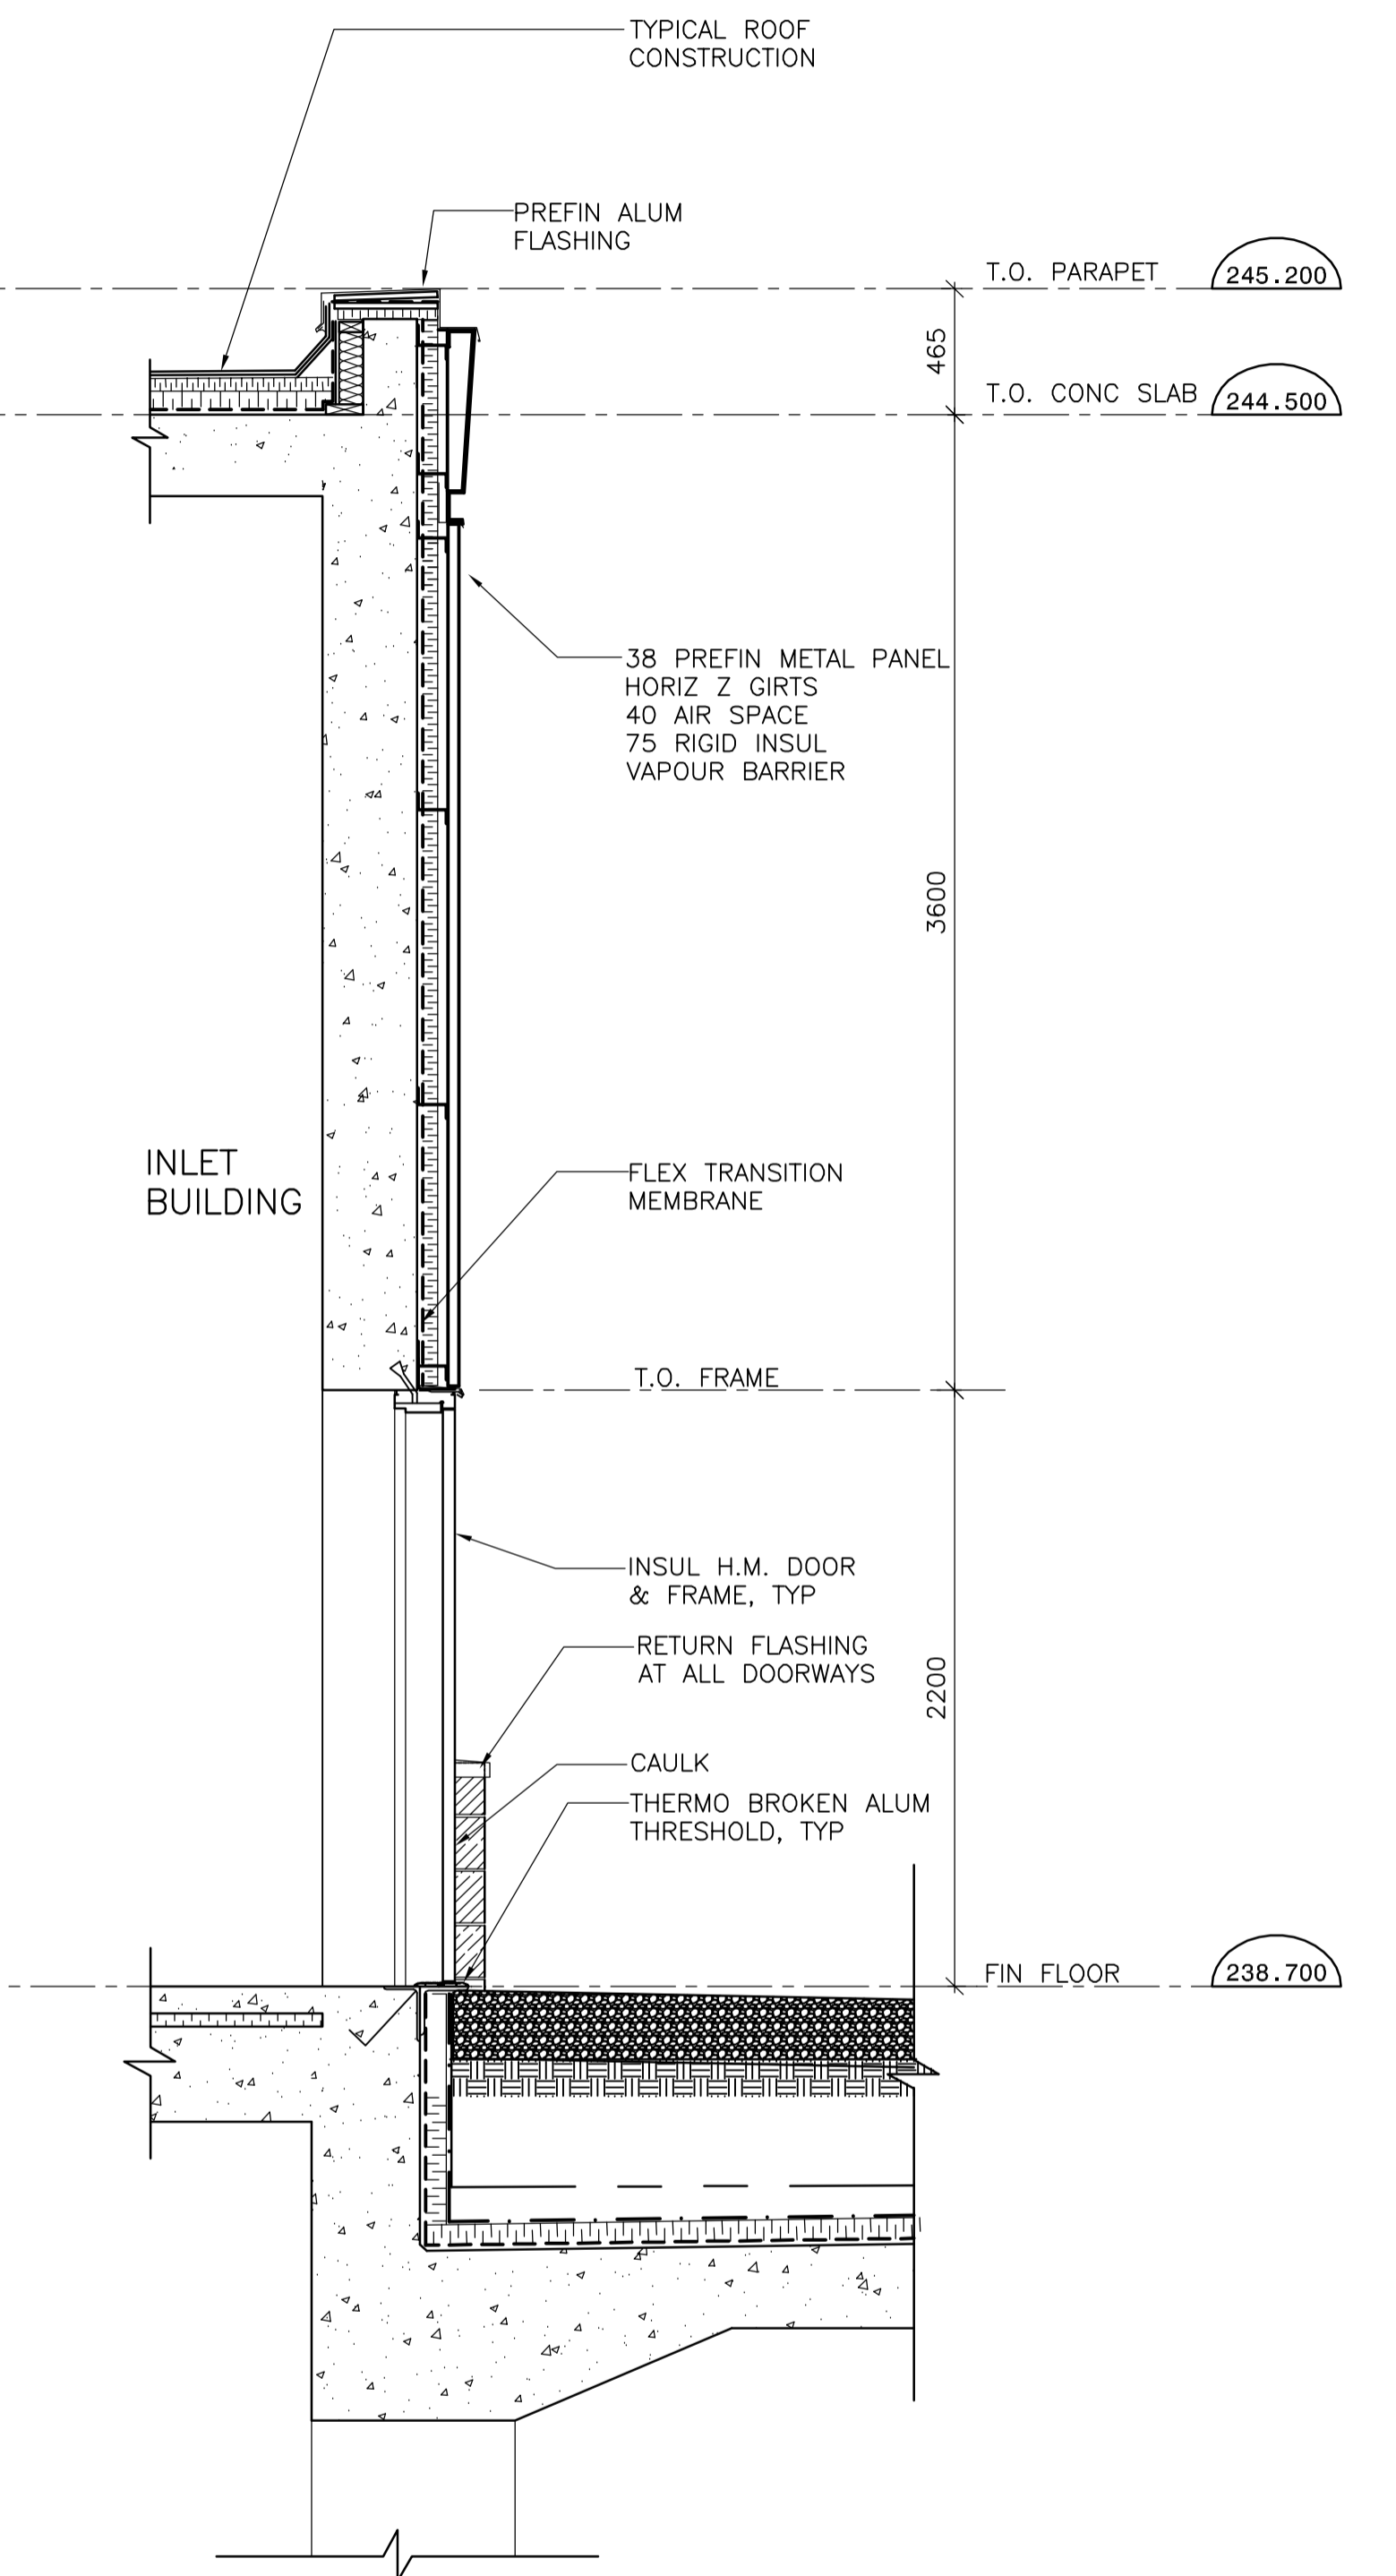

3 WALL SECTION DETAIL AT DOOR  
WT-B0002 1:25

B.M. ELEV.	 		ENGINEER'S SEAL		 <b>THE CITY OF WINNIPEG</b> WATER AND WASTE DEPARTMENT ENGINEERING DIVISION	CITY FILE NUMBER		
			Frederickson Cooper ARCHITECTS				ORIGINAL SIGNED BY	SHEET OF
	DESIGNED BY	BS	CHECKED BY	N. COOPER			WATER TREATMENT PLANT TREATED WATER STORAGE INLET BUILDING	
	DRAWN BY	GGP/WC	APPROVED BY	06/08/30				
SCALE:	AS NOTED	RELEASED FOR CONSTRUCTION BY:	CONSULTANT DRAWING NO.	CITY DRAWING NUMBER				
00 ISSUED FOR TENDER	06/08/28	WDB	WT-B0007		1-0601T-A-B0007-01-000			
NO. REVISIONS	DATE	BY	DATE					
	05/04/04		06/08/30					