



INLET BUILDING MAIN FLOOR LIGHTING PLAN
1:50

NOTES:

1. PROVIDE CONTACTOR FOR LIGHTING FIXTURE CIRCUITS T12-1, -3, -5 AND -7. CONTACTOR TO BE CSA-1 ENCLOSURE AND BE LOCATED ADJACENT TO PANEL 'A'. CONTACTOR TO BE CONTROLLED BY 3-WAY SWITCHES INDICATED AT DOORS TO INLET BUILDING.
2. EXTERIOR LIGHTING TO BE CONTROLLED BY PHOTOCELL CONTROLLER.

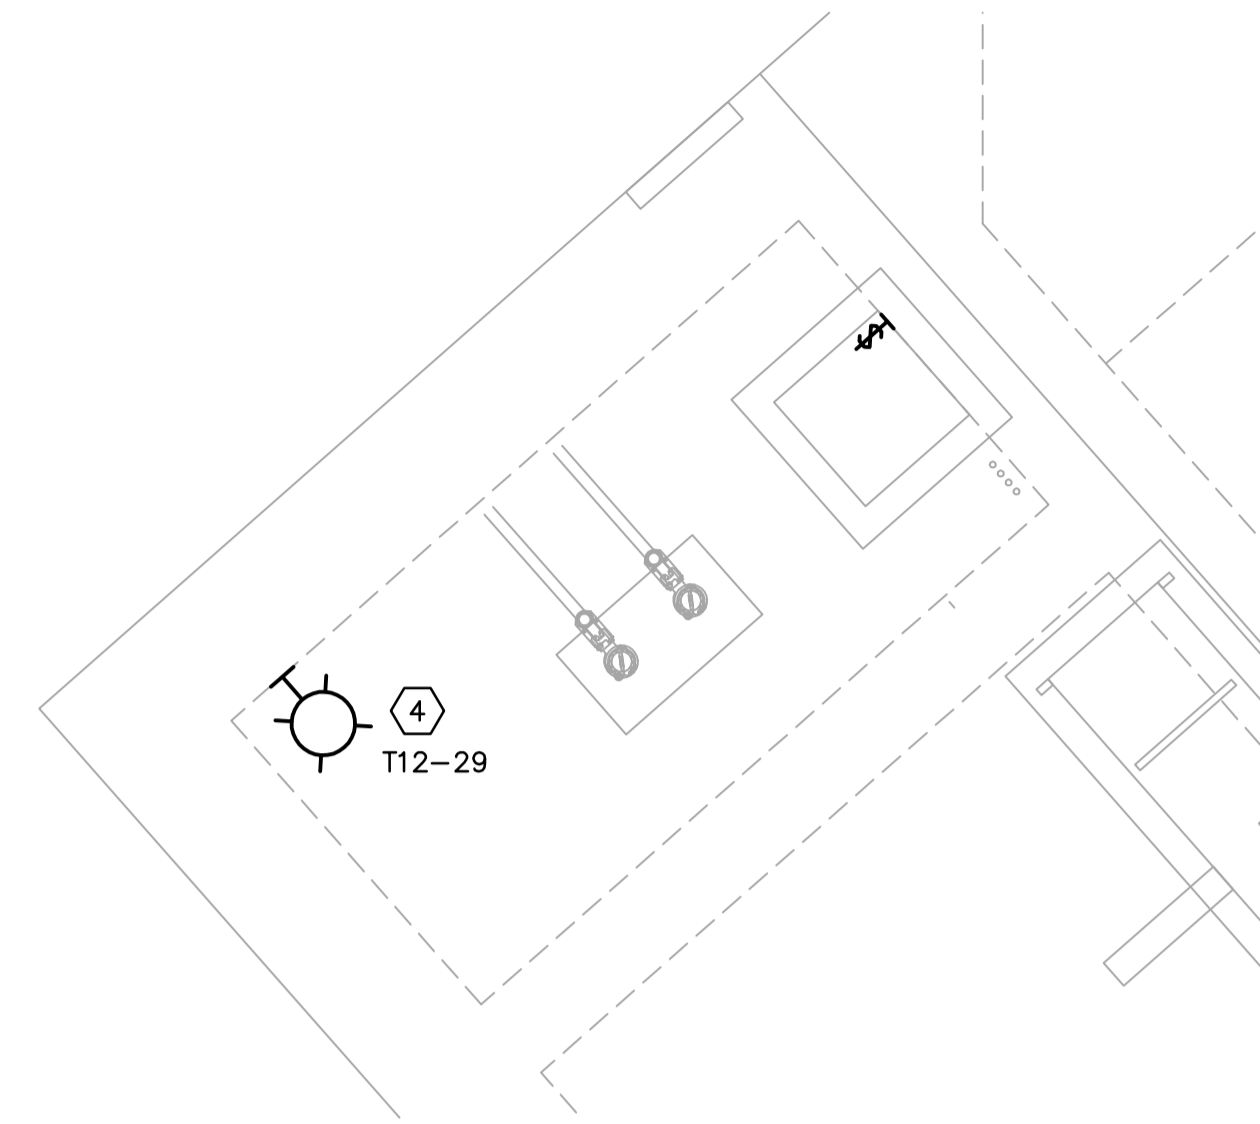

SUMP PIT AREA LIGHTING PLAN
1:50

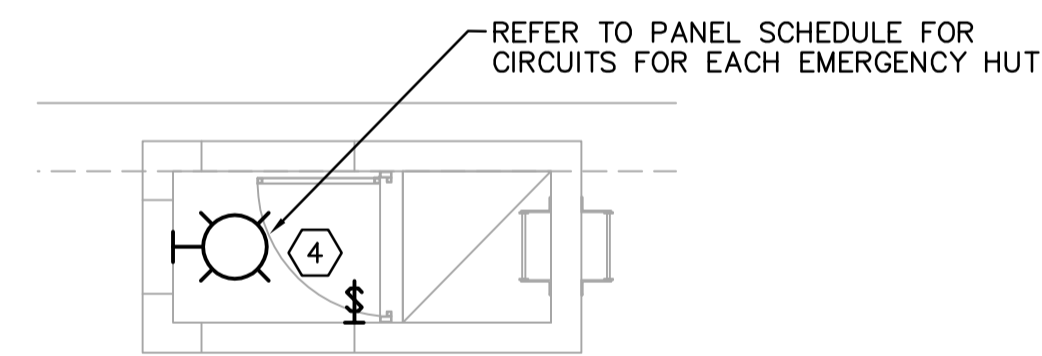

EMERGENCY EGRESS HUT LIGHTING PLAN
1:50

<p>Certificate of Authorization Earth Tech Canada Inc. No. 730 Expiry: April 30, 2007</p>	B.M. ELEV.		<p>Frederickson Cooper ARCHITECTS</p>	<p>A Type International Ltd. Company</p>	ENGINEER'S SEAL		<p>THE CITY OF WINNIPEG WATER AND WASTE DEPARTMENT ENGINEERING DIVISION</p>	ORIGINAL SIGNED BY											
					B.L. MOORE			2006/08/30		CITY FILE NUMBER									
					SCALE: 1:50			RELEASED FOR CONSTRUCTION BY: R. SOROKOWSKI		CONSULTANT DRAWING NO. WT-E0111		SHEET OF							
					DATE 2005/03/18			DATE 2006/08/30		CITY DRAWING NUMBER 1-0601T-A-E0111-001-000		WATER TREATMENT PLANT TREATED WATER STORAGE INLET BUILDING							
<table border="1" style="width: 100%; border-collapse: collapse;"> <thead> <tr> <th>NO.</th> <th>REVISIONS</th> <th>DATE</th> <th>BY</th> <th>DATE</th> </tr> </thead> <tbody> <tr> <td>00</td> <td>ISSUED FOR TENDER</td> <td>06/08/30</td> <td>ERC</td> <td></td> </tr> </tbody> </table>		NO.	REVISIONS	DATE	BY	DATE	00	ISSUED FOR TENDER	06/08/30	ERC						ELECTRICAL LIGHTING AND EMERGENCY LIGHTING FLOOR PLANS			
NO.	REVISIONS	DATE	BY	DATE															
00	ISSUED FOR TENDER	06/08/30	ERC																