

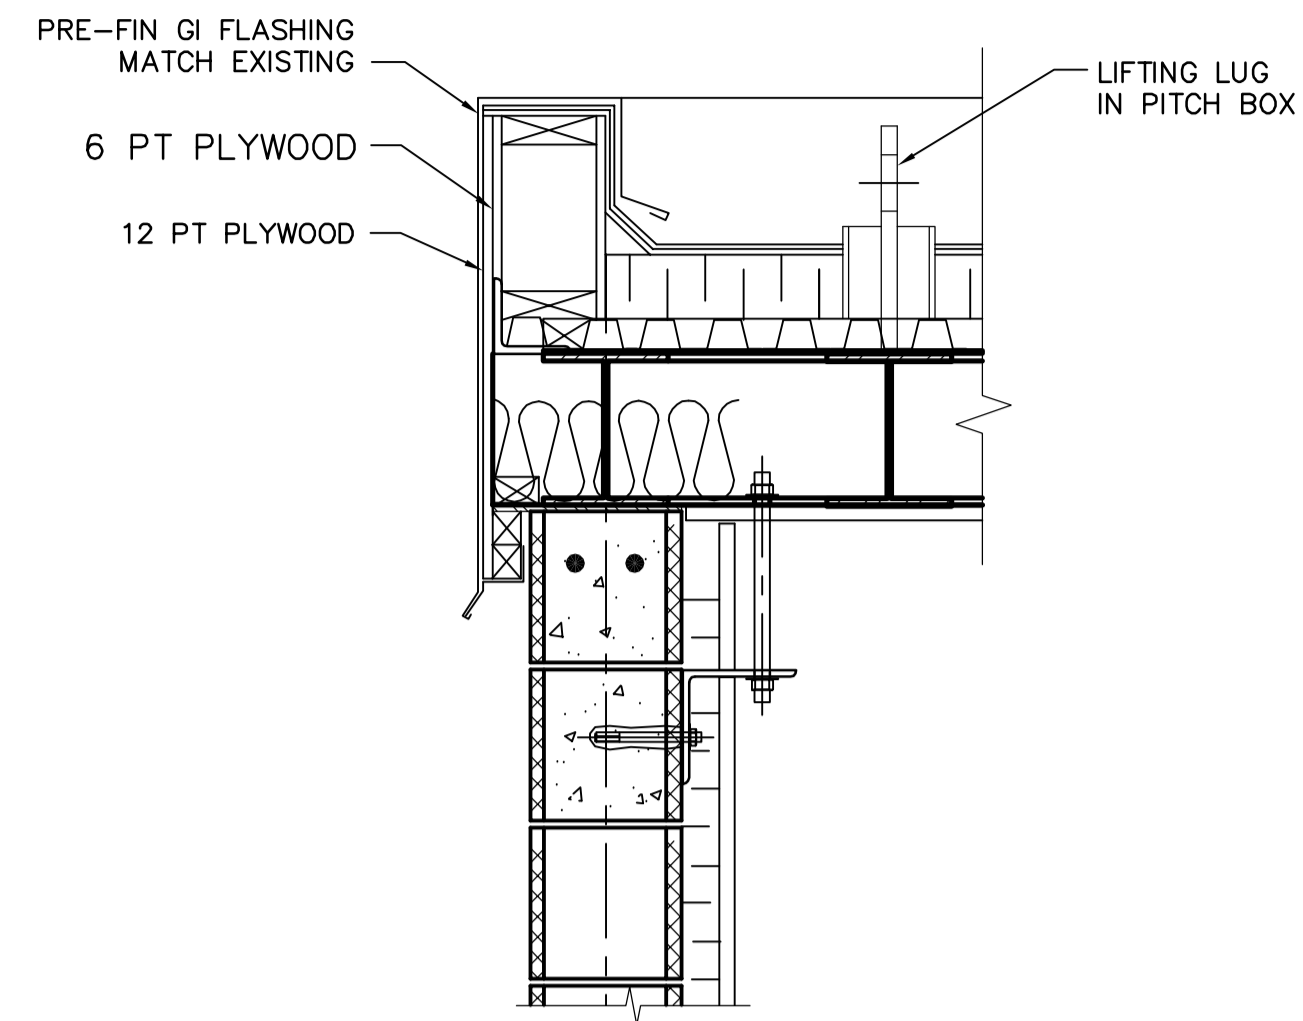



1 WALL SECTIONS
WY-B0160 1:20

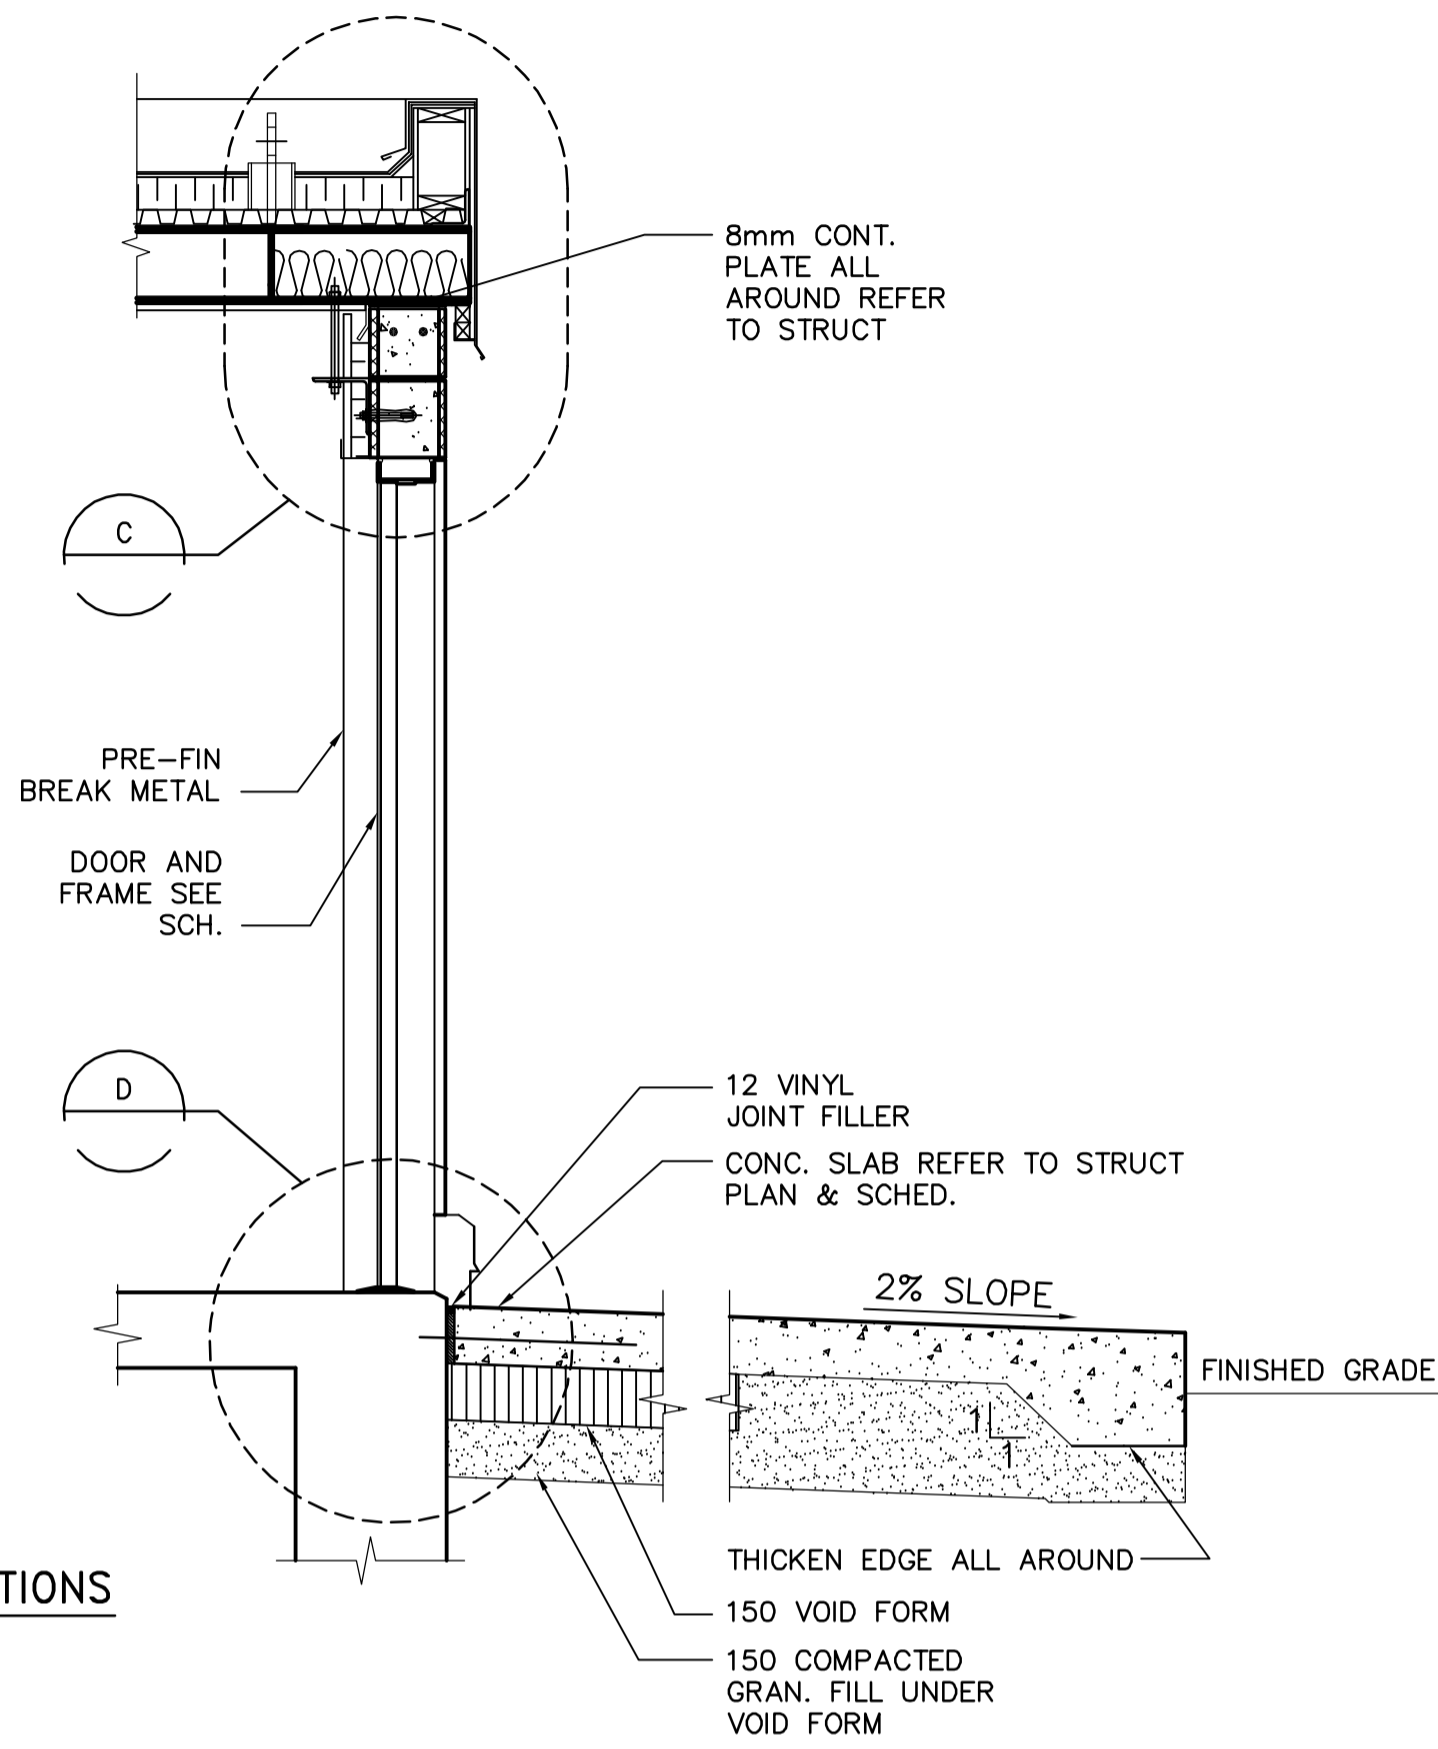


A DETAIL
1:10

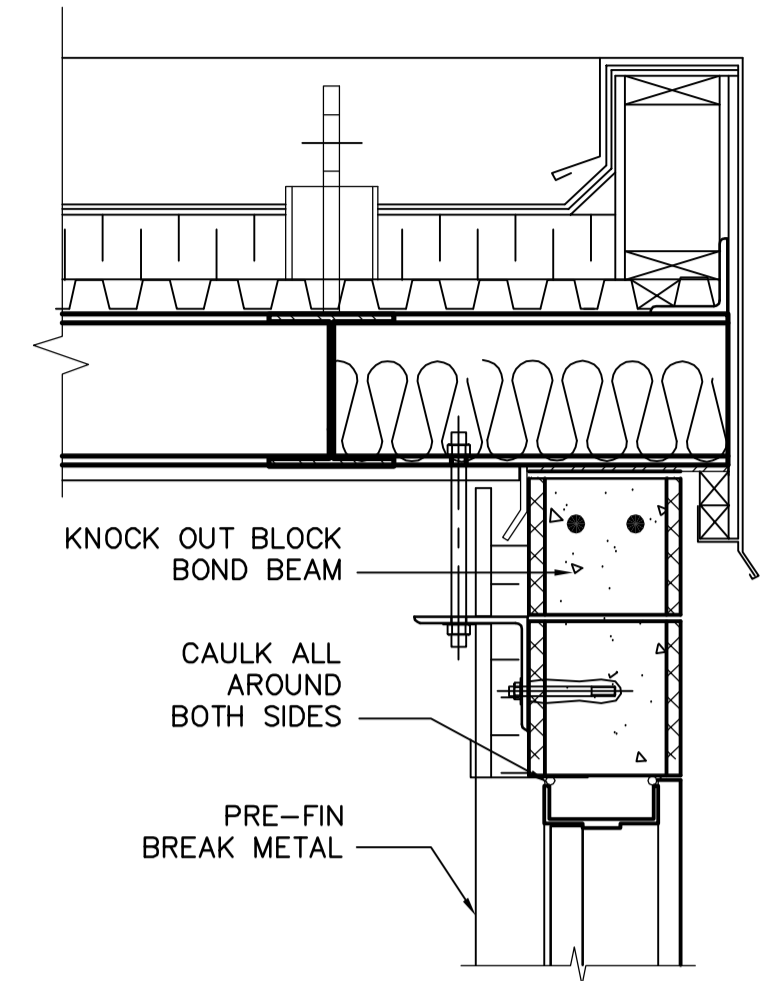


C DETAIL
1:10

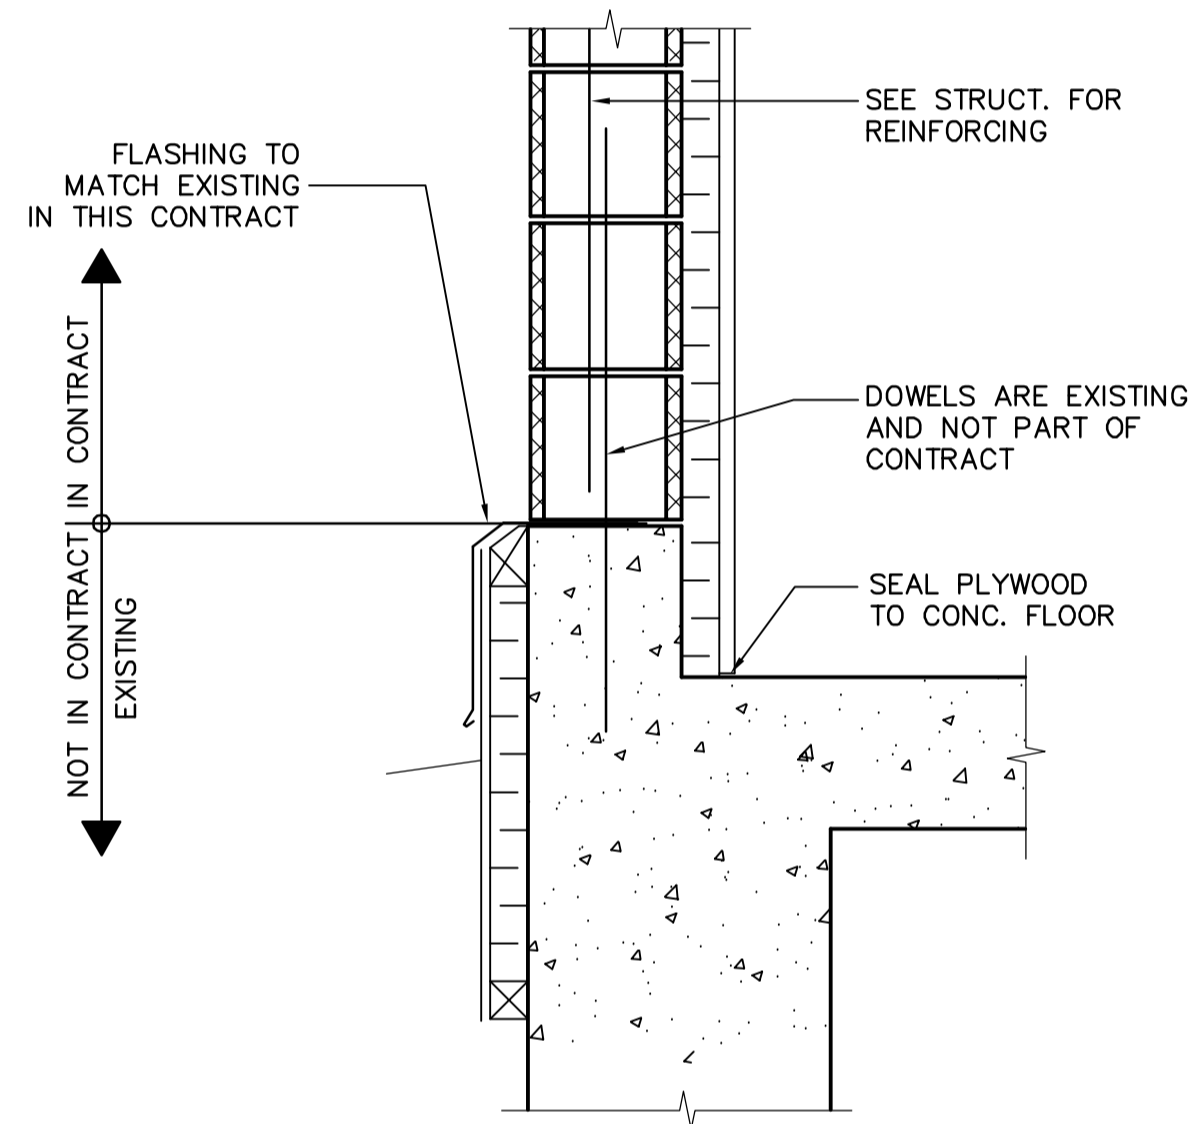


B DETAIL
1:10

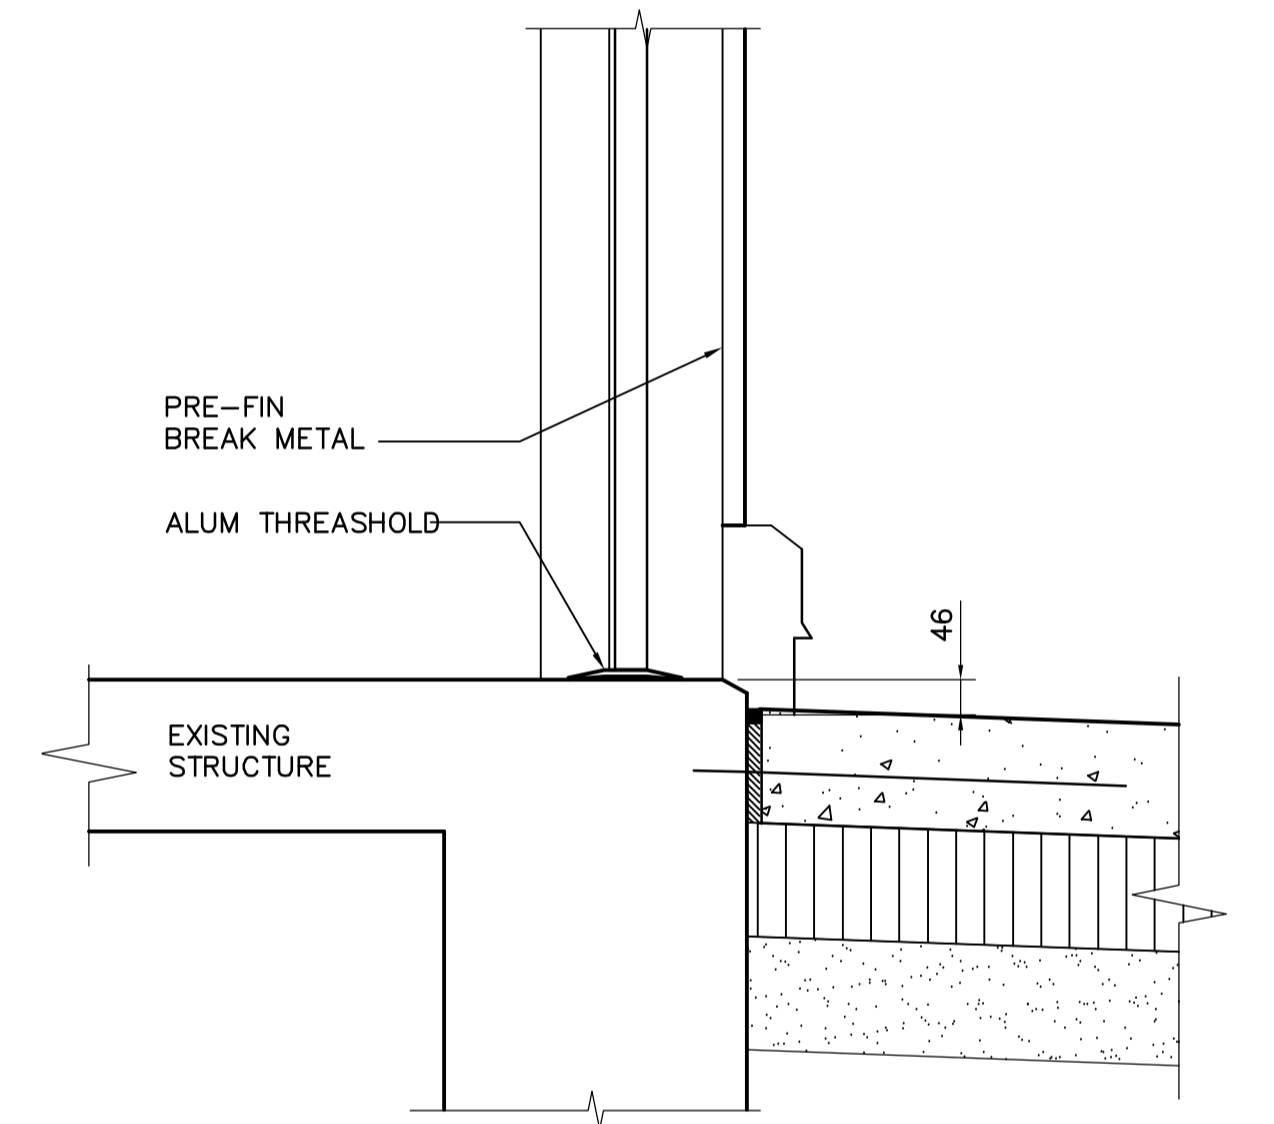


D DETAIL
1:10

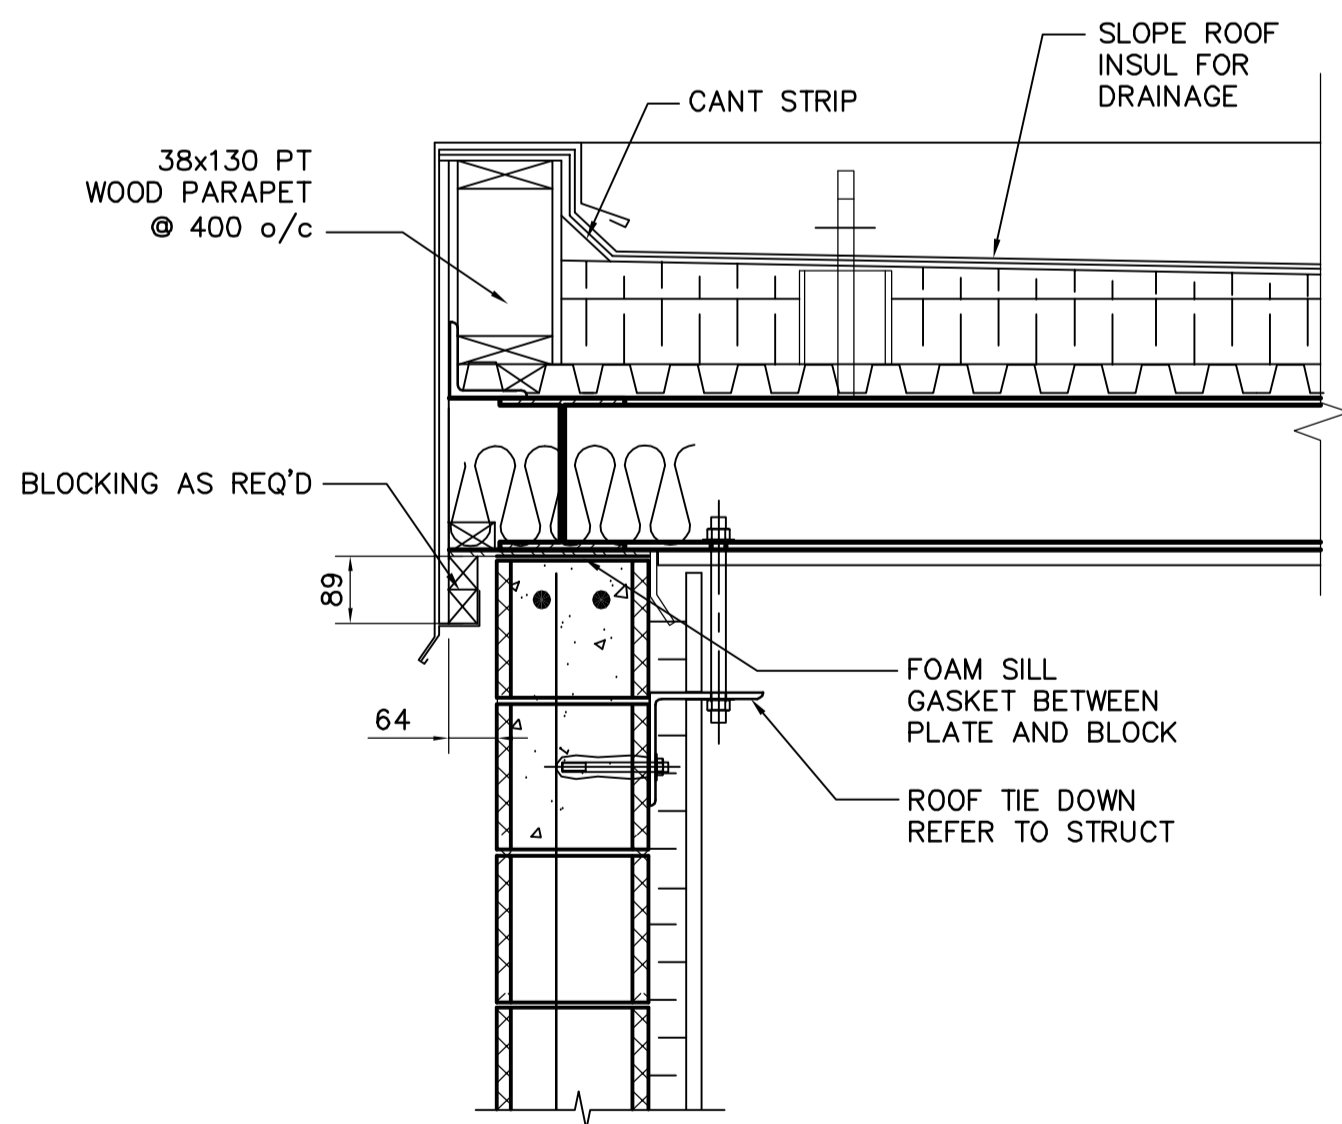

2 DETAIL
WY-B0160 1:10

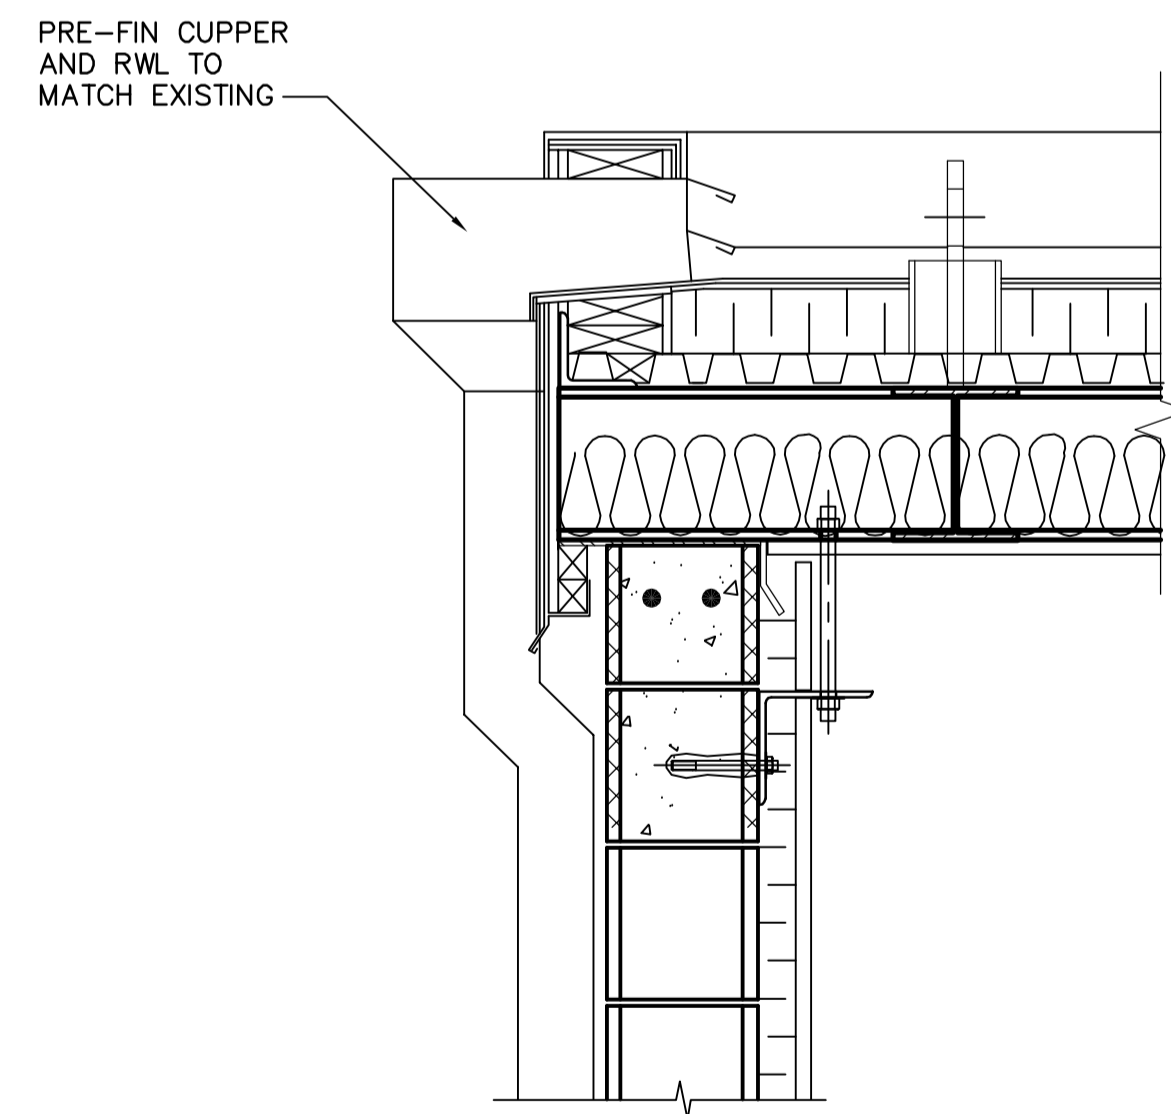

3 SCUPPER DETAIL
WY-B0160 1:10

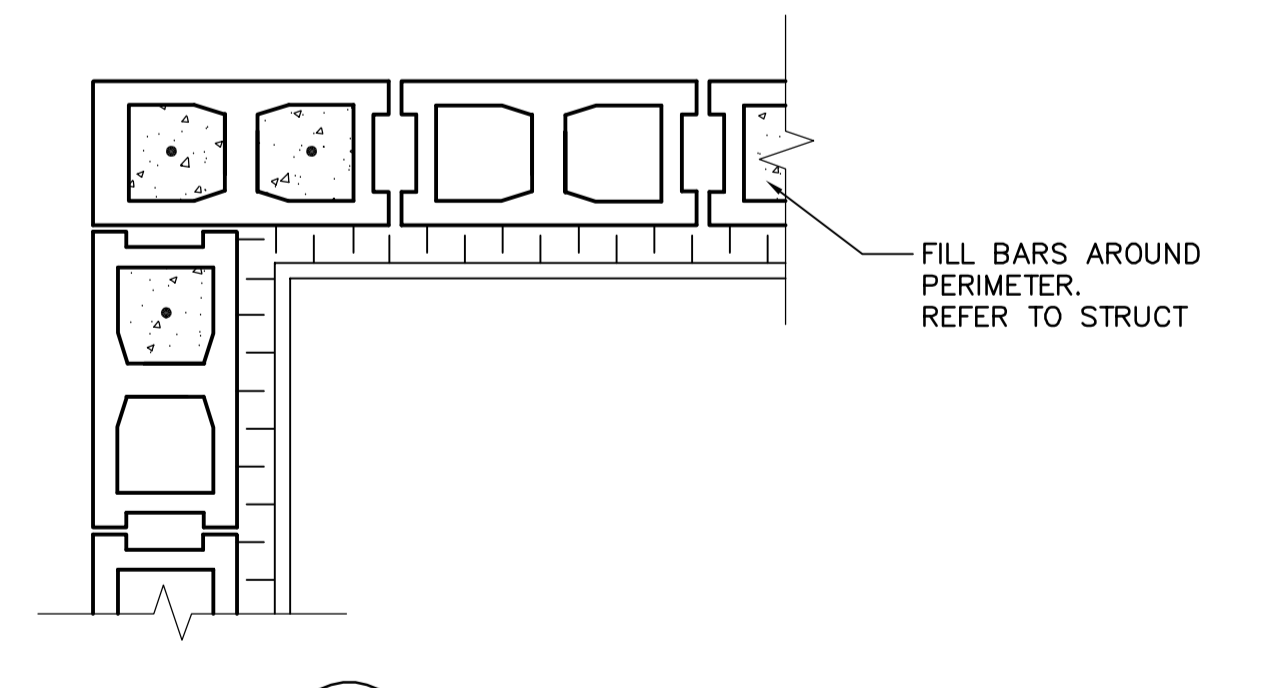

E DETAIL
WY-S0160 1:10

B.M. ELEV.				ENGINEER'S SEAL		THE CITY OF WINNIPEG WATER AND WASTE DEPARTMENT ENGINEERING DIVISION	
		Frederickson Cooper ARCHITECTS		ORIGINAL SIGNED BY N. COOPER 06/08/30		WATER TREATMENT PLANT YARD PIPING AND VALVE CHAMBERS VALVE CHAMBERS	
		DESIGNED BY GGP CHECKED BY NC DRAWN BY GGP APPROVED BY AHL SCALE: AS NOTED RELEASED FOR CONSTRUCTION BY: R. SOROKOWSKI		CONSULTANT DRAWING NO. WY-B0161		CITY FILE NUMBER SHEET OF CITY DRAWING NUMBER 1-0601Y-A-B0161-001-000	
00 ISSUED FOR TENDER 06/08/28 WDB		DATE 2006/06/01		DATE 06/08/30			
NO. REVISIONS		DATE BY					