


LIST OF MATERIALS

No.	DESCRIPTION	QNTY	LENGTH	No.	DESCRIPTION	QNTY	LENGTH	No.	DESCRIPTION	QNTY	LENGTH
1	750mm CONCRETE PRESSURE PIPE (WALL PIECE) (PLAIN END TO FLANGE END)	1	1500mm	9	100mm BACKWATER VALVE WITH ACCESS SLEEVE	1		19	75mm BRASS NIPPLE (THREADED)	1	
2	750mm COUPLING (VICTAULIC STYLE No. 44)	1		10	100mm PVC SDR35 P-TRAP, 100x100x100mm TEE, & 100mm CLEANOUT c/w THREADED PLUG	1		20	75mm BRASS FLANGE (THREADED)	1	
3	750mm CONCRETE PRESSURE PIPE (WALL PIECE) (FLANGE TO PLAIN END)	1	1300mm	11	100mm PVC SDR35 DRAIN	1		21	75mm STEEL FLANGE (THREADED) C/W ISOLATION KIT	1	
4	750mm BUTTERFLY VALVE (SUPPLIED BY CITY)	1	305mm	12	50mm BRONZE GATE VALVE (THREADED)	1		22	75mm BRASS NIPPLE (THREADED)	1	
5	750mm CONCRETE PRESSURE PIPE (FLANGE END TO VICTAULIC STYLE 44 END)	3	±300mm (TO SUIT)	13	50mm BRASS NIPPLE (THREADED)	1		23	100x150mm INCREASER	1	
6	750mm CONCRETE PRESSURE PIPE (WALL PIECE) (VICTAULIC STYLE 44 END TO PLAIN END)	1	1774mm	14	50mm BRASS FLANGE (THREADED)	1		24	150mm PVC SDR 35 DRAIN	1	
7	750x750x750mm CONCRETE PRESSURE TEE	1		15	50mm STEEL FLANGE (THREADED) C/W ISOLATION KIT	1		25	750mm BOLTED SLEEVE COUPLING	4	
8	VALVE OPERATOR (SUPPLIED BY CITY)	1		16	50mm STEEL NIPPLE (THREADED)	1		26	STANDARD CITY VALVE STEM EXTENSION	1	TO SUIT
				17	75mm STREET 90° ELBOW BRASS (THREADED)	1					
				18	75mm BRONZE GATE VALVE (THREADED)	1					

NOTE: 50mm AND 75mm PIPE AND FITTINGS - SCHEDULE 80
NOTE: PLAIN END OD TO MATCH 750 PVC C905 OD

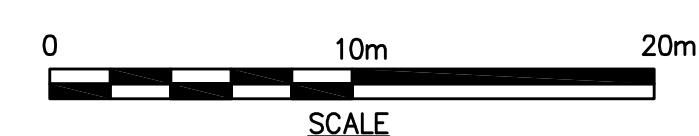

FLOOR PLAN
1:20

<p>Certificate of Authorization Earth Tech Canada Inc. No. 730 Expiry: April 30, 2007</p>	<p>B.M. ELEV.</p>	<p>Frederickson Cooper ARCHITECTS</p>	<p>A Tyco International Ltd. Company</p>	ENGINEER'S SEAL	<p>THE CITY OF WINNIPEG WATER AND WASTE DEPARTMENT ENGINEERING DIVISION</p>
				<p>DESIGNED BY GSK DRAWN BY GDL SCALE: AS NOTED</p>	
<p>00 ISSUED FOR TENDER 07/01/26 GSK NO. REVISIONS DATE BY</p>	<p>2006/11/21 DATE</p>	<p>2006/01/26 DATE</p>	<p>CONSULTANT DRAWING NO. WY-C0214</p>	<p>CIVIL SUPERNATANT VALVE CHAMBER 2 PLAN, SECTIONS & DETAILS</p>	<p>CITY FILE NUMBER SHEET OF CITY DRAWING NUMBER 1-0601Y-C-C0214-001-000</p>