



3 ROOF PLAN
WS-B0404 1:30

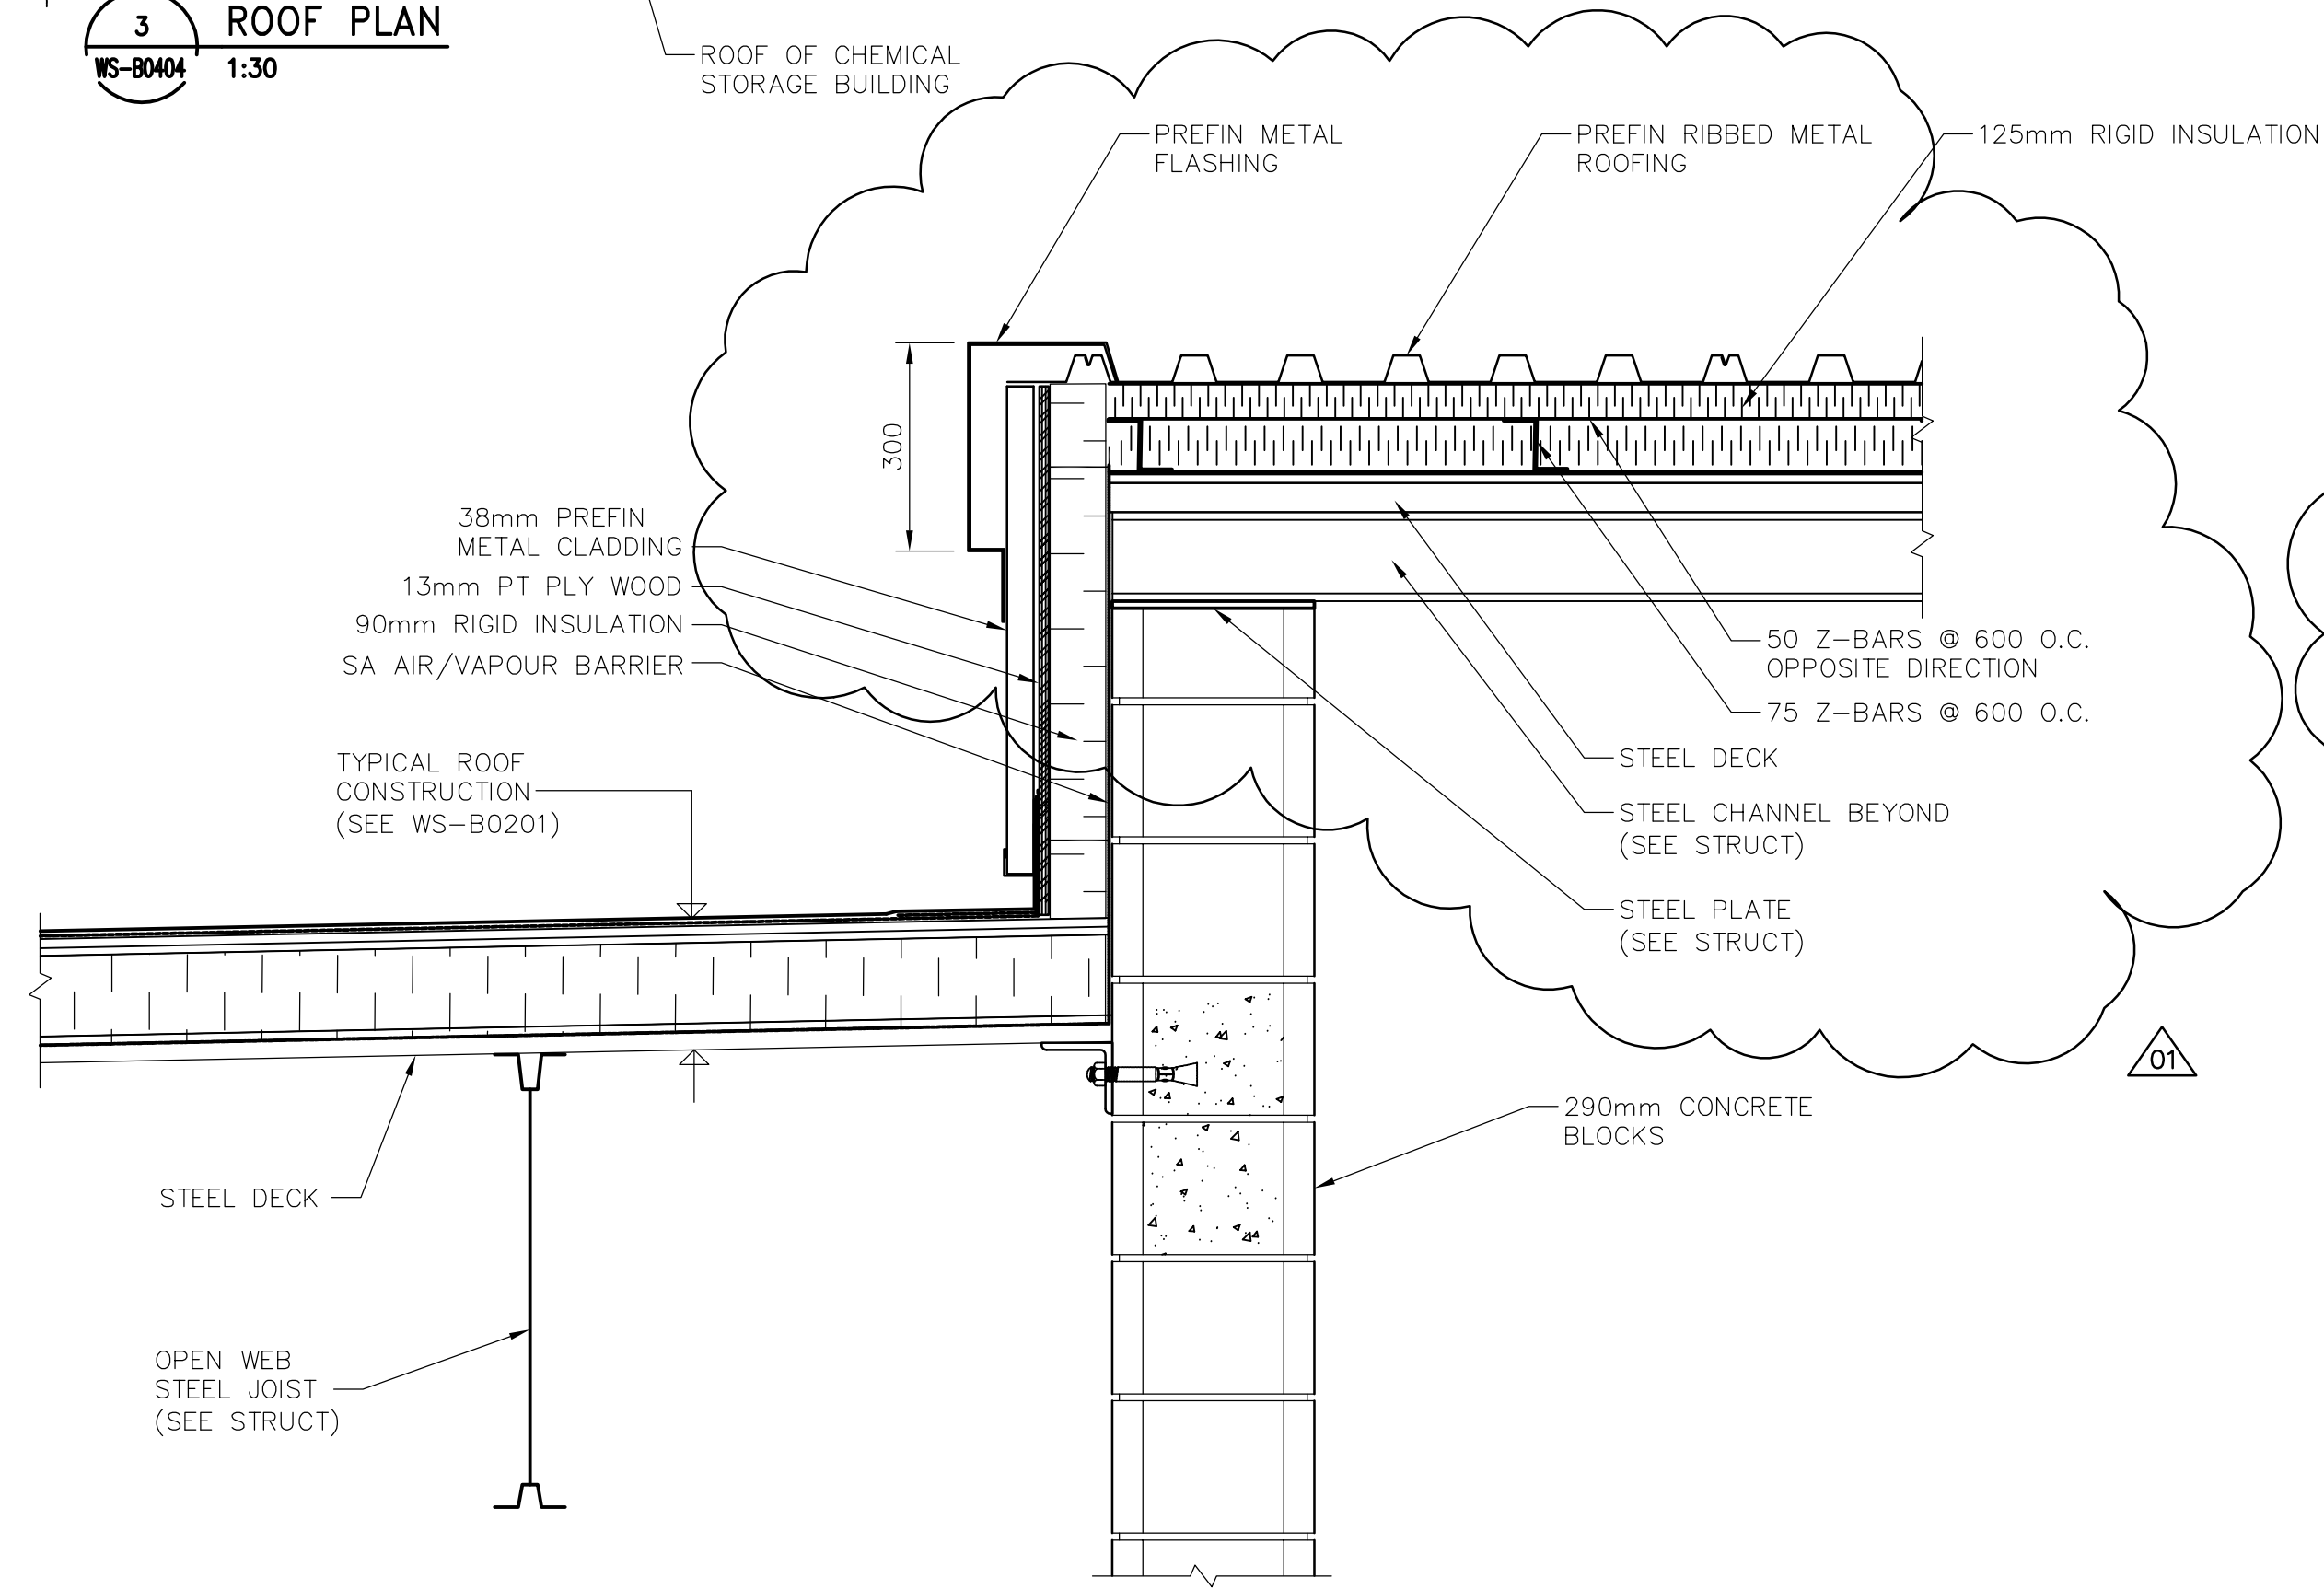

1 DETAIL
WS-B0403 1:10

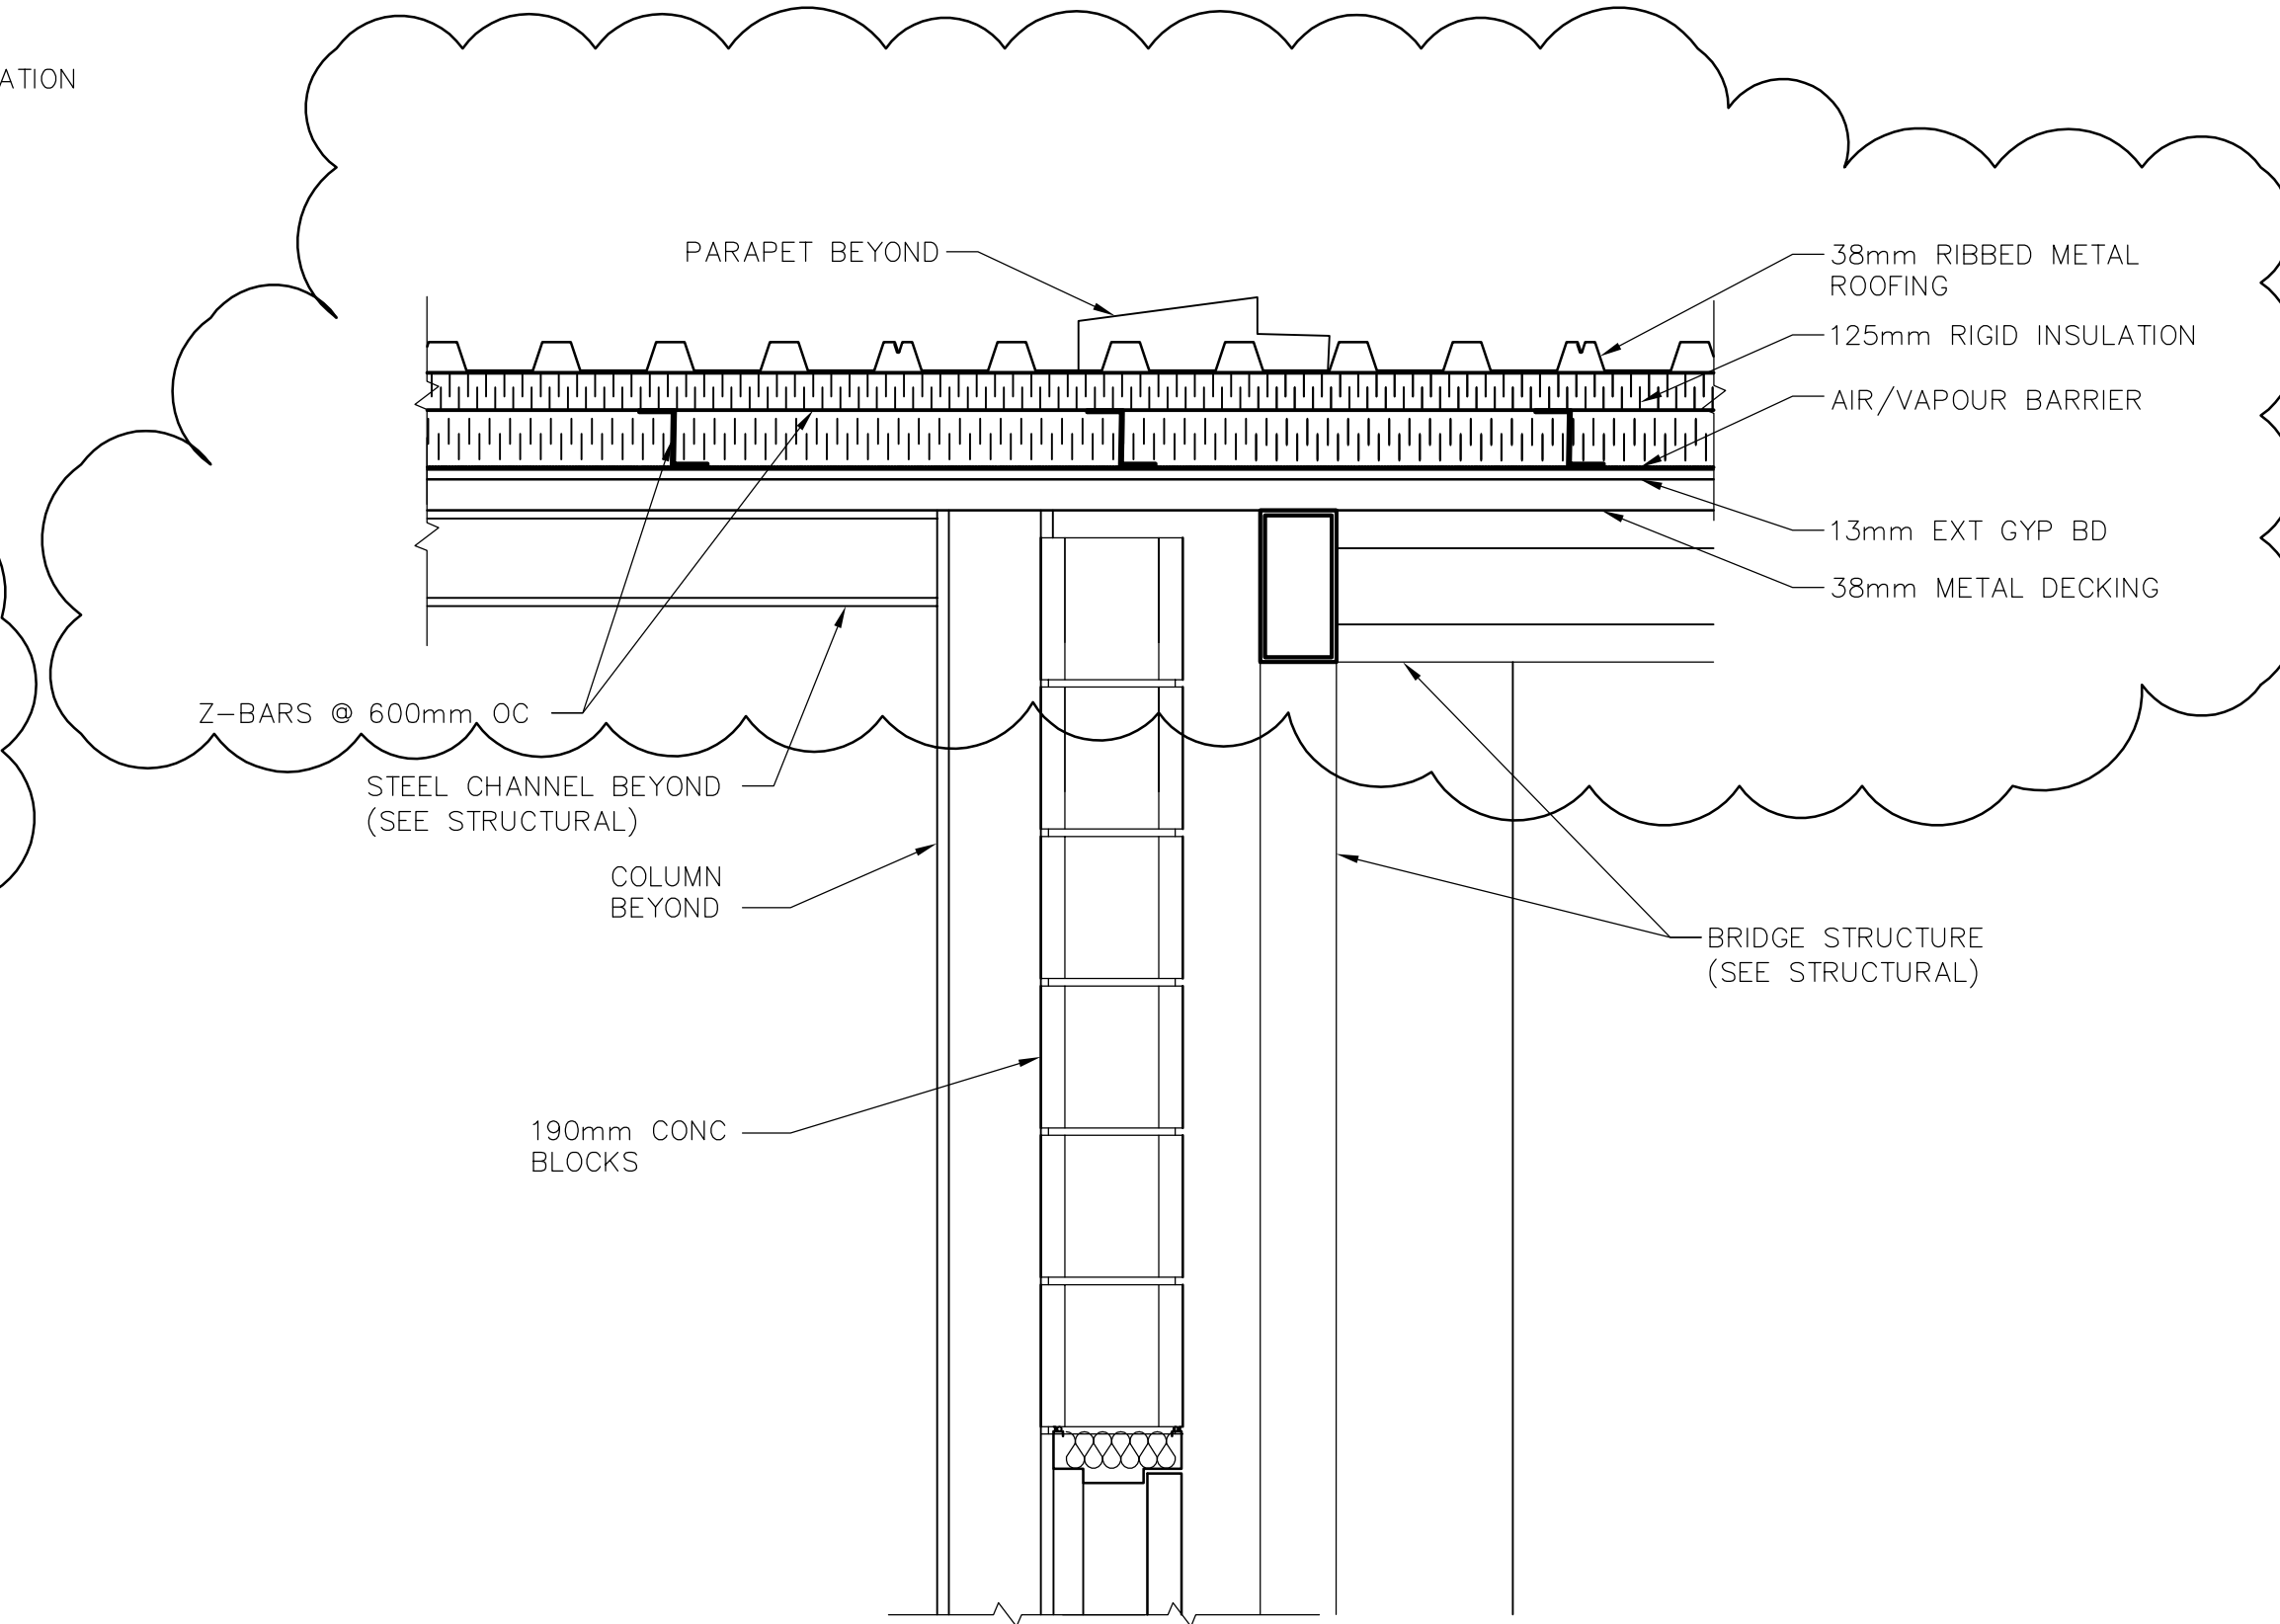

2 DETAIL
WS-B0403 1:10



NO.	REVISIONS	DATE	BY
01	792-2006 ADENDUM 2	07/03/20	AL
00	ISSUED FOR TENDER	07/01/31	AL

DESIGNED BY	CHECKED BY
NC	LK
DRAWN BY	APPROVED BY
AL	AHL
SCALE:	RELEASED FOR CONSTRUCTION BY:
AS SHOWN	R. SOROKOWSKI
DATE	DATE
2006/10/02	2007/01/31

ENGINEER'S SEAL
ORIGINAL SIGNED BY NEIL COOPER 2007/01/31
CONSULTANT DRAWING NO. WS-B0404

THE CITY OF WINNIPEG
WATER AND WASTE DEPARTMENT
ENGINEERING DIVISION

WATER TREATMENT PLANT
BULK CHEMICAL BUILDING
SODIUM HYPOCHLORITE AND CHEMICAL STORAGE BUILDING

ARCHITECTURAL
ROOF PLAN OF BRIDGE AND DETAILS

CITY FILE NUMBER	
SHEET	OF
CITY DRAWING NUMBER	1-0601S-A-B0404-001-01D