


ROOF PLAN
1:75

GENERAL NOTES

1. COORDINATE WITH OTHER TRADES TO PREVENT CONFLICTS.
2. SPACE PERIMETER AIR TERMINALS EVENLY AROUND PARAPET.
3. INSTALLATION SHALL CONFORM TO CLASS I AS SPECIFIED IN LPI-175 AND CSA-B72-M87.
4. SECONDARY BONDING NOT INDICATED. BOND ALL ROOF MOUNTED MECHANICAL EQUIPMENT AND VENTS, FLASHING, DRAINS, LADDERS, ETC. TO MEET CLASS I REQUIREMENTS.

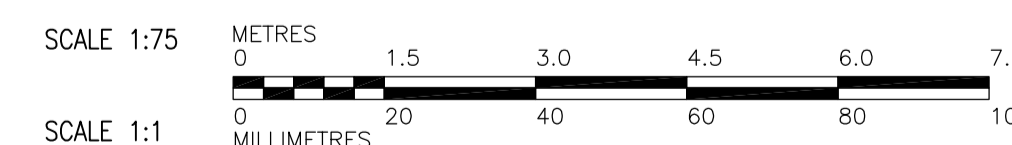

 APEGM Certificate of Authorization Earth Tech Canada Inc. No. 730 Expiry: April 30, 2007	B.M. ELEV.	 Frederickson Cooper ARCHITECTS	 A Tyco International Ltd. Company	ENGINEER'S SEAL ORIGINAL SIGNED BY P. STRYK 2007/01/31 CONSULTANT DRAWING NO. WS-E0142	 THE CITY OF WINNIPEG WATER AND WASTE DEPARTMENT ENGINEERING DIVISION WATER TREATMENT PLANT BULK CHEMICAL STORAGE SODIUM HYPOCHLORITE AND CHEMICAL STORAGE BUILDING ELECTRICAL ROOF PLAN LIGHTNING PROTECTION	CITY FILE NUMBER	
	DESIGNED BY: BLM					CHECKED BY: PS	SHEET OF
	DRAWN BY: ERC					APPROVED BY: AHL	CITY DRAWING NUMBER
	SCALE: 1:75					RELEASED FOR CONSTRUCTION BY: R. SOROKOWSKI	1-0601S-A-E0142-001-010
NO. REVISIONS	DATE BY	DATE	DATE	DATE			
01	792-2006 ADDENDUM 2	07/03/21	ERC				
00	ISSUED FOR TENDER	07/01/31	ERC				
				2007/01/30			
				2007/01/31			