




4 SOUTH ELEVATION  
WJ-B0403 1:30

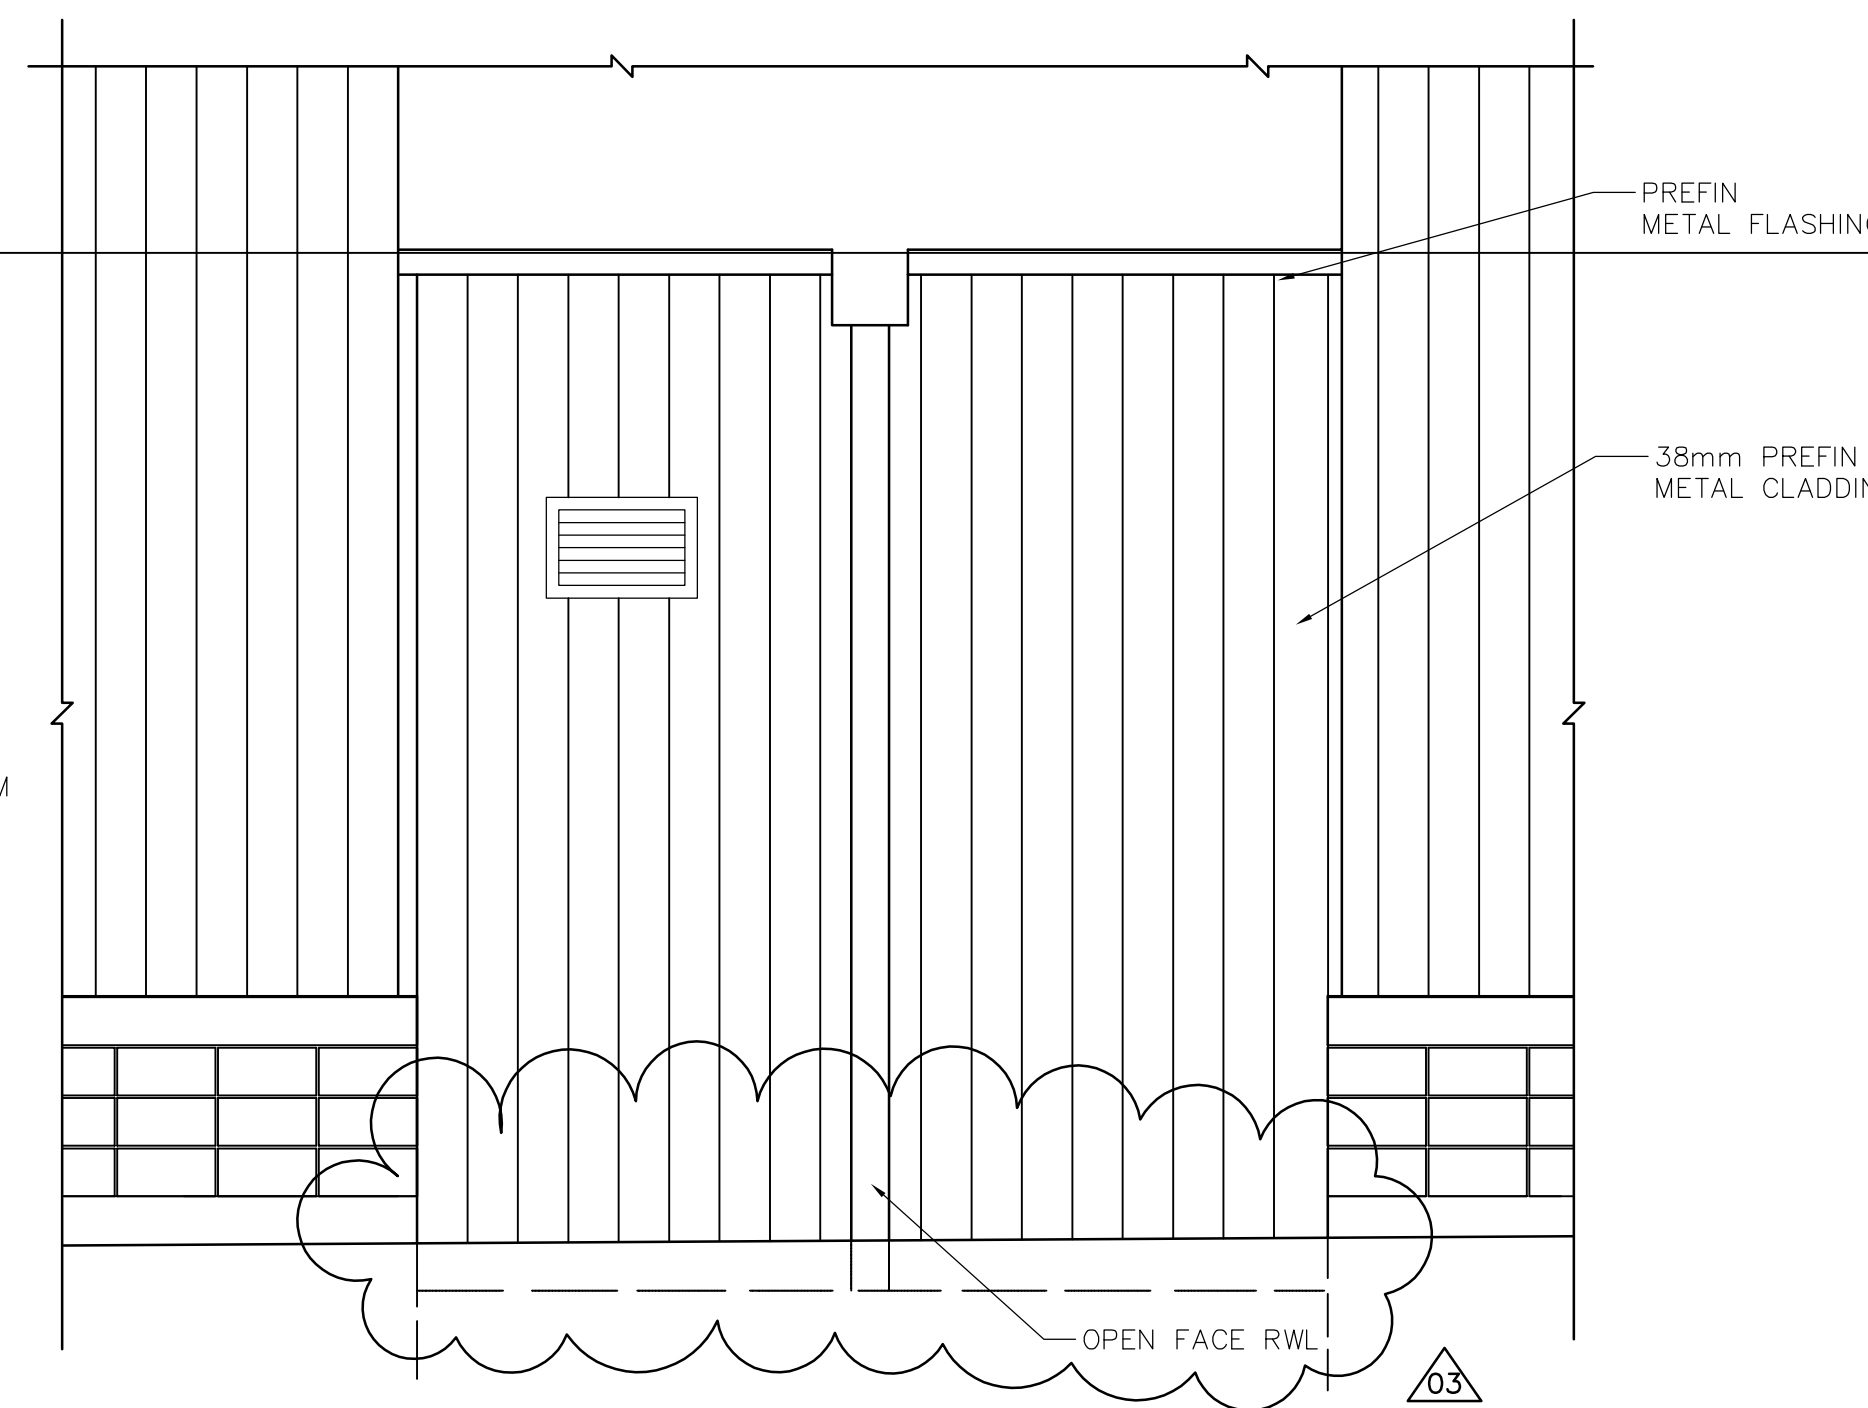


5 NORTH ELEVATION  
WJ-B0403 1:30

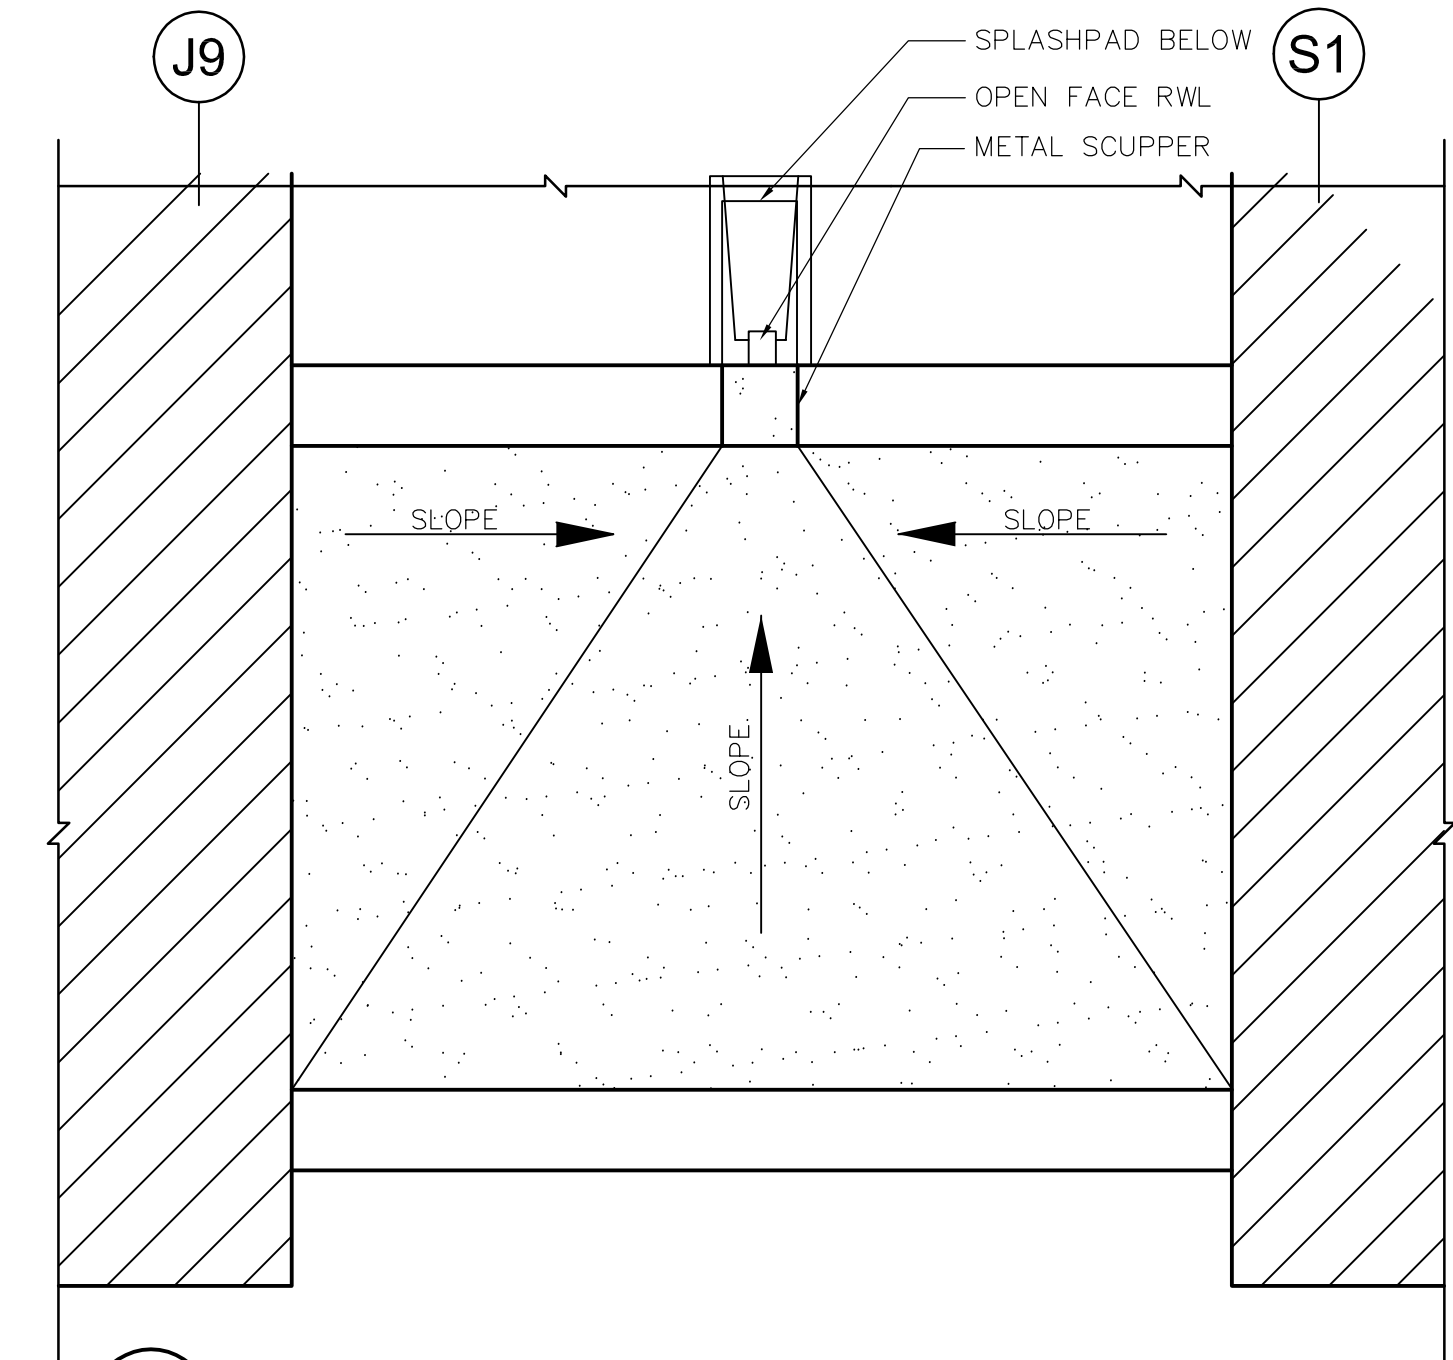


6 ROOF PLAN  
WJ-B0403 1:30

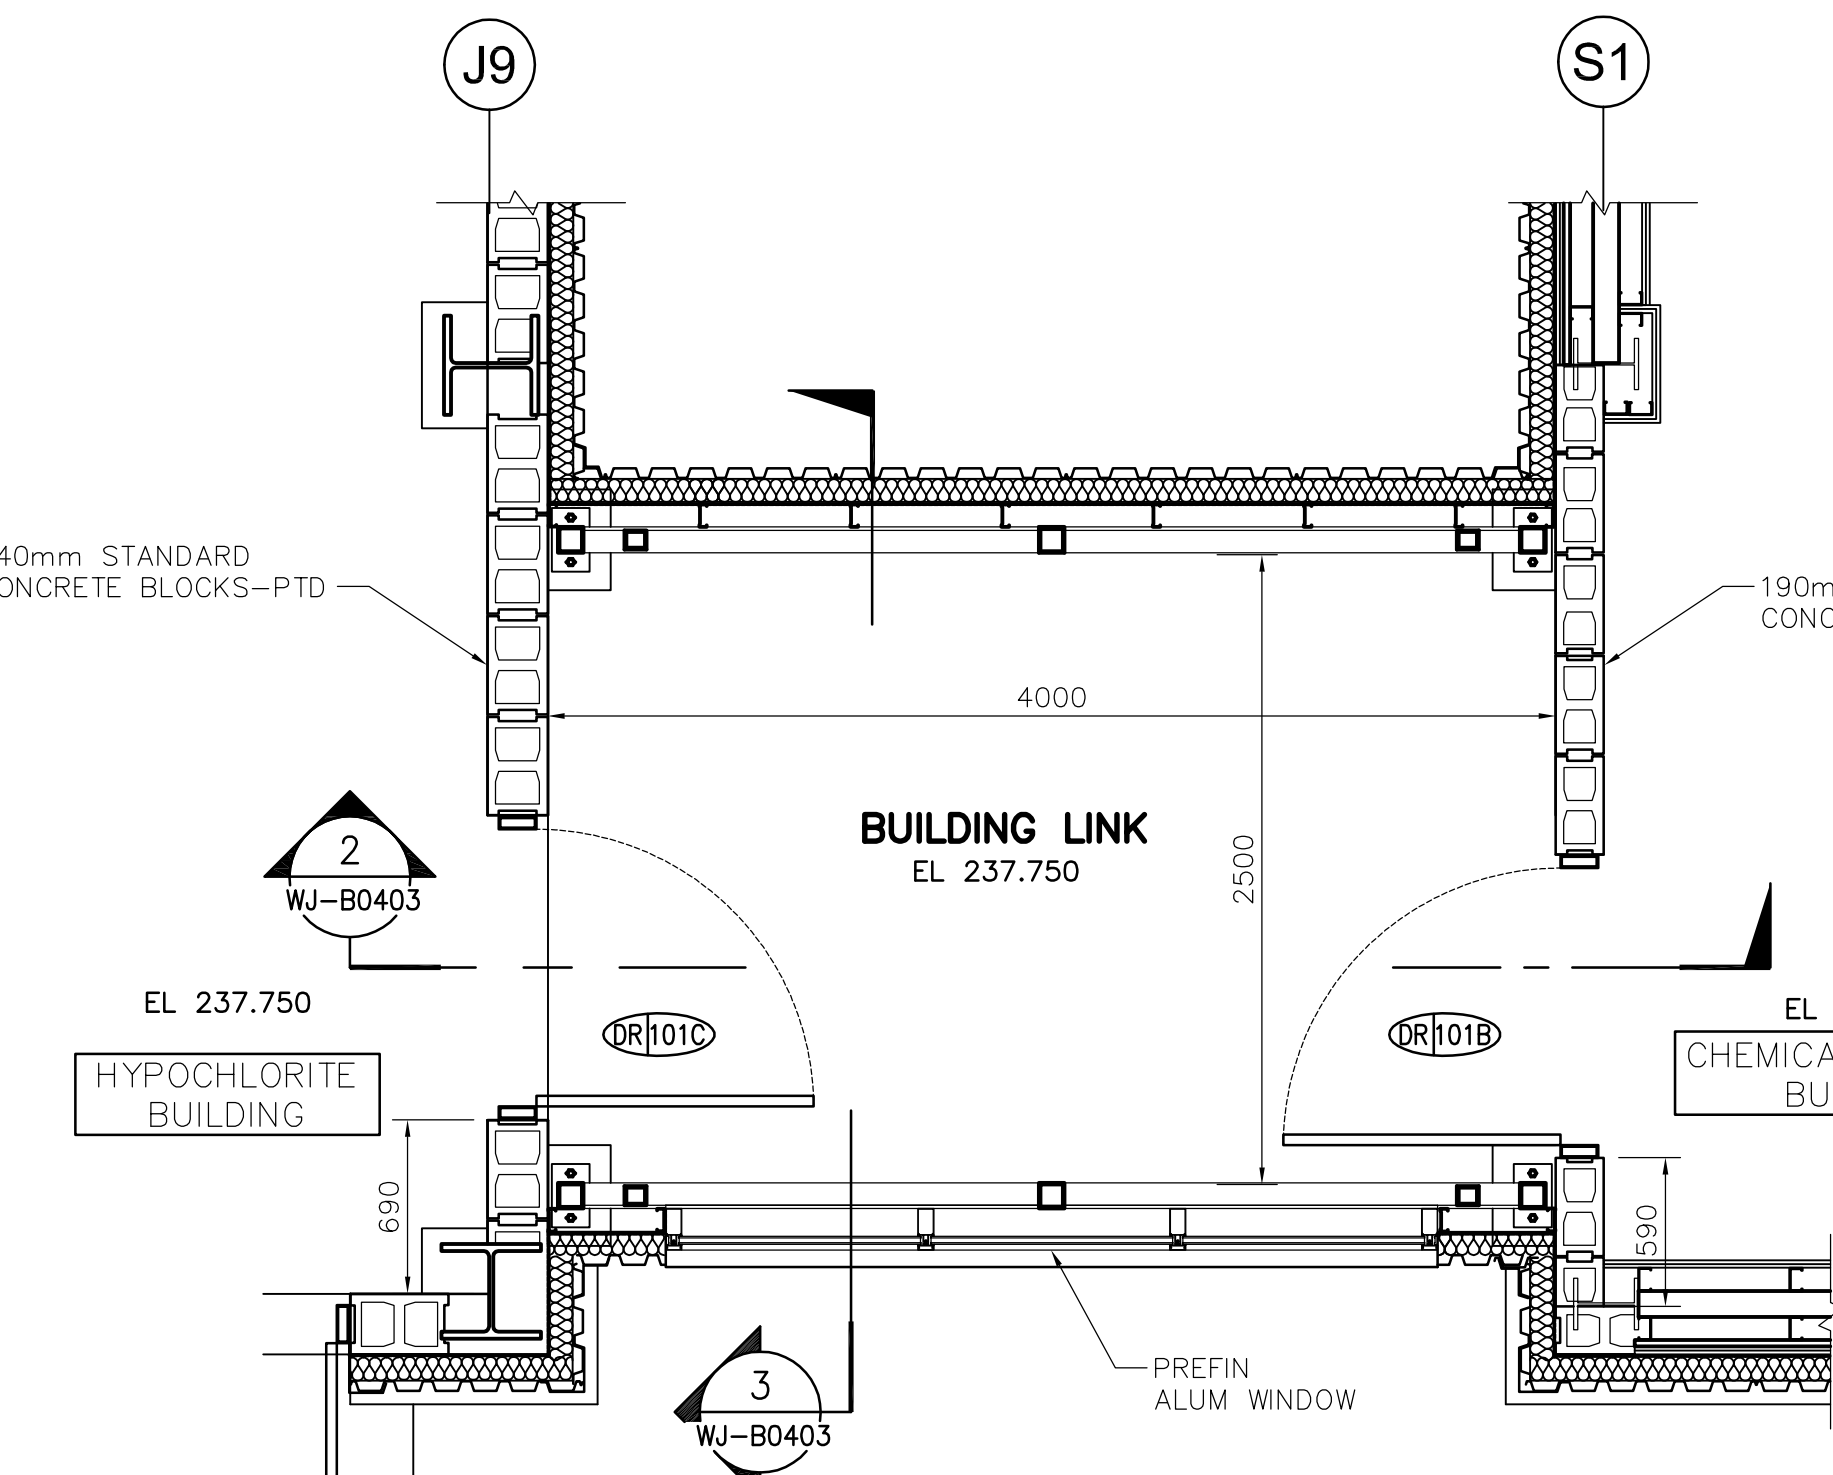

1 FLOOR PLAN  
WJ-B0403 1:30

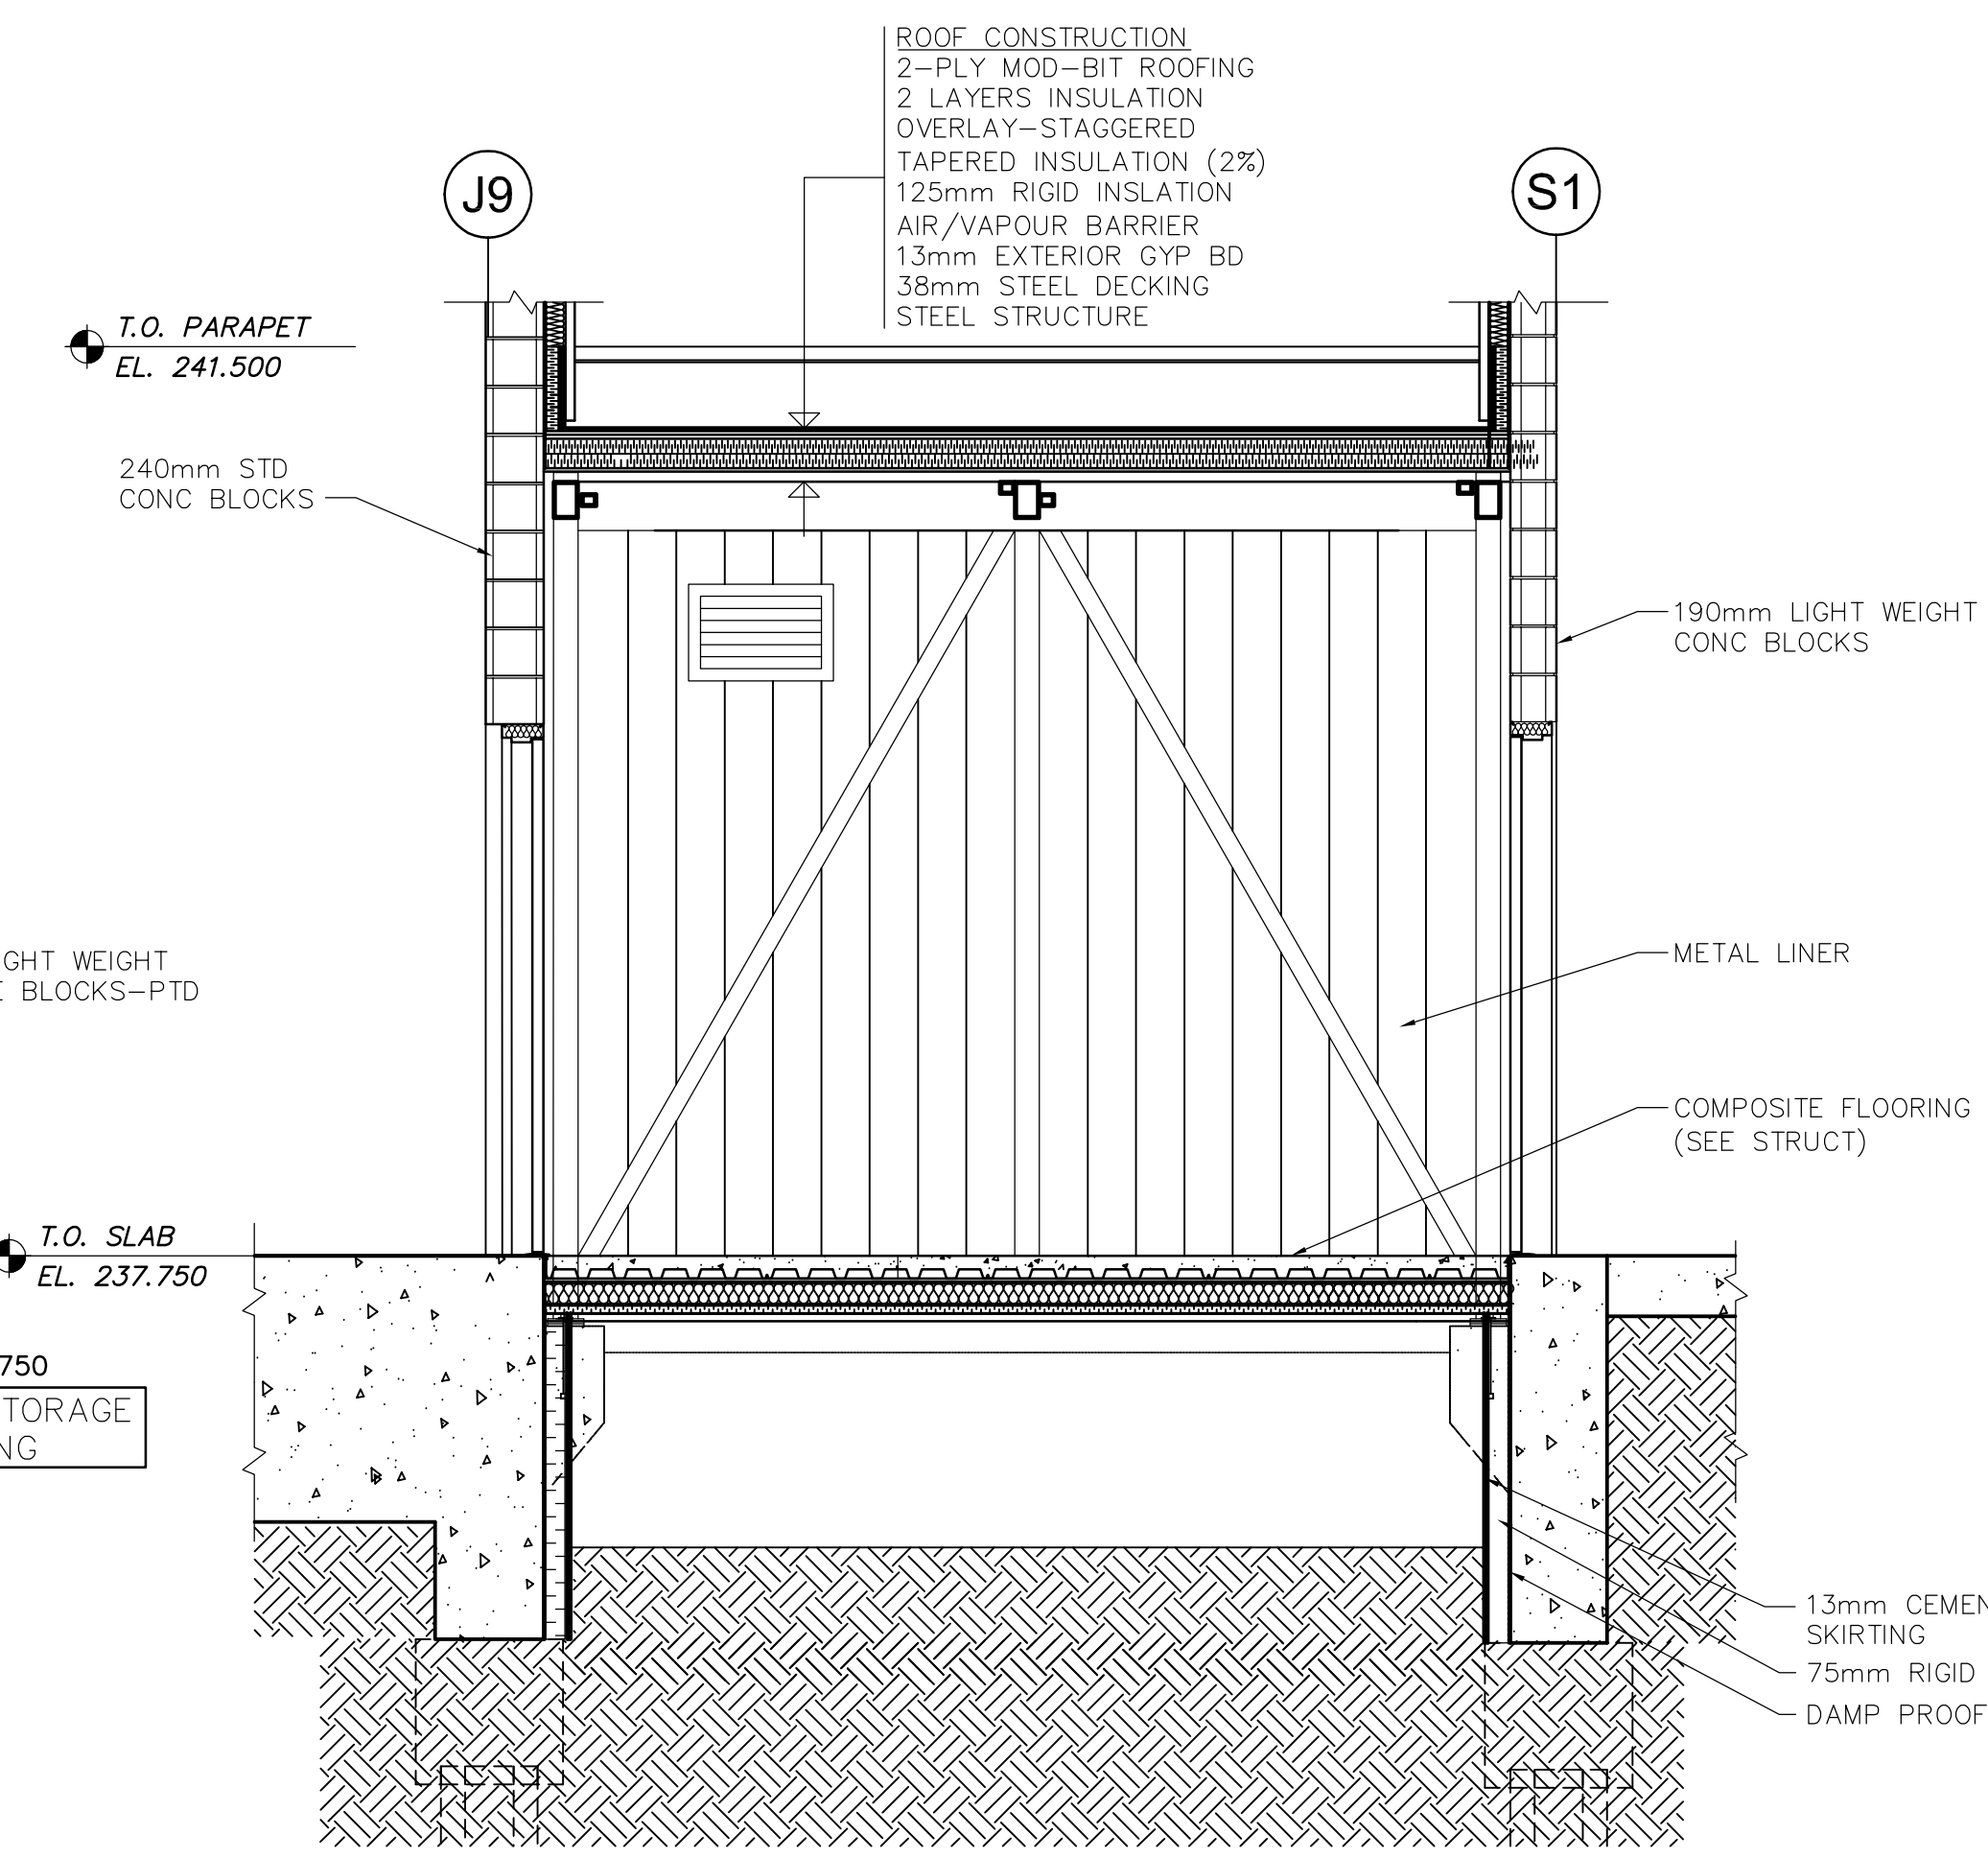

2 SECTION A  
WJ-B0403 1:30

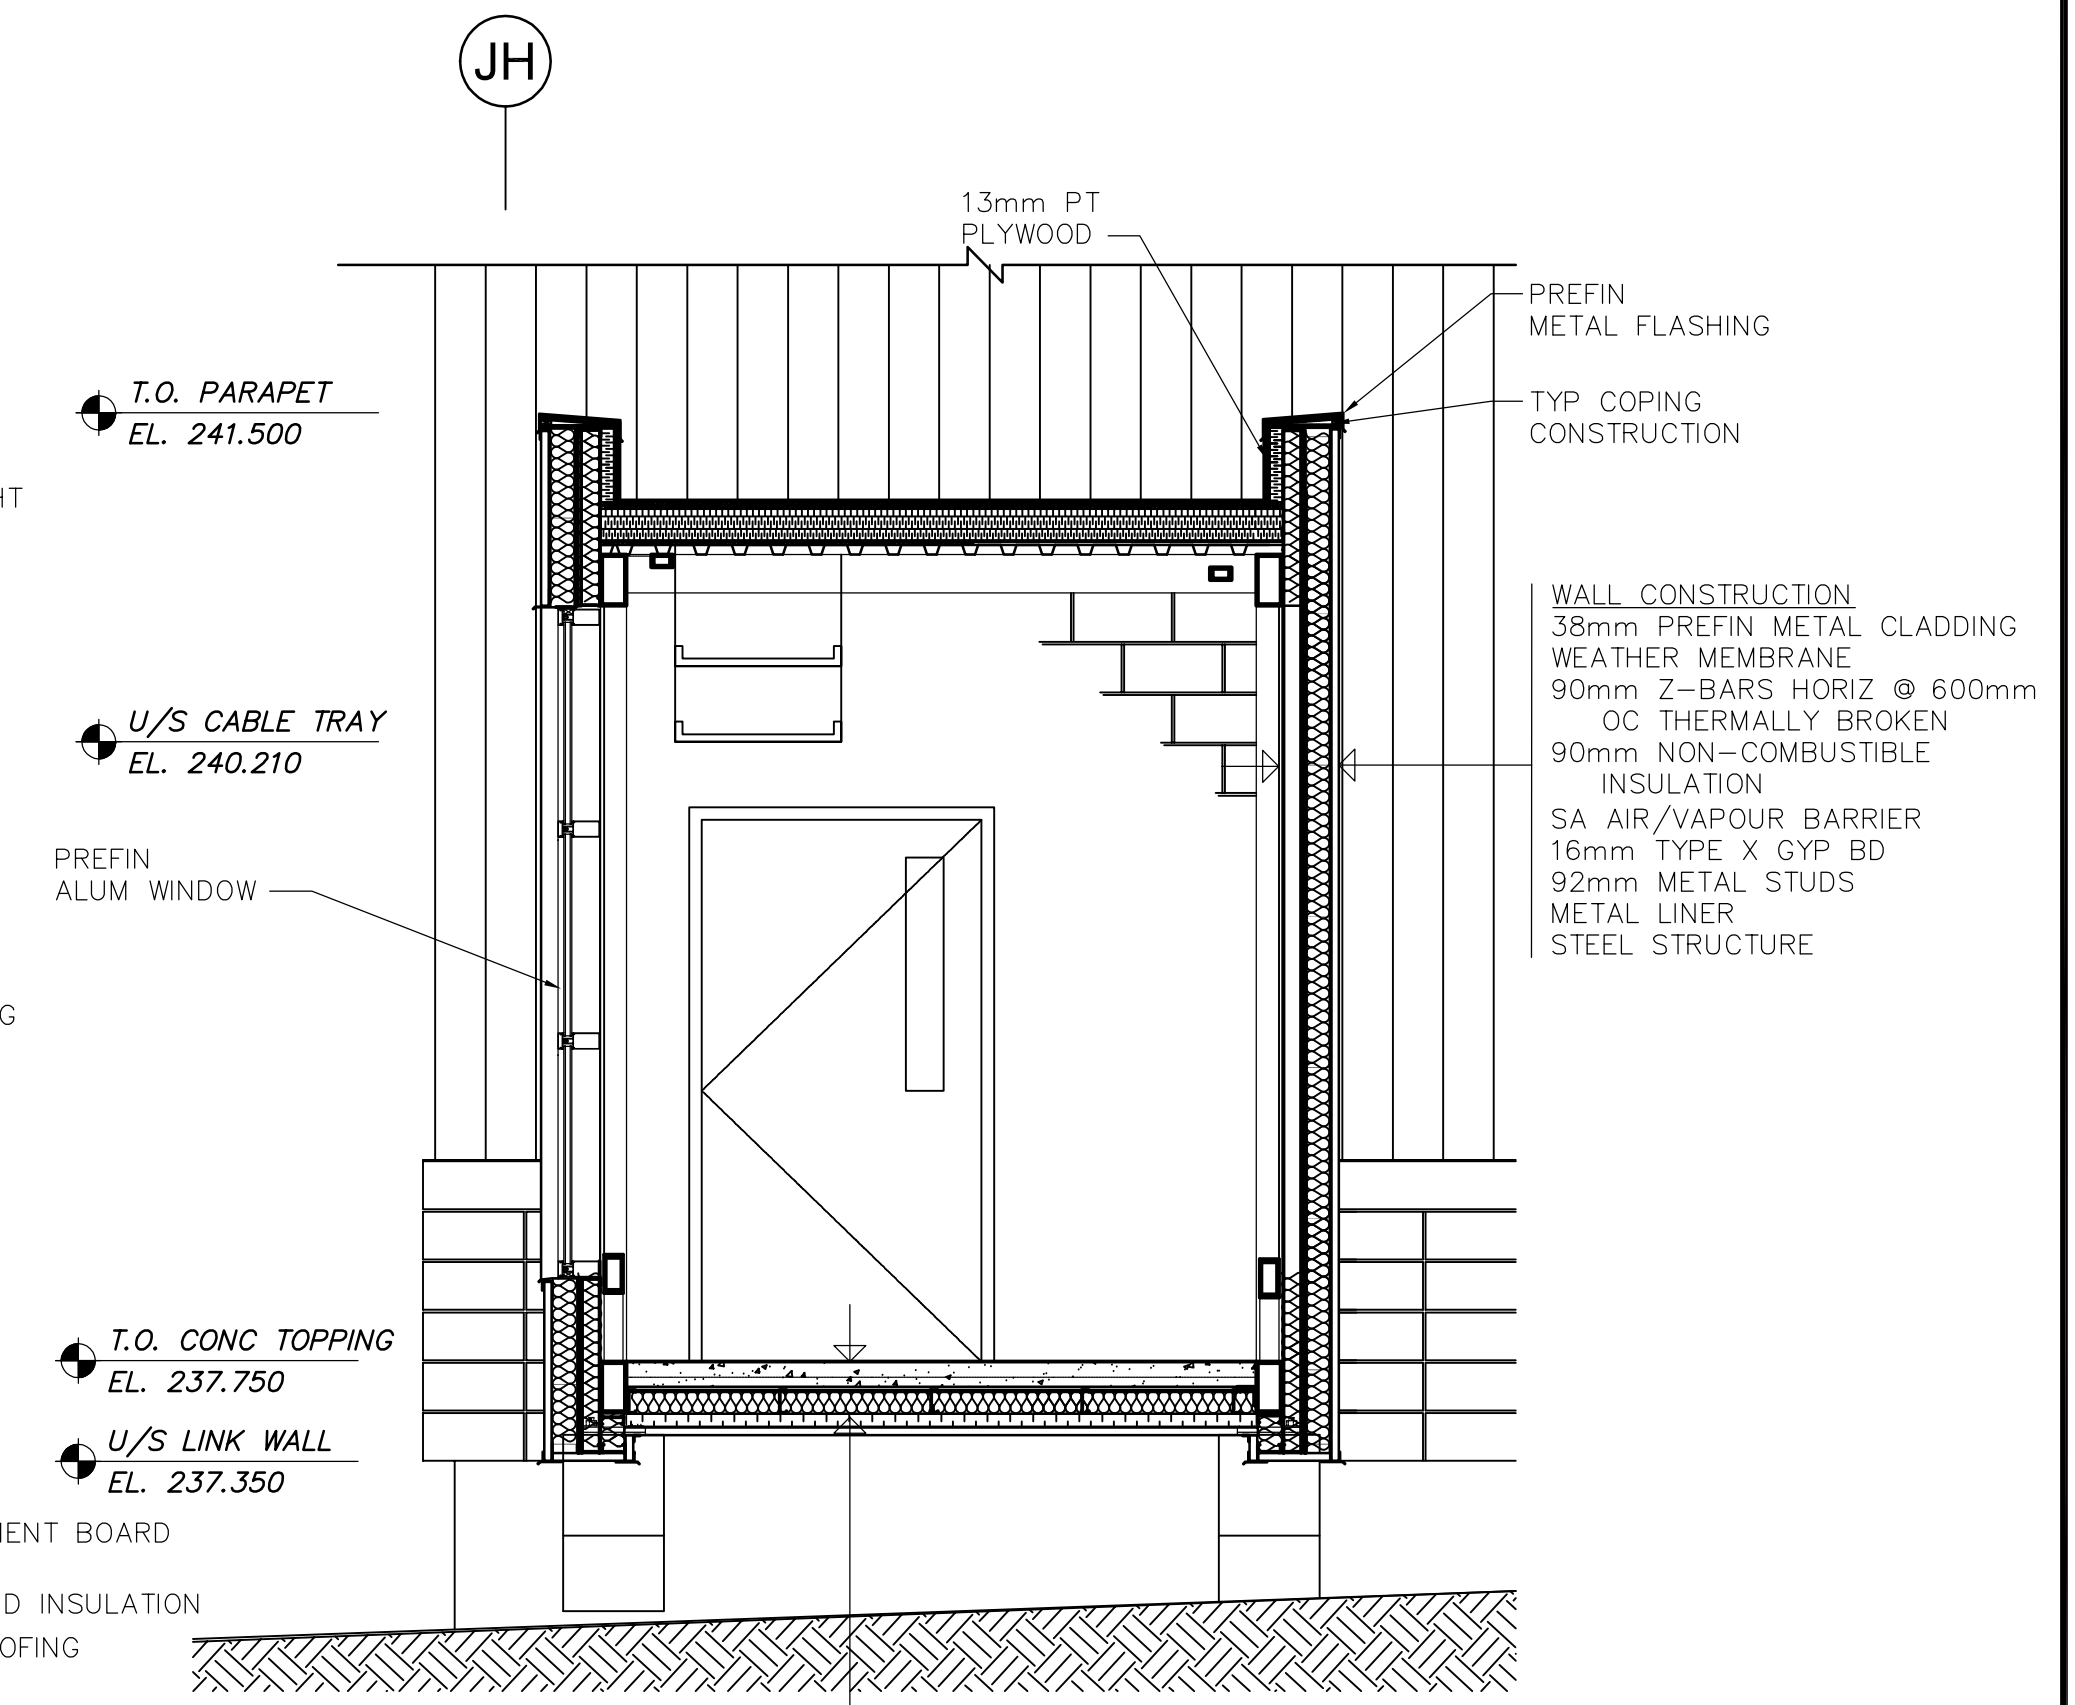

3 SECTION B  
WJ-B0403 1:30



NO.	REVISIONS	DATE	BY
03	792-2006 ADDENDUM 4	07/04/05	AL
02	792-2006 ADDENDUM 3	07/03/30	AL
01	792-2006 ADDENDUM 2	07/03/20	AL
00	ISSUED FOR TENDER	07/01/31	AL

DESIGNED BY	NC	CHECKED BY	LK
DRAWN BY	AL	APPROVED BY	AHL
SCALE:	AS SHOWN	RELEASED FOR CONSTRUCTION BY:	R. SOROKOWSKI
DATE	2006/10/02	DATE	2007/01/31

ENGINEER'S SEAL  
ORIGINAL SIGNED BY  
NEIL COOPER  
2007/01/31  
CONSULTANT DRAWING NO.  
WJ-B0403

**THE CITY OF WINNIPEG**  
WATER AND WASTE DEPARTMENT  
ENGINEERING DIVISION

WATER TREATMENT PLANT  
SODIUM HYPOCHLORITE GENERATION BUILDING  
SODIUM HYPOCHLORITE AND CHEMICAL STORAGE BUILDING

ARCHITECTURAL  
BUILDING LINK DETAILED PLAN & SECTIONS

CITY FILE NUMBER  
SHEET OF  
CITY DRAWING NUMBER  
1-0601J-A-B0403-001-030