


SECOND FLOOR POWER PLAN
1:75

DRAWING NOTES	
1	75x600 EQUIPMENT GROUND BAR. CONNECT CONDUCTORS TO EQUIPMENT GROUND BAR USING 2 HOLE LUGS
2	CONTROL WIRING FROM OVERHEAD DOOR OPENER TO MOTOR

GENERAL NOTES	
1.	COORDINATE WITH OTHER TRADES SO AS TO PREVENT CONFLICTS.
2.	ALL DUCTWORK SHALL BE SUPPORTED AND SUSPENDED AS PER SPECIFICATIONS AND LOCAL CODES (SEE DETAILS).

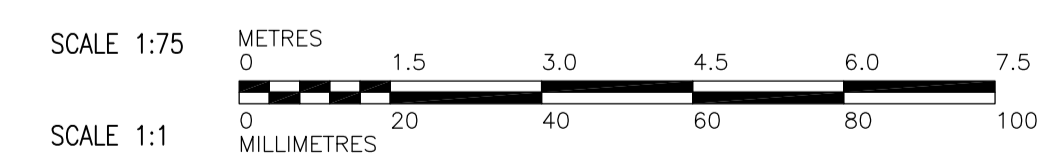

<p>APEGM Certificate of Authorization Earth Tech Canada Inc. No. 730 Expiry: April 30, 2007</p>	B.M. ELEV.	<p>Frederickson Cooper ARCHITECTS</p>	<p>EarthTech A Tyco International Ltd. Company</p>	ENGINEER'S SEAL	<p>THE CITY OF WINNIPEG WATER AND WASTE DEPARTMENT ENGINEERING DIVISION</p>	
	DESIGNED BY: BLM			CHECKED BY: PS		ORIGINAL SIGNED BY: P. STRYK
	DRAWN BY: ERC			APPROVED BY: AHL		2007/01/31
	SCALE: 1:75			RELEASED FOR CONSTRUCTION BY: R. SOROKOWSKI		CONSULTANT DRAWING NO. WS-E0122
NO. REVISIONS	DATE BY	DATE	DATE		<p>WATER TREATMENT PLANT BULK CHEMICAL STORAGE SODIUM HYPOCHLORITE AND CHEMICAL STORAGE BUILDING</p> <p>ELECTRICAL SECOND FLOOR POWER PLAN</p>	<p>CITY FILE NUMBER</p> <p>SHEET OF</p> <p>CITY DRAWING NUMBER 1-0601S-A-E0122-001-010</p>