


WALL TYPE

- 1 190mm CMU - 1 HR FRR
- 2 190mm CMU

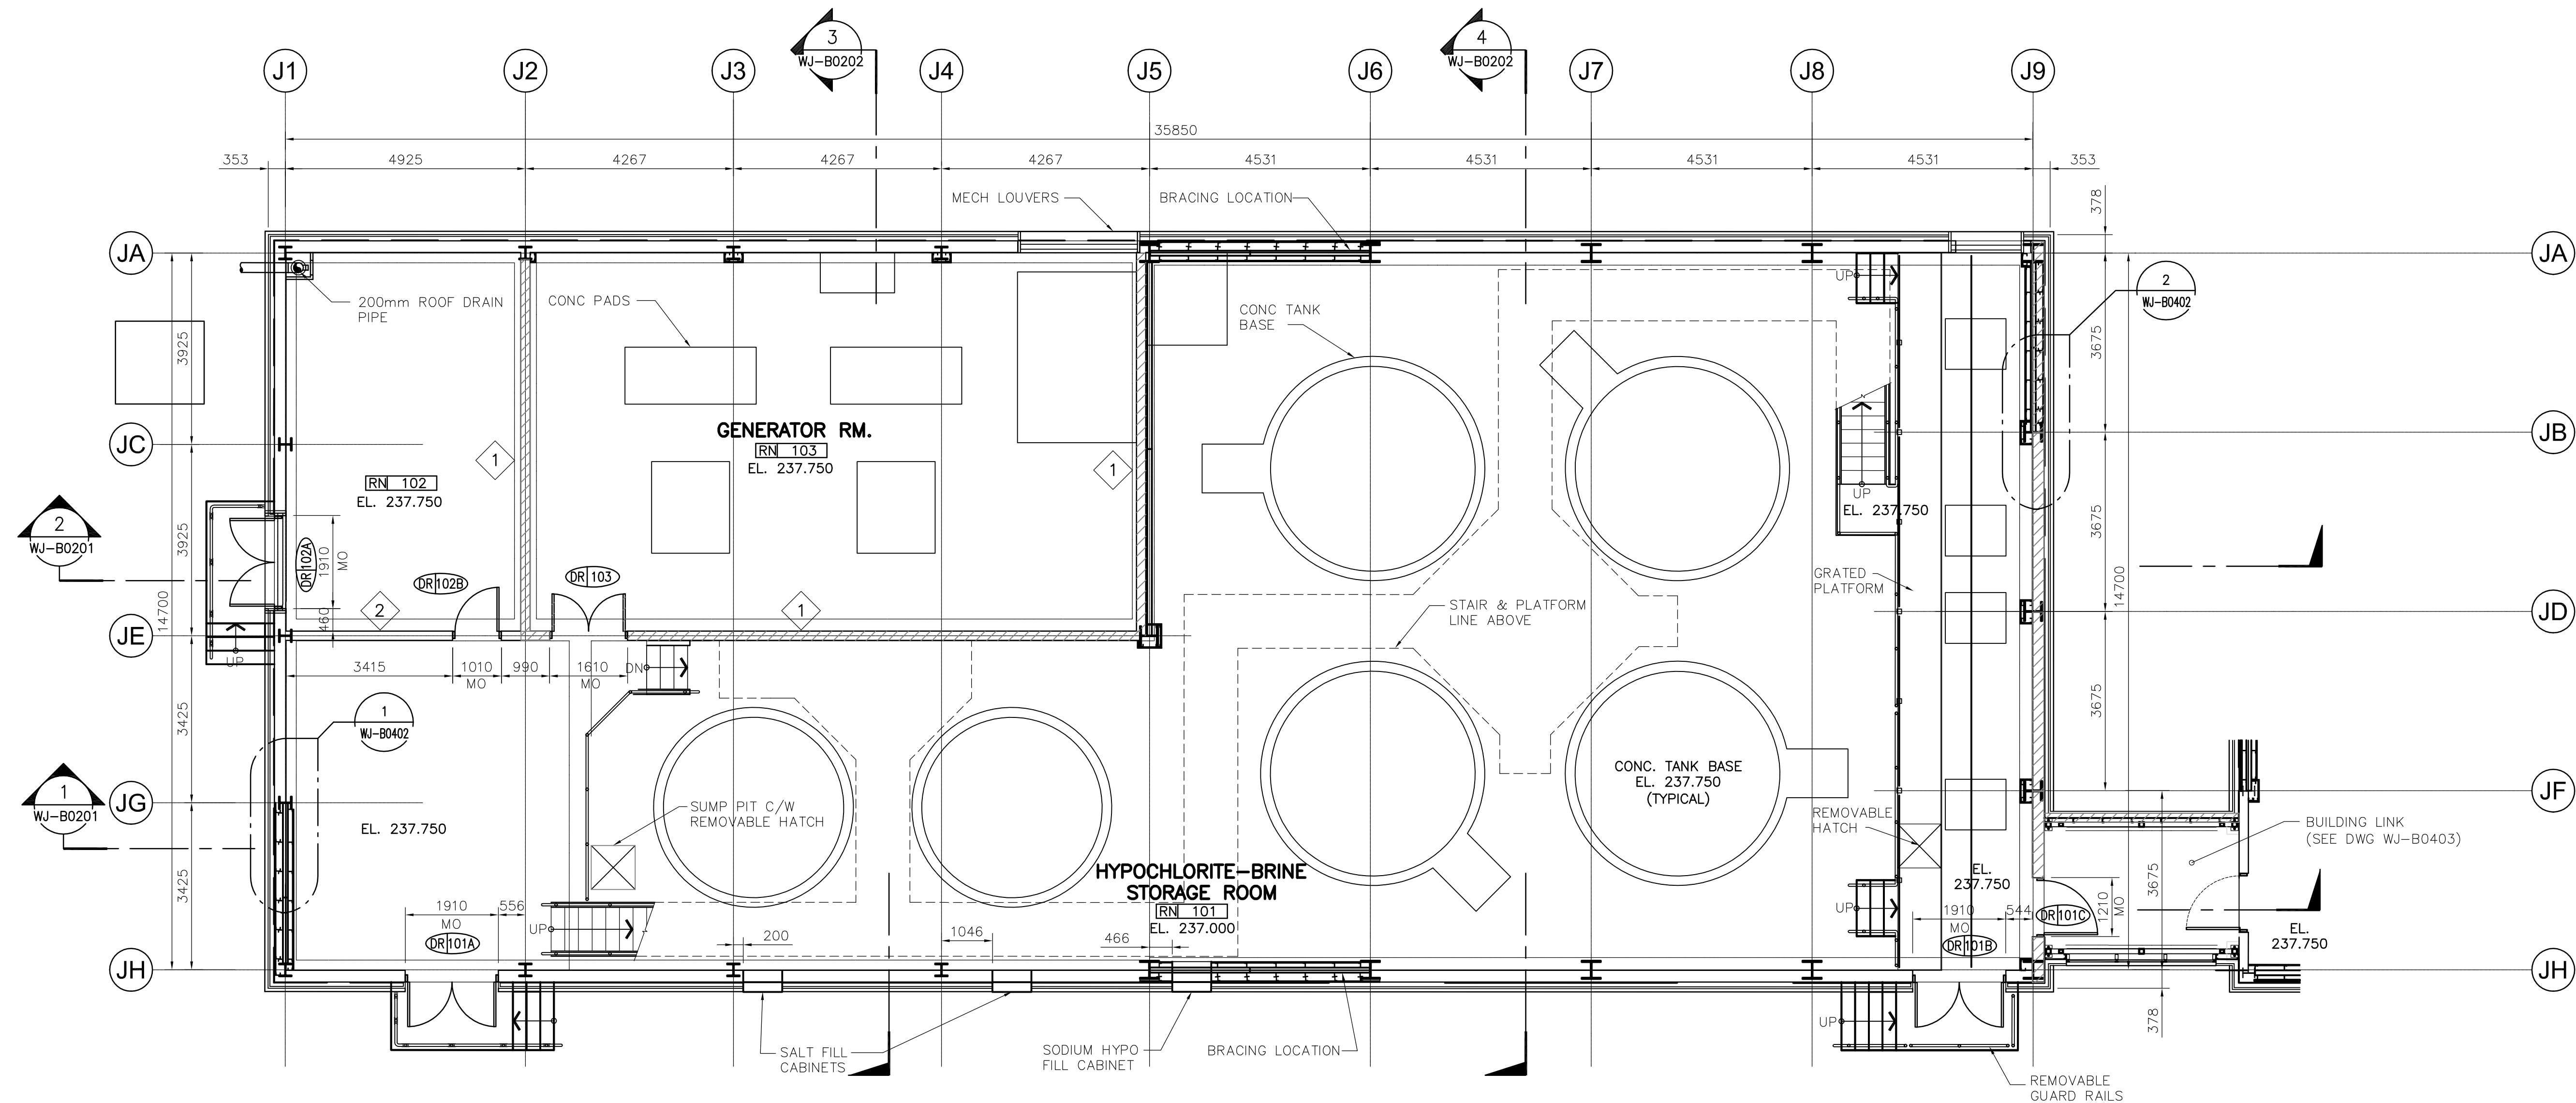

1 MAIN FLOOR PLAN  
WJ-B0110 1:75



B.M. ELEV.			
00	ISSUED FOR TENDER	07/01/31	AL
NO.	REVISIONS	DATE	BY

Frederickson Cooper ARCHITECTS			
DESIGNED BY	NC	CHECKED BY	LK
DRAWN BY	AL	APPROVED BY	AHL
SCALE:	AS SHOWN	RELEASED FOR CONSTRUCTION BY:	R. SOROKOWSKI
DATE	2006/10/02	DATE	2007/01/31

ENGINEER'S SEAL	
ORIGINAL SIGNED BY	NEIL COOPER
	2007/01/31
CONSULTANT DRAWING NO.	WJ-B0110

THE CITY OF WINNIPEG WATER AND WASTE DEPARTMENT ENGINEERING DIVISION	
WATER TREATMENT PLANT SODIUM HYPOCHLORITE GENERATION BUILDING SODIUM HYPOCHLORITE AND CHEMICAL STORAGE BUILDING	
ARCHITECTURAL MAIN FLOOR PLAN	CITY FILE NUMBER
	SHEET OF
	CITY DRAWING NUMBER
	1-0601J-A-B0110-001-000