



2 MAIN FLOOR REFLECTED CEILING PLAN
WJ-B0121 1:75

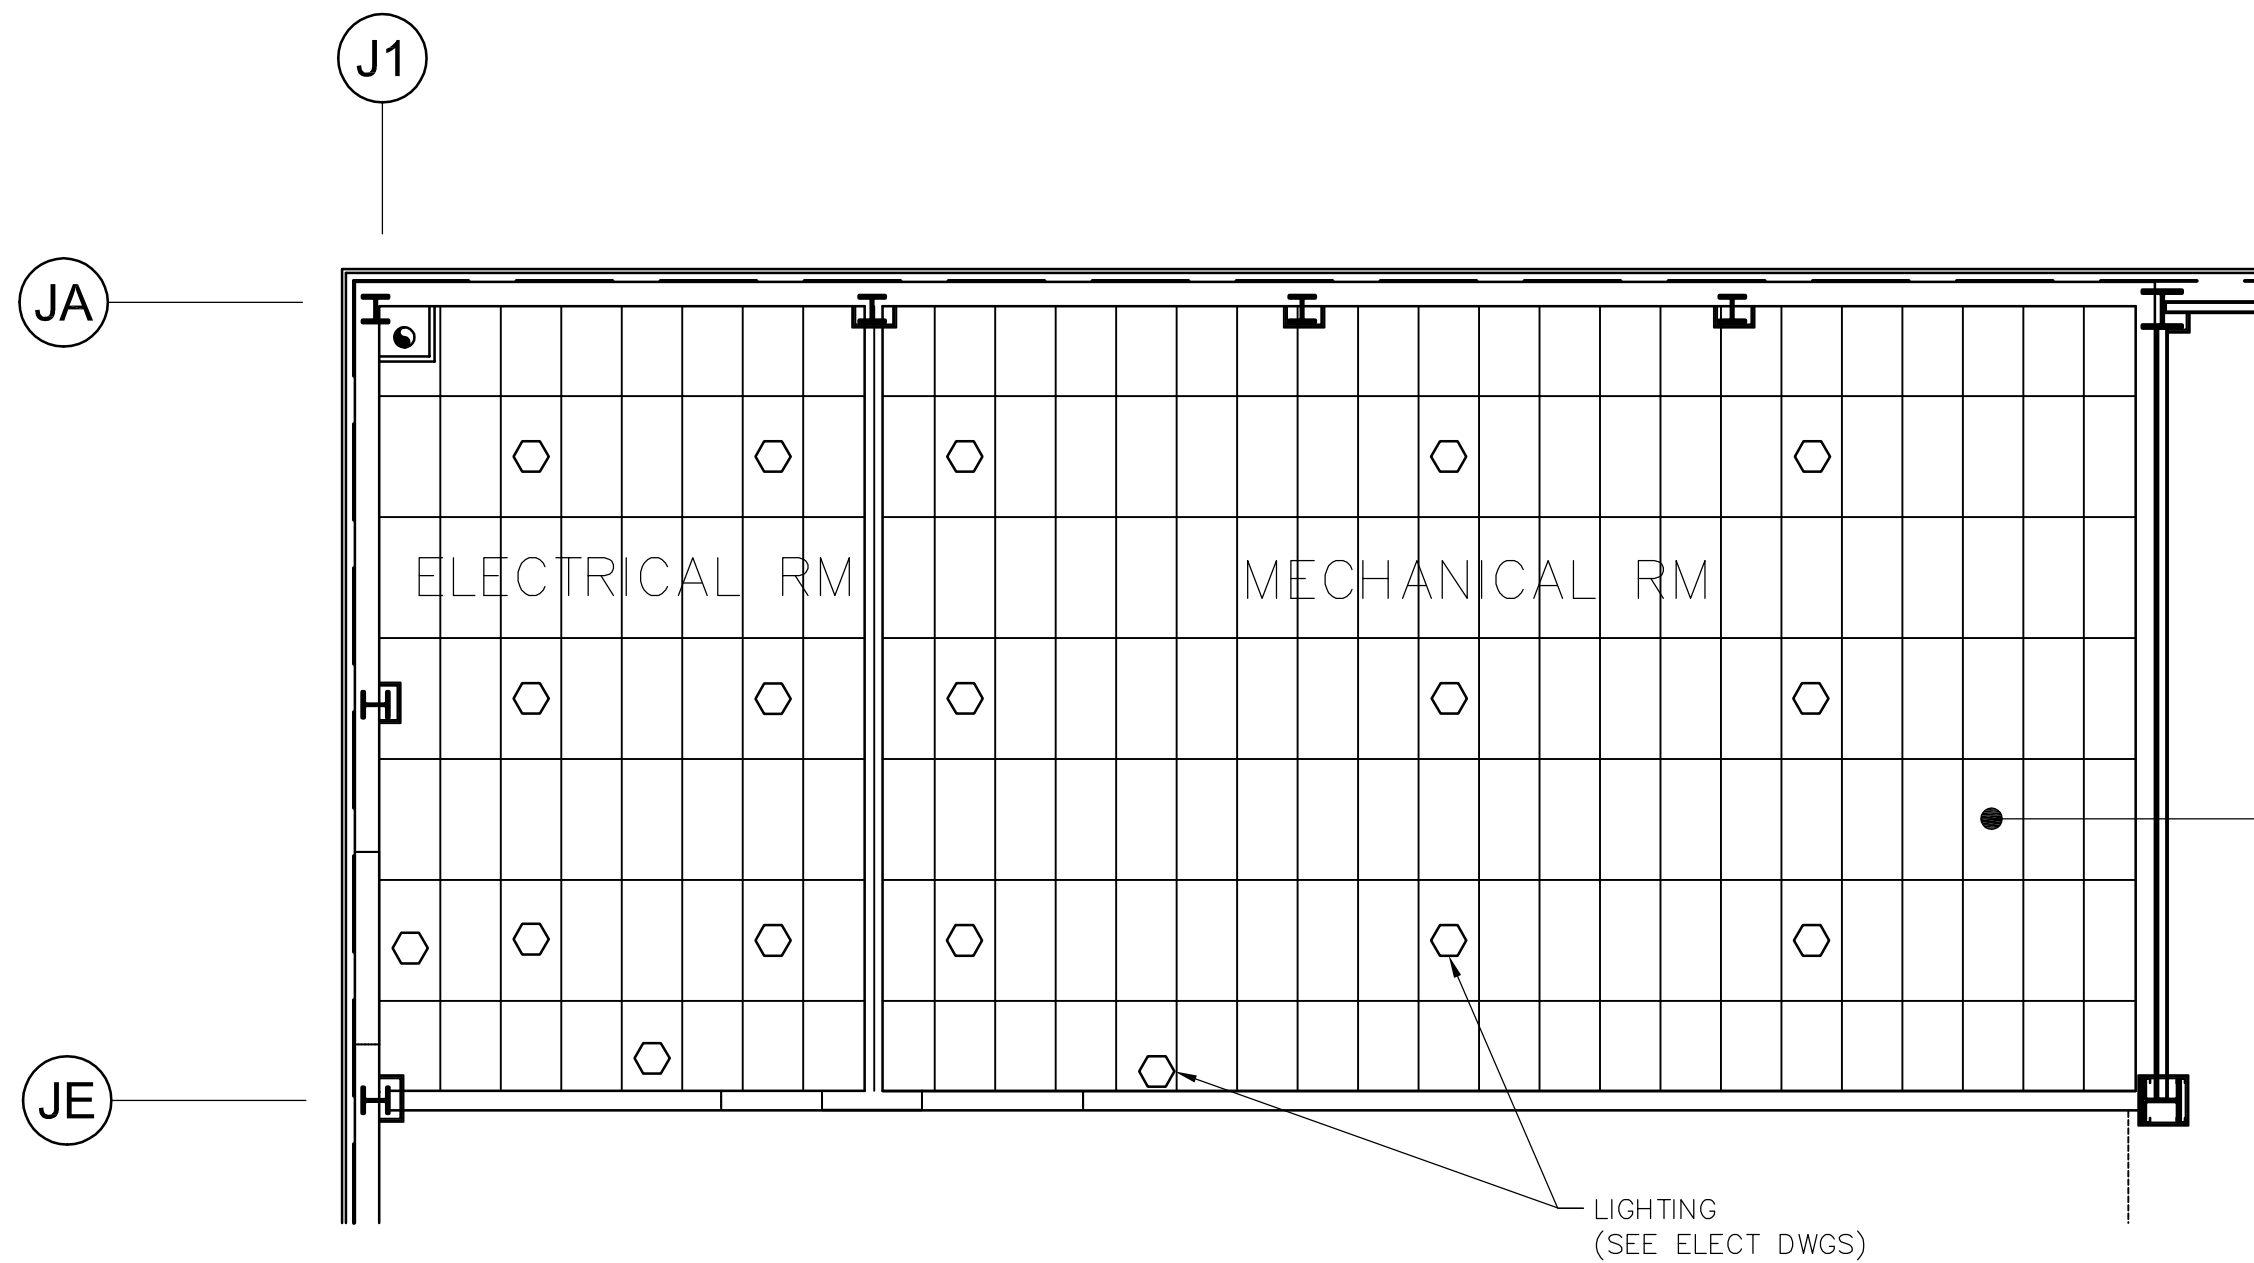

1 ELECT & MECH RM REFLECTED CEILING PLAN
WJ-B0121 1:75

600mm x 1200mm
ACOUSTICAL TILE (RATED)
C/W HOLD-DOWN CLIPS, PREFIN
METAL RUNNERS, GALV.
SUSPENSION WIRES AND ANCHORS.

LIGHTING
(SEE ELECT DWGS)

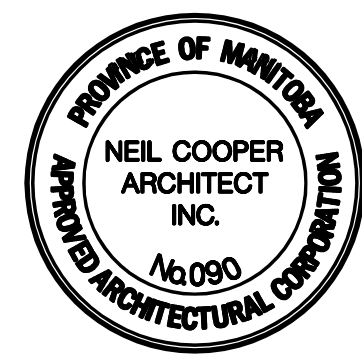

B.M. ELEV.	
00 ISSUED FOR TENDER	07/01/31 AL
NO. REVISIONS	DATE BY

CH2MHILL Frederickson Cooper ARCHITECTS	
DESIGNED BY NC	CHECKED BY LK
DRAWN BY AL	APPROVED BY AHL
SCALE: AS SHOWN	RELEASED FOR CONSTRUCTION BY: R. SOROKOWSKI
DATE 2006/10/02	DATE 2007/01/31

EarthTech A Tyco International Ltd. Company	
ENGINEER'S SEAL	
ORIGINAL SIGNED BY	
NEIL COOPER	
2007/01/31	
CONSULTANT DRAWING NO. WJ-B0121	

THE CITY OF WINNIPEG WATER AND WASTE DEPARTMENT ENGINEERING DIVISION	
WATER TREATMENT PLANT SODIUM HYPOCHLORITE GENERATION BUILDING SODIUM HYPOCHLORITE AND CHEMICAL STORAGE BUILDING	
ARCHITECTURAL REFLECTED CEILING PLANS	CITY FILE NUMBER
	SHEET OF
	CITY DRAWING NUMBER
	1-0601J-A-B0121-001-000