


ROOF POWER PLAN
1:75

DRAWING NOTES	
①	xxx
②	
③	
④	
⑤	

GENERAL NOTES	
1.	COORDINATE WITH OTHER TRADES TO PREVENT CONFLICTS.
2.	

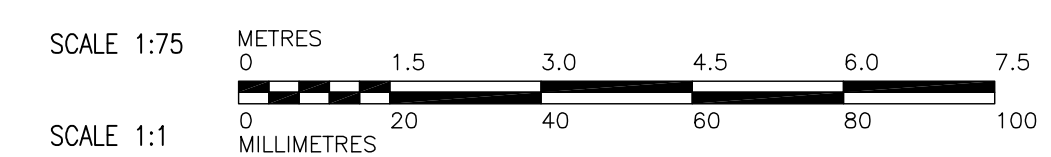

 Certificate of Authorization Earth Tech Canada Inc. No. 730 Expiry: April 30, 2007	B.M. ELEV.	 Frederickson Cooper ARCHITECTS	 A Tyco International Ltd. Company	ENGINEER'S SEAL	 THE CITY OF WINNIPEG WATER AND WASTE DEPARTMENT ENGINEERING DIVISION		
				DESIGNED BY: BLM		CHECKED BY: PS	ORIGINAL SIGNED BY: P. STRYK
				DRAWN BY: ERC		APPROVED BY: AHL	2007/01/31
				SCALE: 1:75		RELEASED FOR CONSTRUCTION BY: R. SOROKOWSKI	CONSULTANT DRAWING NO. WS-E0141
	00 ISSUED FOR TENDER 07/01/31 ERC	DATE 2007/01/30	DATE 2007/01/31		WATER TREATMENT PLANT BULK CHEMICAL STORAGE SODIUM HYPOCHLORITE AND CHEMICAL STORAGE BUILDING		
	NO. REVISIONS	DATE	BY	DATE	ELECTRICAL ROOF POWER PLAN		
					CITY FILE NUMBER SHEET OF CITY DRAWING NUMBER 1-0601S-A-E0141-001-000		