


**ROOF PLAN**  
1:75

**GENERAL NOTES**

1. COORDINATE WITH OTHER TRADES TO PREVENT CONFLICTS.
2. SPACE PERIMETER AIR TERMINALS EVENLY AROUND PARAPET.
3. INSTALLATION SHALL CONFORM TO CLASS I AS SPECIFIED IN LPI-175 AND CSA-B72-M87.
4. SECONDARY BONDING NOT INDICATED. BOND ALL ROOF MOUNTED MECHANICAL EQUIPMENT AND VENTS, FLASHING, DRAINS, LADDERS, ETC. TO MEET CLASS I REQUIREMENTS.

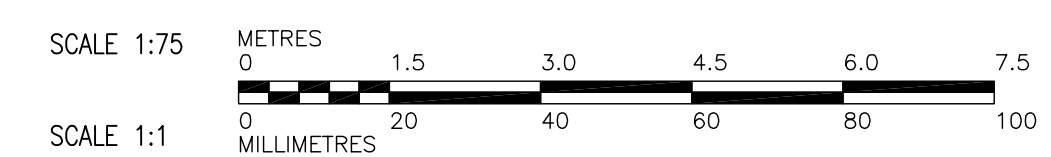

 <b>APEGM</b> Certificate of Authorization Earth Tech Canada Inc. No. 730 Expiry: April 30, 2007	B.M. ELEV.	 <b>Frederickson Cooper</b> ARCHITECTS	 EarthTech A Tyco International Ltd. Company	ENGINEER'S SEAL  ORIGINAL SIGNED BY P. STRYK 2007/01/31	 <b>THE CITY OF WINNIPEG</b> WATER AND WASTE DEPARTMENT ENGINEERING DIVISION			
	DESIGNED BY: BLM					CHECKED BY: PS	WATER TREATMENT PLANT BULK CHEMICAL STORAGE SODIUM HYPOCHLORITE AND CHEMICAL STORAGE BUILDING	CITY FILE NUMBER SHEET OF
	DRAWN BY: ERC					APPROVED BY: AHL	ELECTRICAL ROOF PLAN LIGHTNING PROTECTION	CITY DRAWING NUMBER 1-0601S-A-E0142-001-000
SCALE: 1:75	RELEASED FOR CONSTRUCTION BY: R. SOROKOWSKI	CONSULTANT DRAWING NO. WS-E0142						
00 ISSUED FOR TENDER 07/01/31 ERC	NO. REVISIONS DATE BY DATE 2007/01/30 DATE 2007/01/31							