


1 PARTIAL MECHANICAL ROOM PLUMBING PLAN
1:50

DRAWING NOTES

- 1 10 PSIG (69kPa) 5 PSIG (34.5kPa) PRV OUTSIDE BUILDING. VENT REGULATOR ABOVE ROOF ELEVATION.
- 2 PROVIDE 65mm ISOLATION VALVE ABOVE GRADE BEFORE BUILDING ENTRY.
- 3 CONTINUATION OF 65mm NATURAL GAS PIPING DRAWING NUMBER WH-C0210.
- 4 65mm NATURAL GAS REGULATOR VENT UP TO ROOF.
- 5 DOMESTIC COLD WATER AND DOMESTIC HOT WATER UP TO UPPER LEVEL WASHROOM.
- 6 RPZ BFP VALVE.
- 7 40 TEMPERED WATER FROM MIXING VALVE UP TO RAIL CAR EMERGENCY SHOWER
- 8 15mm PIPE TO EACH TRAP CONNECTION FROM TRAP PRIMING STATION.
- 9 20 BALANCING VALVE IN HOT WATER RECIRC. SYSTEM.
- 10 STEAM BOILER NATURAL GAS REGULATOR.
- 11 NATURAL GAS REGULATOR (5 PSIG/34.5kPa TO 8" w.c./2 kPa).

GENERAL NOTES

1. MECHANICAL CONTRACTOR SHALL COORDINATE WITH OTHER TRADES. REPORT DISCREPANCIES TO MECHANICAL ENGINEER.
2. MECHANICAL CONTRACTOR SHALL INSULATE ALL DOMESTIC COLD, HOT, RECERC. TEMPERED AND PROCESS HOT WATER LINES.

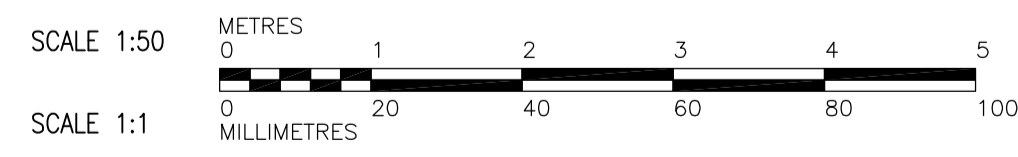

 Certificate of Authorization Earth Tech Canada Inc. No. 730 Expiry: April 30, 2007	B.M. ELEV.	 Frederickson Cooper ARCHITECTS	 A Type International Ltd. Company	ENGINEER'S SEAL	 THE CITY OF WINNIPEG WATER AND WASTE DEPARTMENT ENGINEERING DIVISION		
				DESIGNED BY: DJP		CHECKED BY: PVL/AMA	ORIGINAL SIGNED BY: A. M. AFTANAS
				DRAWN BY: DJP		APPROVED BY: AHL	2007/01/31
				SCALE: 1:75		RELEASED FOR CONSTRUCTION BY: R. SOROKOWSKI	CONSULTANT DRAWING NO. WS-H0115
00 ISSUED FOR TENDER 07/01/31 DJP	NO. REVISIONS DATE BY DATE	DATE 2007/01/31		CITY FILE NUMBER	SHEET OF		
				CITY DRAWING NUMBER	1-0601S-A-H0115-001-000		