


NOTES:
1. SEE STRUCTURAL DRAWINGS FOR PIPING TRENCH DETAILS.

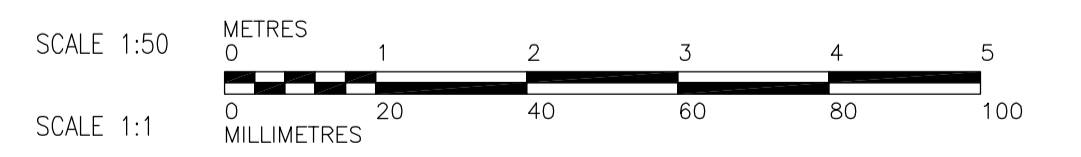

 APEGM Certificate of Authorization Earth Tech Canada Inc. No. 730 Expiry: April 30, 2007	B.M. ELEV.	 Frederickson Cooper ARCHITECTS	 A Tech International Ltd. Company	ENGINEER'S SEAL	 THE CITY OF WINNIPEG WATER AND WASTE DEPARTMENT ENGINEERING DIVISION WATER TREATMENT PLANT BULK CHEMICAL BUILDING SODIUM HYPOCHLORITE AND CHEMICAL STORAGE BUILDING PROCESS MECHANICAL GROUND FLOOR PLAN	CITY FILE NUMBER	
				DESIGNED BY SBW		CHECKED BY SRB	ORIGINAL SIGNED BY
		DRAWN BY JBC	APPROVED BY AHL	S.B. WILLIAMSON		2007/01/31	CITY DRAWING NUMBER
		SCALE: 1:50	RELEASED FOR CONSTRUCTION BY: R. SOROKOWSKI	CONSULTANT DRAWING NO. WS-M0111		1-0601S-A-M0111-001-000	
	00 ISSUED FOR TENDER 07/01/31 JBC	DATE 2006/03/15	DATE 2007/01/31				