



CRAWLSPACE FLOOR PLAN
1:100

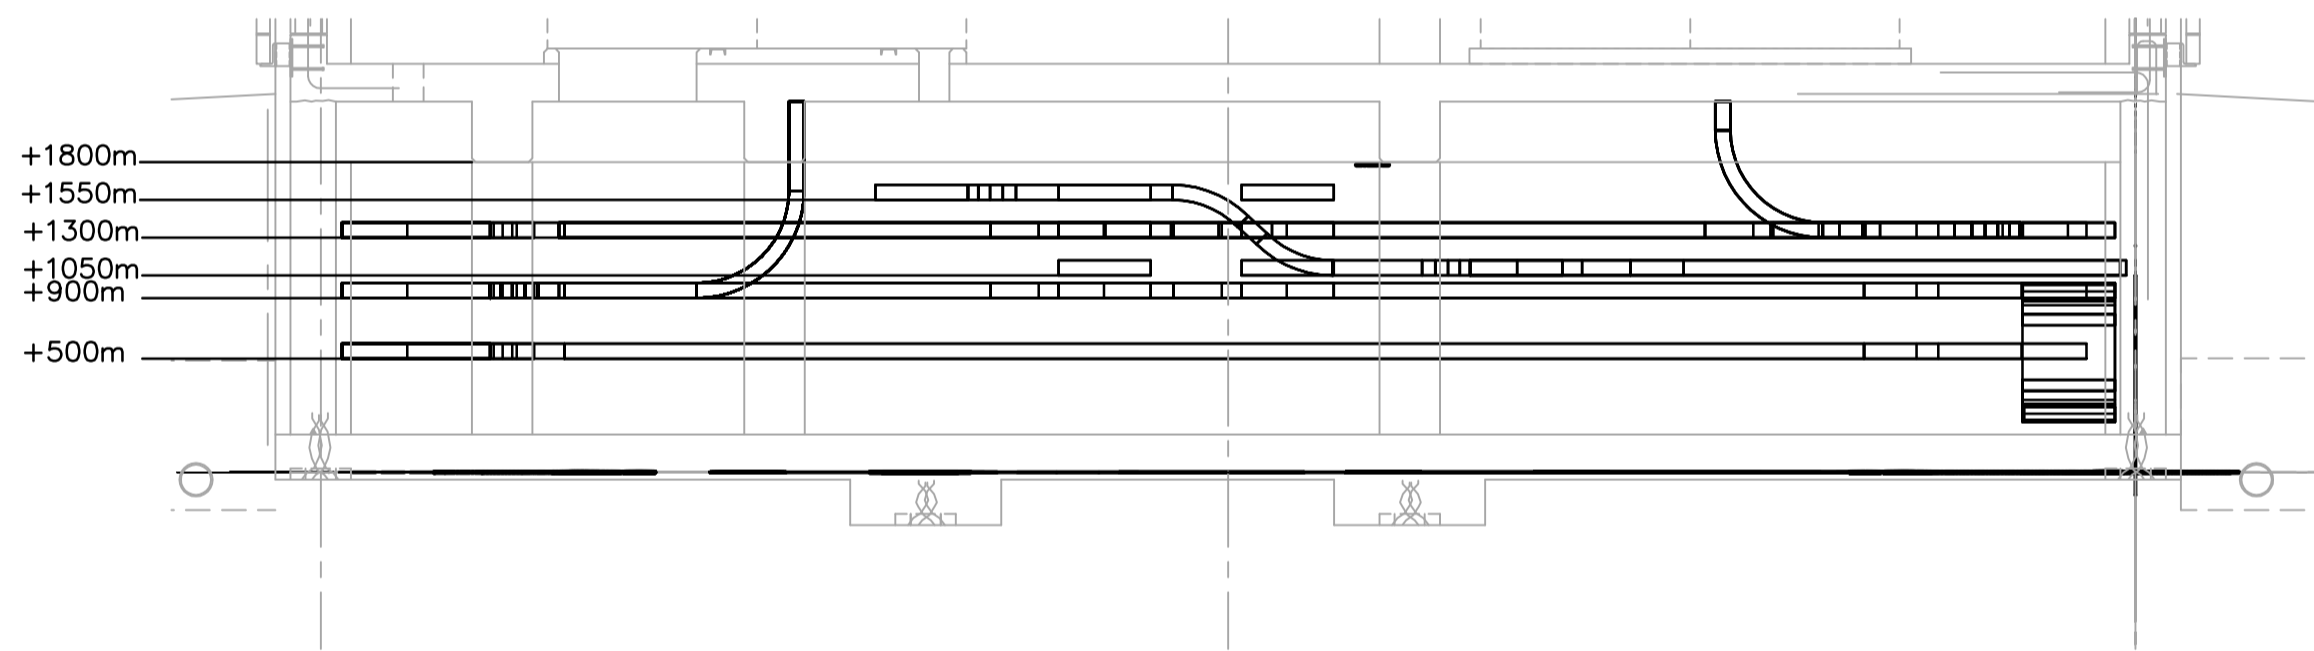

A SECTION
WG-E0102 1:50

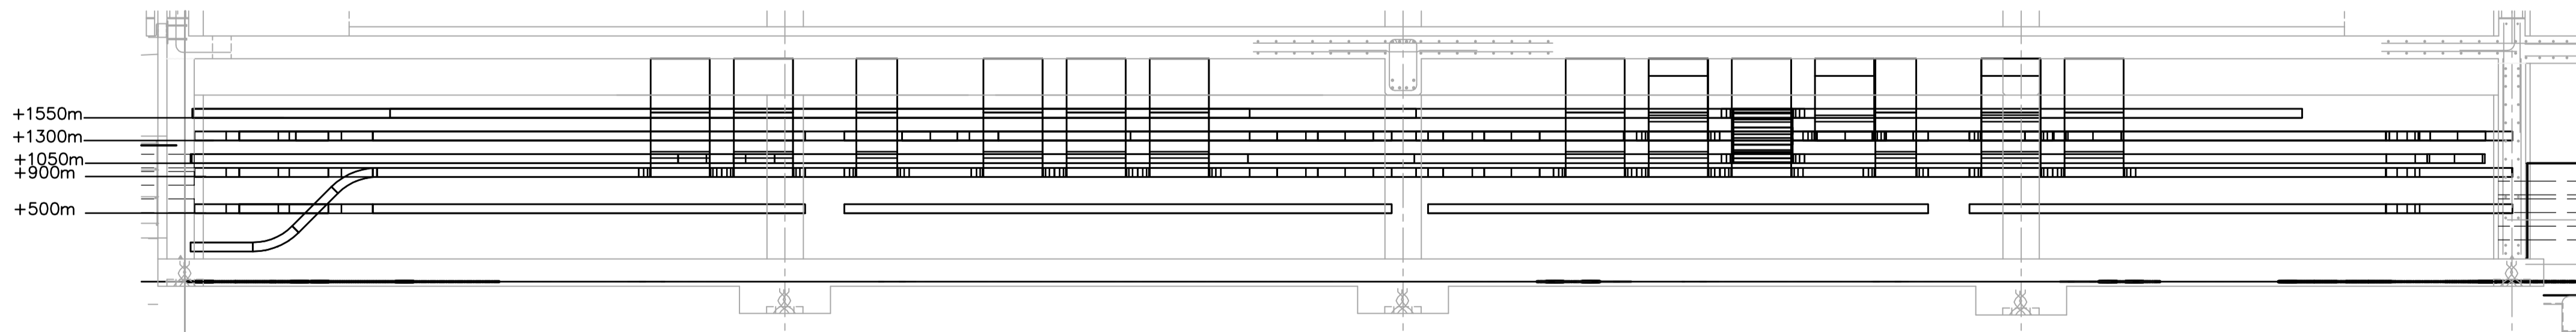

B SECTION
WG-E0102 1:50

DRAWING NOTES

- 1 REFER TO SHOP DRAWINGS OF CITY SUPPLIED EQUIPMENT SPECIFIED IN D2 FOR CABLE REQUIREMENTS. TECK CABLES SHALL BE USED IN PLACE OF METALLIC CONDUITS.
- 2 CABLES TO BULK CHEMICAL BUILDING INSTALLED AND TERMINATED IN HIGH VOLTAGE SWITCH GEAR UNDER BID OPPORTUNITY 792-2006
- 3 DUCT BANK TO BULK CHEMICAL BUILDING SUPPLIED AND INSTALLED UNDER BID OPPORTUNITY 792-2006 TO CONTRACT LIMIT AS SHOWN ON DRAWING WS-E0001.

| | | | | | | | | | | |
|---|---------------|------|----|------|---------------------------------------|---------------------------------------|------------------|---|---|---------------------------------|
| Certificate of Authorization Earth Tech Canada Inc. No. 730 Expiry: April 30, 2007 | B.M. ELEV. | | | | Frederickson Cooper ARCHITECTS | A Tyco International Ltd. Company | ENGINEER'S SEAL | THE CITY OF WINNIPEG WATER AND WASTE DEPARTMENT ENGINEERING DIVISION | | |
| | | | | | | | DESIGNED BY: BLM | | CHECKED BY: PS | ORIGINAL SIGNED BY: B.L. MOORE |
| | | | | | | | DRAWN BY: ERC | | APPROVED BY: AHL | 2006/08/30 |
| | | | | | | | SCALE: AS SHOWN | | RELEASED FOR CONSTRUCTION BY: R. SOROKOWSKI | CONSULTANT DRAWING NO. WG-E0102 |
| | NO. REVISIONS | DATE | BY | DATE | 2006/06/13 | DATE | 2006/08/30 | WATER TREATMENT PLANT STANDBY POWER GENERATOR GENERATOR BUILDING | CITY FILE NUMBER | |
| | | | | | | | | ELECTRICAL CRAWLSPACE POWER PLAN AND SECTIONS | SHEET OF | |
| | | | | | | | | | CITY DRAWING NUMBER | |
| | | | | | | | | | 1-0601G-A-E0102-001-050 | |