


ROOF PLAN  
1:50

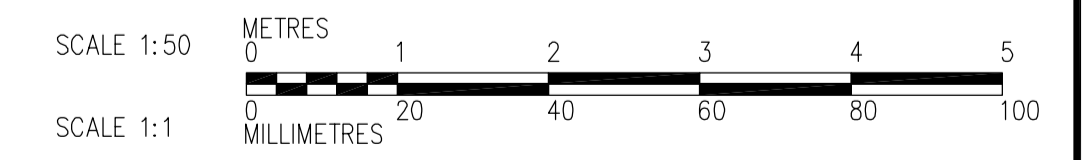

 <b>APEGN</b> Certificate of Authorization CH2M HILL Canada Ltd. No. 1441 Expiry: April 30, 2007	B.M. ELEV.	 Frederickson Cooper ARCHITECTS	 EarthTech A 100 International Ltd. Company	ENGINEER'S SEAL	 <b>THE CITY OF WINNIPEG</b> WATER AND WASTE DEPARTMENT ENGINEERING DIVISION	CITY FILE NUMBER
	DESIGNED BY LL DRAWN BY TL SCALE: 1:50			CHECKED BY JRL APPROVED BY AHL RELEASED FOR CONSTRUCTION BY: R. SOROKOWSKI		ORIGINAL SIGNED BY L.D. LLEWELLYN 2007/01/31
00 ISSUED FOR TENDER 07/01/31 LL NO. REVISIONS DATE BY	DATE 2006/08/29 DATE 2007/01/31	CONSULTANT DRAWING NO. WJ-E0144		ELECTRICAL SODIUM HYPOCHLORITE BUILDING LIGHTNING PROTECTION	CITY DRAWING NUMBER 1-0601J-A-E0144-001-000	