


GROUND FLOOR PLAN
1:50

- NOTE: 1. FOR HYDRONIC PIPE SIZES, REFER TO DRAWING WJ-H0505
 2. PROVIDE PRIMED TRAP FOR EACH FLOOR DRAIN, UNLESS PRIMED RUNNING TRAP INDICATED
 3. ALL FLOOR DRAIN ARE TO BE 75Ø UNLESS OTHERWISE INDICATED
 4. ALL BURIED DRAIN PIPING ARE TO BE ENCASED IN CONCRETE, SEE STRUCTURAL FOR ENCASEMENT DETAIL

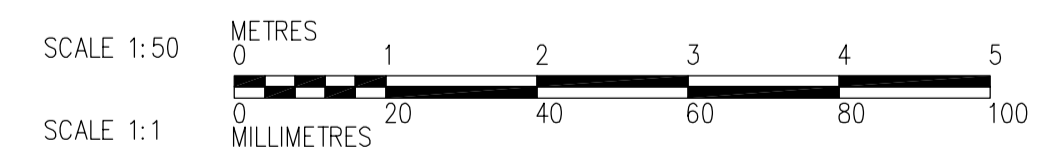

 Certificate of Authorization CH2M HILL Canada Ltd. No. 1441 Expiry: April 30, 2007	B.M. ELEV.	 Frederickson Cooper ARCHITECTS	 A 100 International Ltd. Company	ENGINEER'S SEAL	 THE CITY OF WINNIPEG WATER AND WASTE DEPARTMENT ENGINEERING DIVISION	WATER TREATMENT PLANT SODIUM HYPOCHLORITE BUILDING SODIUM HYPOCHLORITE AND CHEMICAL STORAGE BUILDINGS	CITY FILE NUMBER	
	DESIGNED BY TT			CHECKED BY DKC			ORIGINAL SIGNED BY D.K. CUDDINGTON	SHEET OF
	DRAWN BY KF			APPROVED BY AHL			2007/01/31	CITY DRAWING NUMBER
	SCALE: 1:50			RELEASED FOR CONSTRUCTION BY: R. SOROKOWSKI			CONSULTANT DRAWING NO. WJ-H0111	1-0601J-A-H0111-001-000
00 ISSUED FOR TENDER 07/01/31 TT	DATE 2006/10/10	DATE 2007/01/31						