


MAIN FLOOR LIGHTING PLAN
1:75

DRAWING NOTES	
1	MOUNT ON UNDERSIDE OF CABLETRAY
2	WALL MOUNTED LUMINAIRE

GENERAL NOTES	
1. COORDINATE WITH OTHER TRADES TO PREVENT CONFLICTS.	

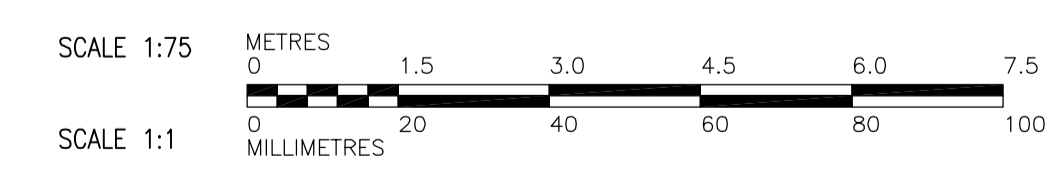

APEGM
Certificate of Authorization
Earth Tech Canada Inc.
No. 730 Expiry: April 30, 2007

NO.	REVISIONS	DATE	BY
00	ISSUED FOR TENDER	07/01/31	ERC

CH2M HILL
Frederickson Cooper ARCHITECTS

EarthTech
A Tech International Ltd. Company

DESIGNED BY: BLM	CHECKED BY:
DRAWN BY: ERC	APPROVED BY: AHL
SCALE: 1:75	RELEASED FOR CONSTRUCTION BY: R. SOROKOWSKI
DATE: 2007/01/30	DATE: 2007/01/31

ENGINEER'S SEAL
ORIGINAL SIGNED BY: P. STRYK
2007/01/31
CONSULTANT DRAWING NO. WS-E0111

THE CITY OF WINNIPEG
WATER AND WASTE DEPARTMENT
ENGINEERING DIVISION

WATER TREATMENT PLANT
BULK CHEMICAL STORAGE
SODIUM HYPOCHLORITE AND CHEMICAL STORAGE BUILDING

ELECTRICAL
MAIN FLOOR LIGHTING PLAN
AND SCHEDULE

CITY FILE NUMBER	
SHEET OF	
CITY DRAWING NUMBER	1-0601S-A-E0111-001-000