


DWG 1-0601S-F-E0503-001
FROM SWGR #2A

DWG 1-0601S-F-E0503-001
FROM SWGR #2B

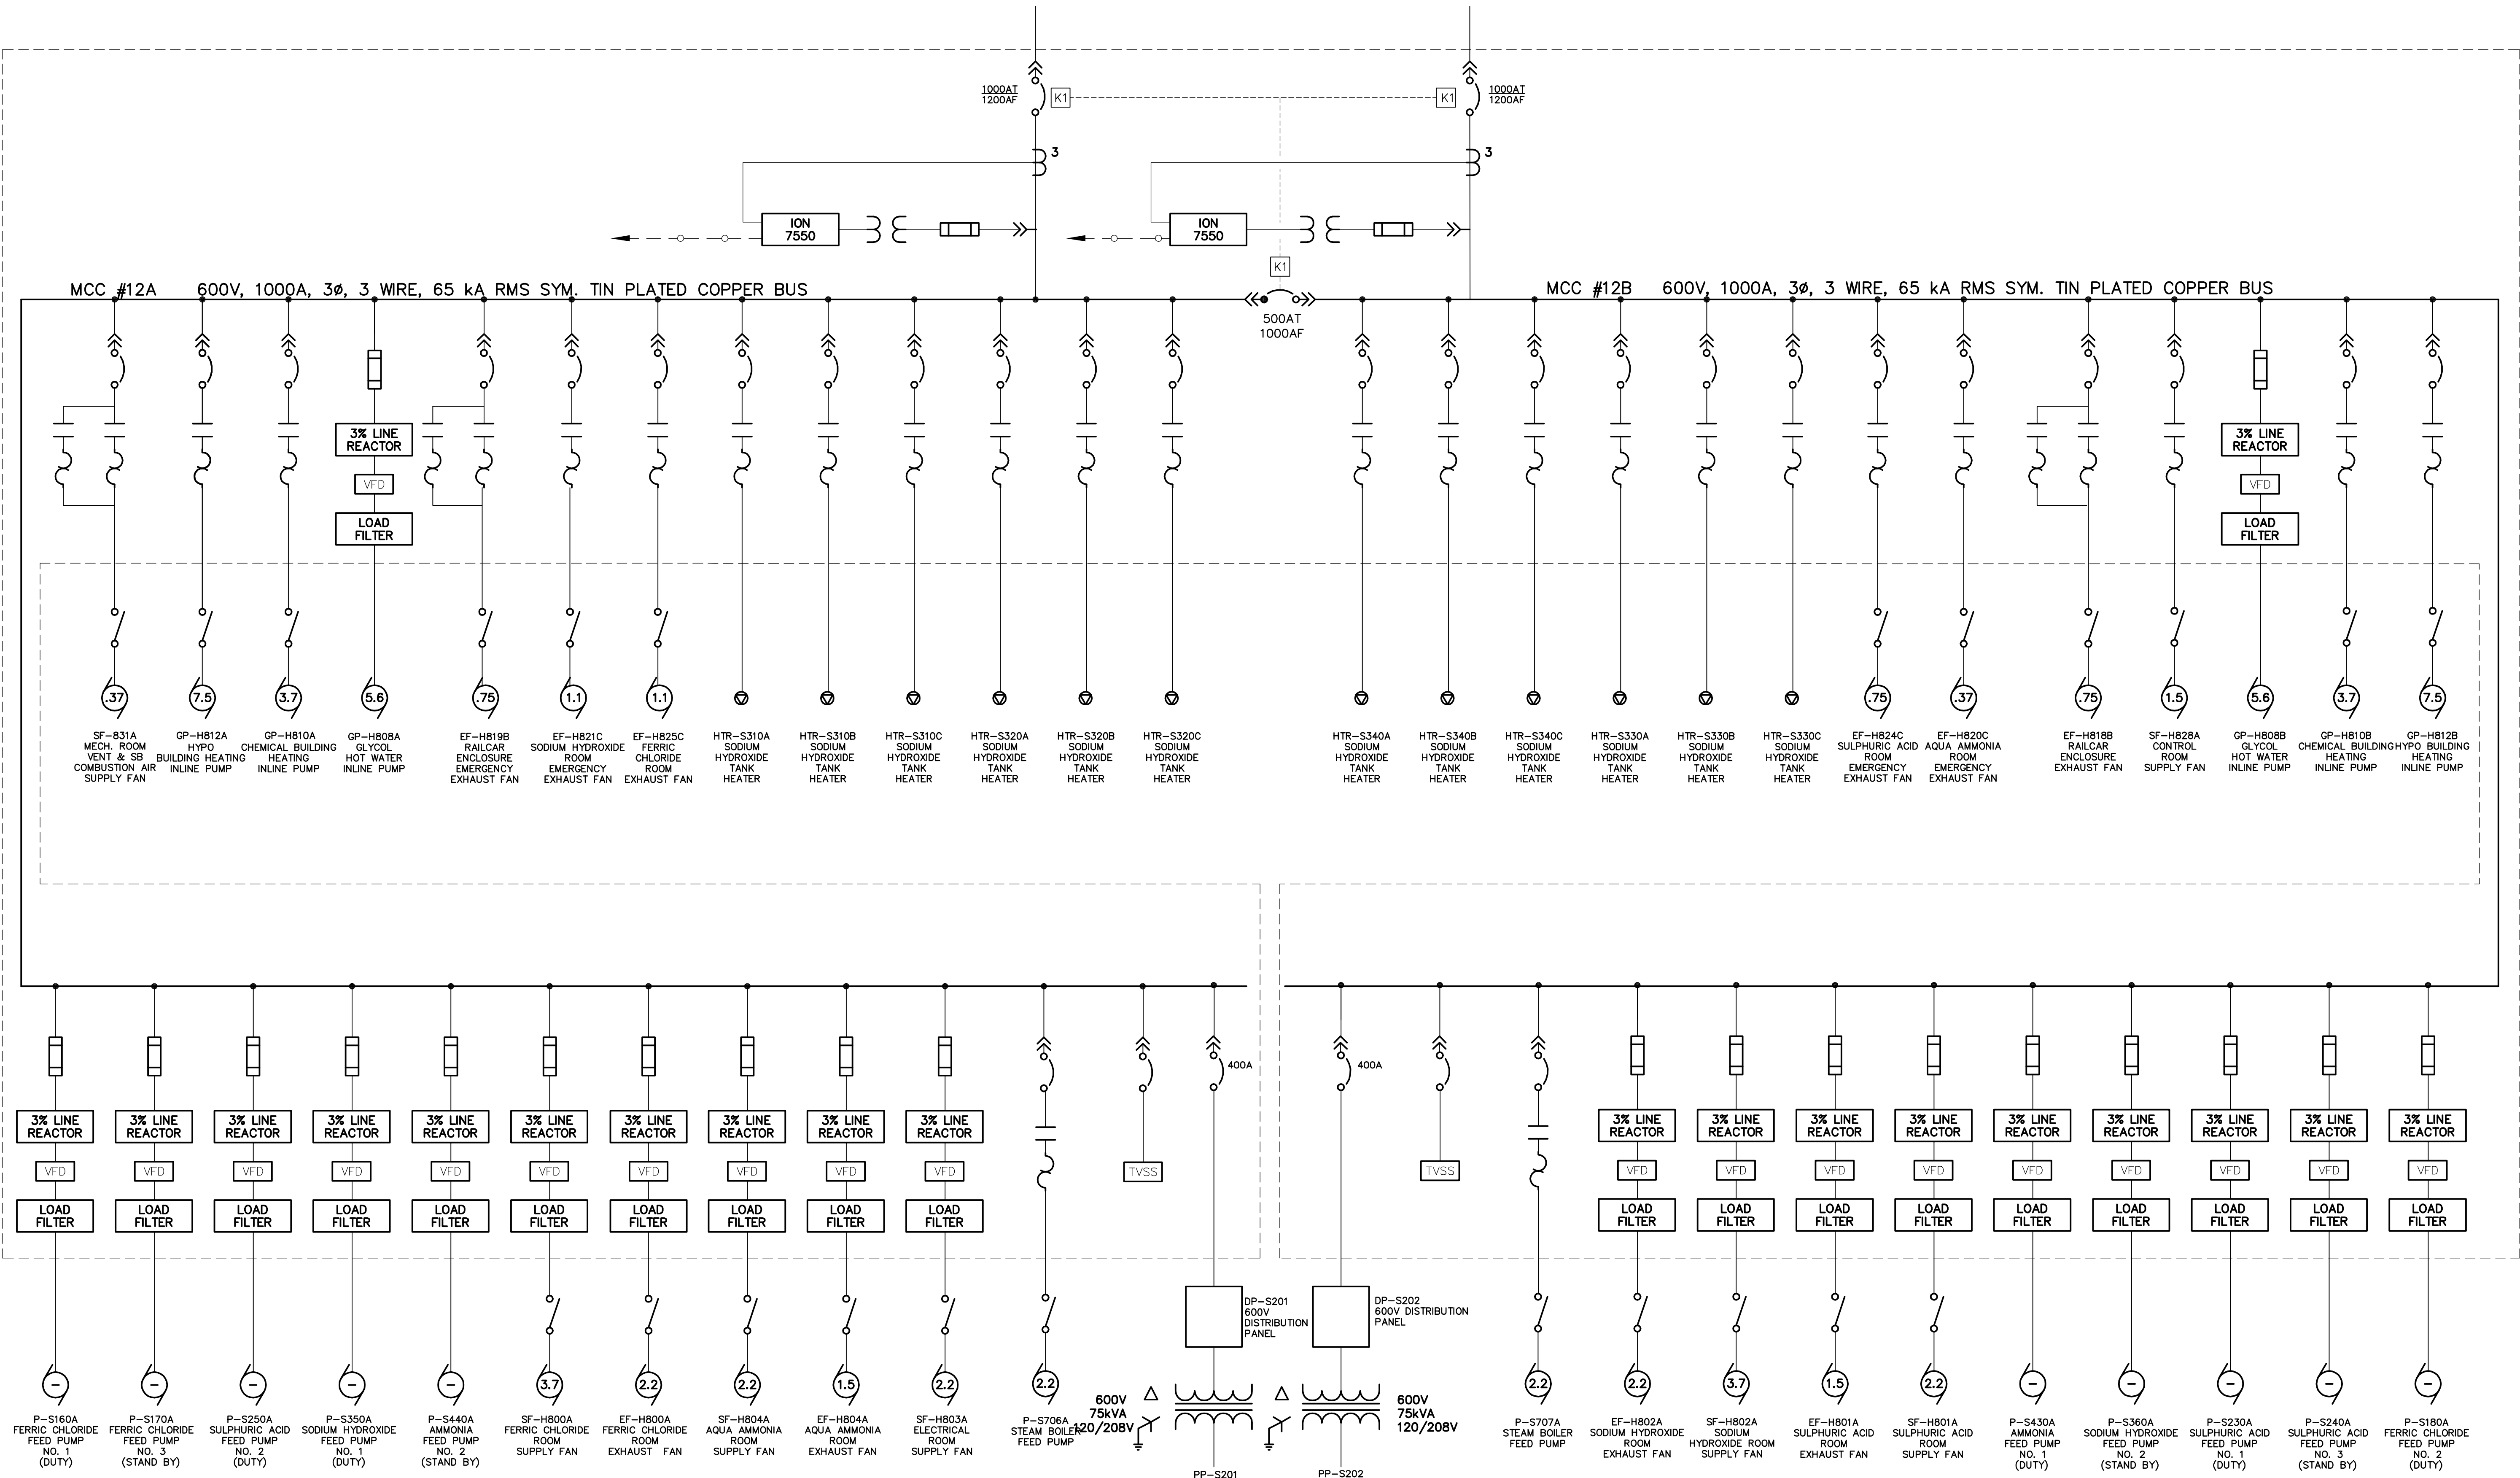

NOTES:
1. ALL POWER REQUIREMENTS ARE SHOWN IN KW.

<p>Certificate of Authorization Earth Tech Canada Inc. No. 730 Expiry: April 30, 2007</p>	B.M. ELEV.	<p>Frederickson Cooper ARCHITECTS</p>	<p>A Tech International Ltd. Company</p>	ENGINEER'S SEAL	<p>THE CITY OF WINNIPEG WATER AND WASTE DEPARTMENT ENGINEERING DIVISION</p>		
				DESIGNED BY: BLM		CHECKED BY: PS	ORIGINAL SIGNED BY: P. STRYK
				DRAWN BY: ERC		APPROVED BY: AHL	2007/01/31
				SCALE: NTS		RELEASED FOR CONSTRUCTION BY: R. SOROKOWSKI	CONSULTANT DRAWING NO. WS-E0504
	00 ISSUED FOR TENDER 07/01/31 ERC	DATE 2006/10/01	DATE 2007/01/31		<p>WATER TREATMENT PLANT BULK CHEMICAL STORAGE SODIUM HYPOCHLORITE AND CHEMICAL STORAGE BUILDING</p> <p>ELECTRICAL SINGLE LINE DIAGRAM 600 VOLT MCC #12A AND MCC #12B</p>		
	NO. REVISIONS	DATE	BY		<p>CITY FILE NUMBER</p> <p>SHEET OF</p> <p>CITY DRAWING NUMBER</p> <p>1-0601S-F-E0504-001-000</p>		