


10 WALL SECTION  
WB-B0110 1 : 50

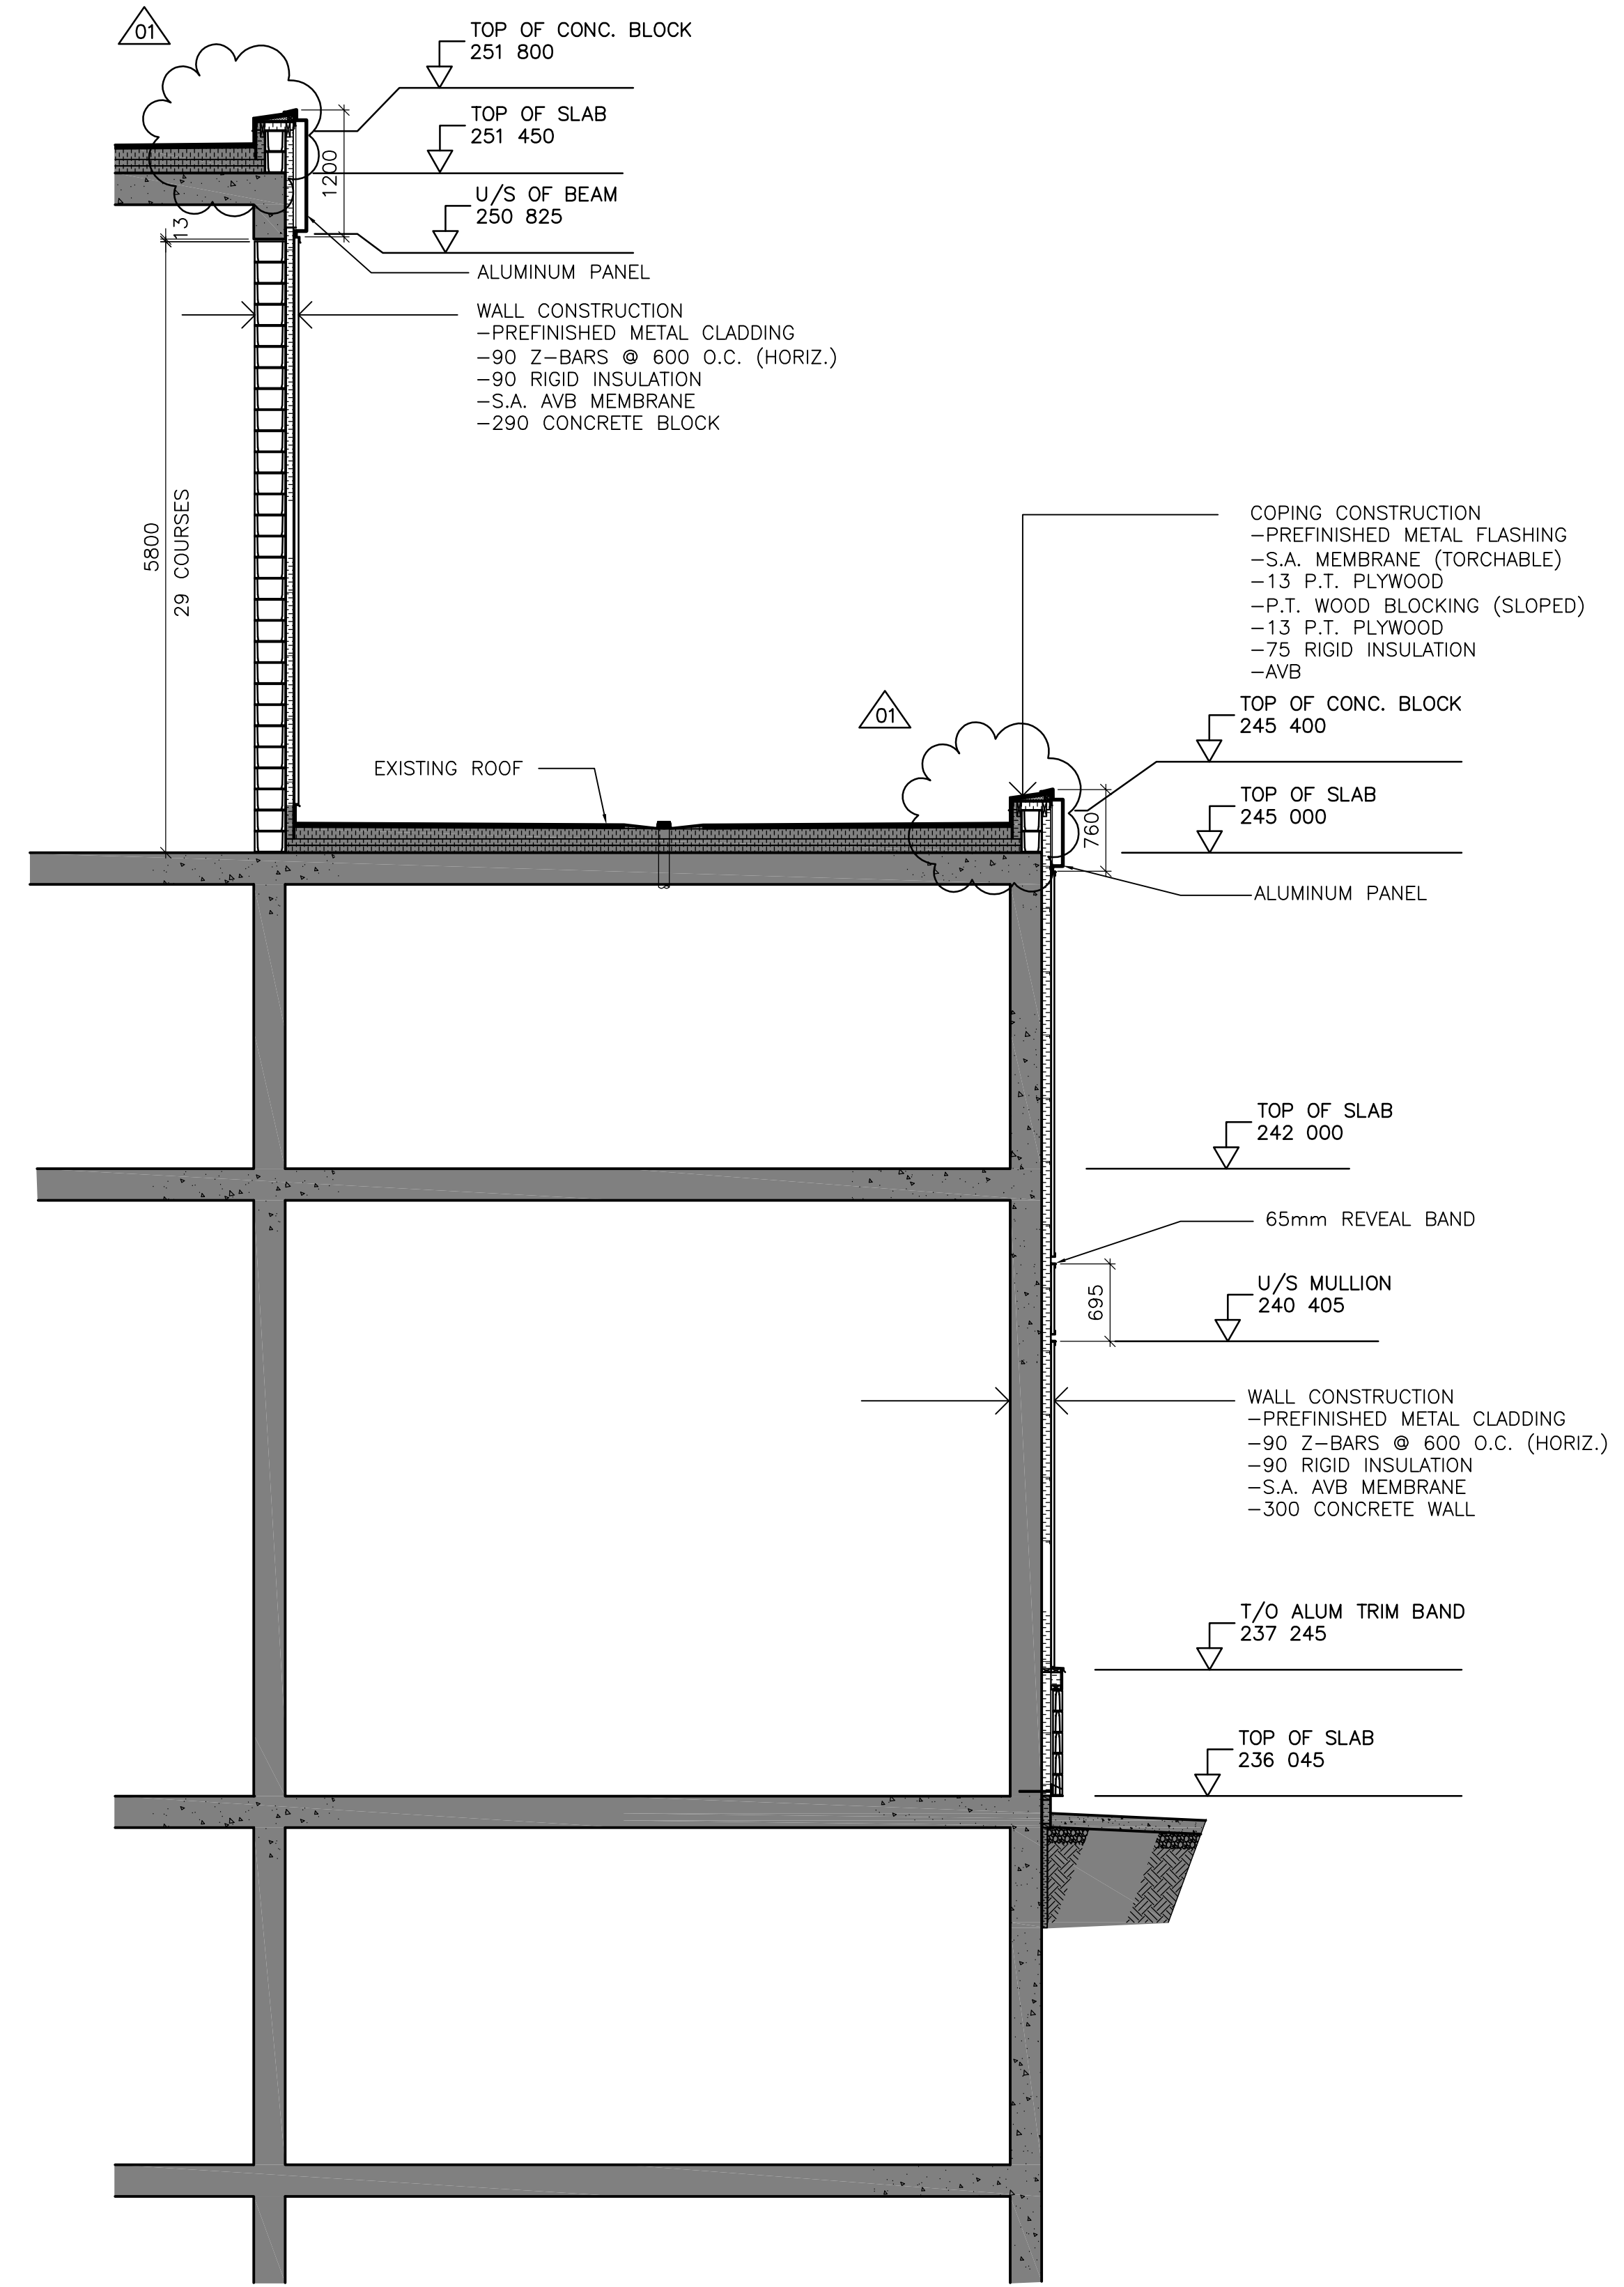

11 WALL SECTION  
WB-B0206 1 : 50



B.M.	ELEV.	DATE	BY
01	793-2006 ADDENDUM 1	07/03/29	LK
00	ISSUED FOR TENDER	07/03/19	LK
NO.	REVISIONS	DATE	BY



DESIGNED BY	NC	CHECKED BY	LK
DRAWN BY	IC	APPROVED BY	AHL
SCALE:	AS SHOWN		
RELEASED FOR CONSTRUCTION BY:	R. SOROKOWSKI		
DATE	2005/11/28	DATE	2007/03/19

ENGINEER'S SEAL  
ORIGINAL  
SIGNED BY  
NEIL COOPER  
2007/03/19  
CONSULTANT DRAWING NO.  
WB-B0253



THE CITY OF WINNIPEG  
WATER AND WASTE DEPARTMENT  
ENGINEERING DIVISION

WATER TREATMENT PLANT  
MAIN BUILDING  
BUILDING ENVELOPE

CITY FILE NUMBER

SHEET OF

CITY DRAWING NUMBER

1-0601B-A-B0253-001-01D