


PENTHOUSE FLOOR PLAN
SCALE: 1:300

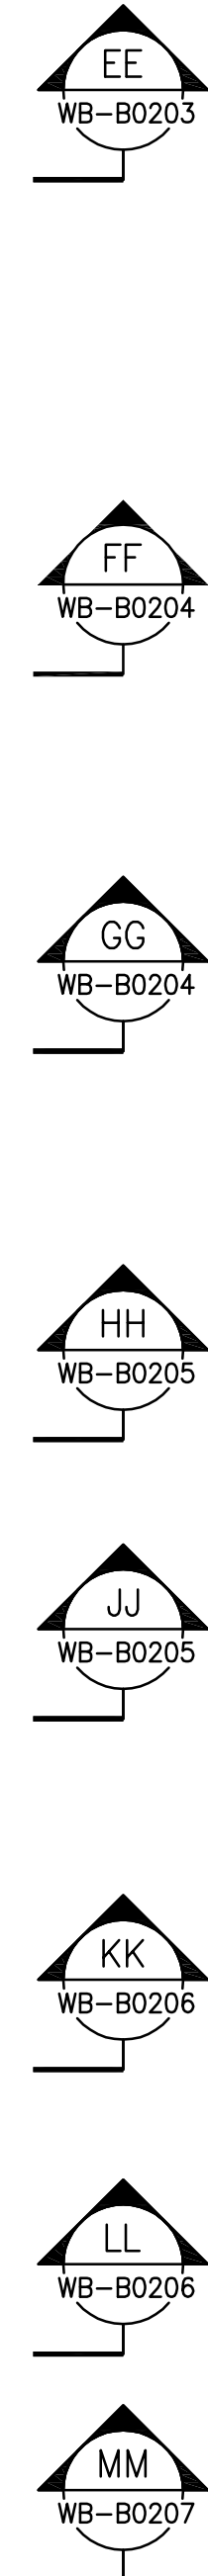

B.M. ELEV.					
DESIGNED BY	TWS	CHECKED BY	BJS		
DRAWN BY	SH/LK	APPROVED BY	AHL		
SCALE:	AS NOTED	RELEASED FOR CONSTRUCTION BY:	R. SOROKOWSKI		
NO.	REVISIONS	DATE	BY	DATE	2005/08/05
01	793-2006 ADDENDUM 2	07/04/05	LK	DATE	2007/03/19
00	ISSUED FOR TENDER	07/03/19	LK		

ENGINEER'S SEAL
ORIGINAL SIGNED BY
NEIL COOPER
2007/03/19
CONSULTANT DRAWING NO.
WB-B0140

THE CITY OF WINNIPEG
WATER AND WASTE DEPARTMENT
ENGINEERING DIVISION

WATER TREATMENT PLANT
MAIN BUILDING
BUILDING ENVELOPE

ARCHITECTURAL
PENTHOUSE FLOOR PLAN

CITY FILE NUMBER
SHEET OF
CITY DRAWING NUMBER
1-060B-A-B0140-001-01D