


WEST ELEVATION
SCALE 1:200

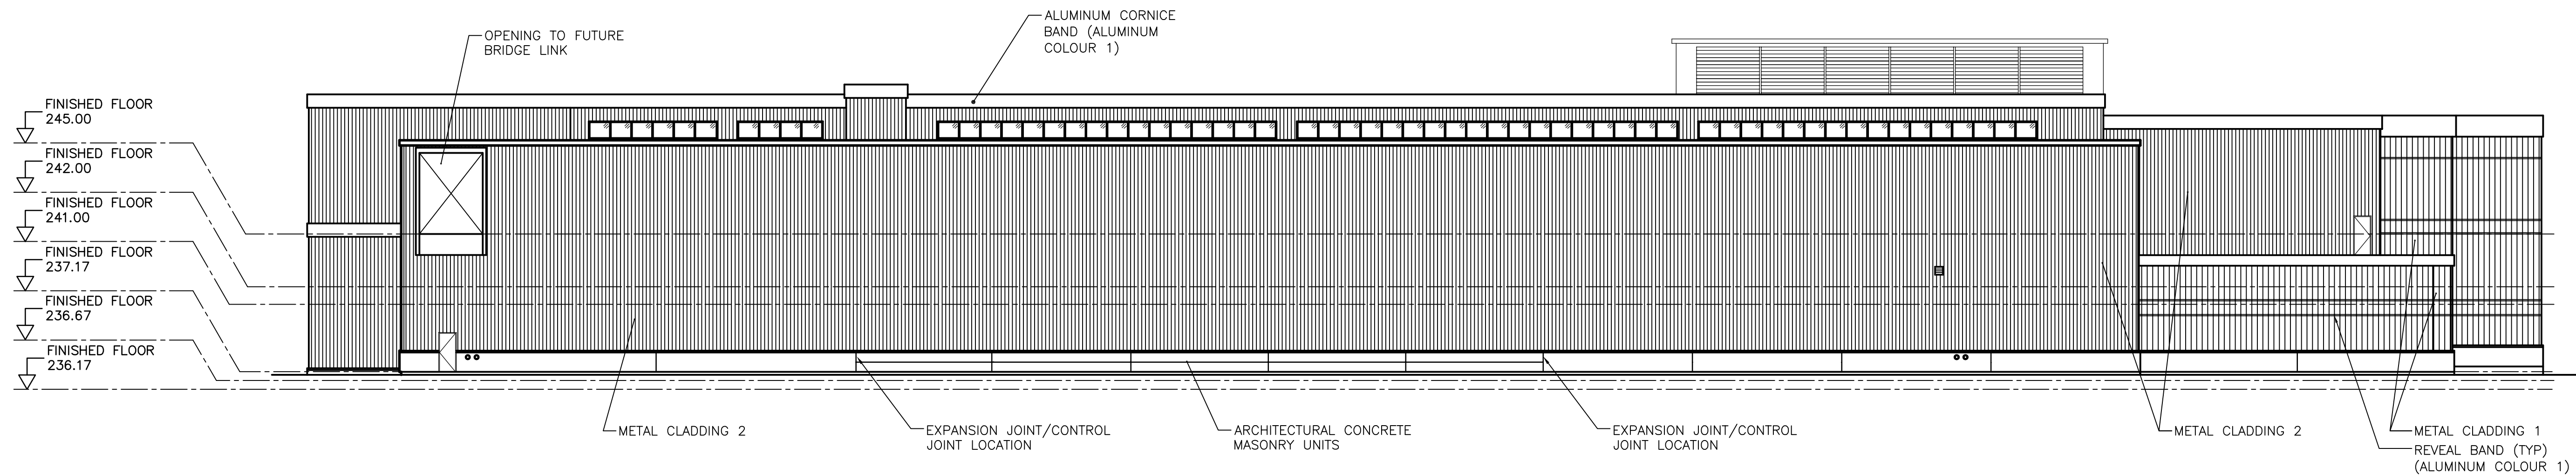

NORTH ELEVATION
SCALE 1:200



B.M. ELEV.			
NO.	REVISIONS	DATE	BY
00	ISSUED FOR TENDER	07/03/19	LK

DESIGNED BY		CHECKED BY	
TWS		BJS	
DRAWN BY		APPROVED BY	
SH/LK		AHL	
SCALE:		RELEASED FOR CONSTRUCTION BY:	
1:300		R. SOROKOWSKI	
DATE	2005/08/03	DATE	2007/03/19

ENGINEER'S SEAL	
ORIGINAL SIGNED BY	NEIL COOPER
DATE	2007/03/19
CONSULTANT DRAWING NO.	WB-B0302

THE CITY OF WINNIPEG
WATER AND WASTE DEPARTMENT
ENGINEERING DIVISION

WATER TREATMENT PLANT
MAIN BUILDING
BUILDING ENVELOPE

ARCHITECTURAL
EXTERIOR ELEVATIONS

CITY FILE NUMBER	
SHEET	OF
CITY DRAWING NUMBER	1-060B-A-B0302-001-00D-R0