




1 PLAN - ELECTRICAL RM
1c SCALE: 1:40

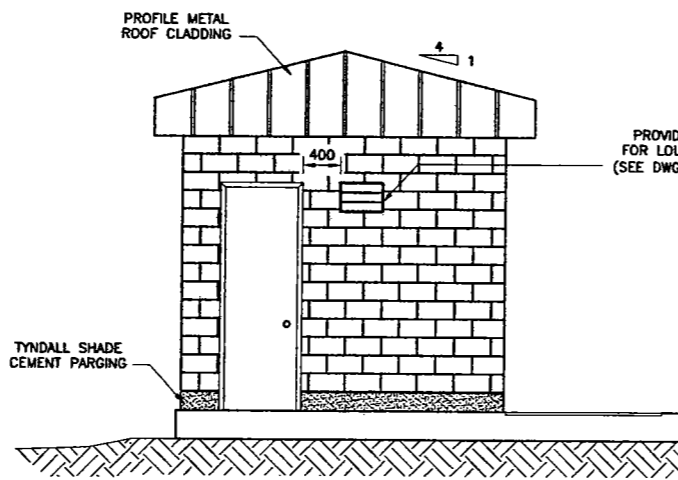


NORTH ELEVATION
SCALE: 1:40

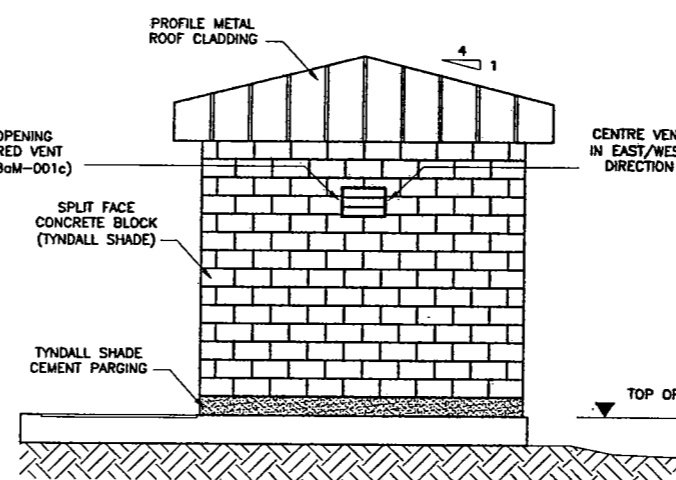


SOUTH ELEVATION
SCALE: 1:40

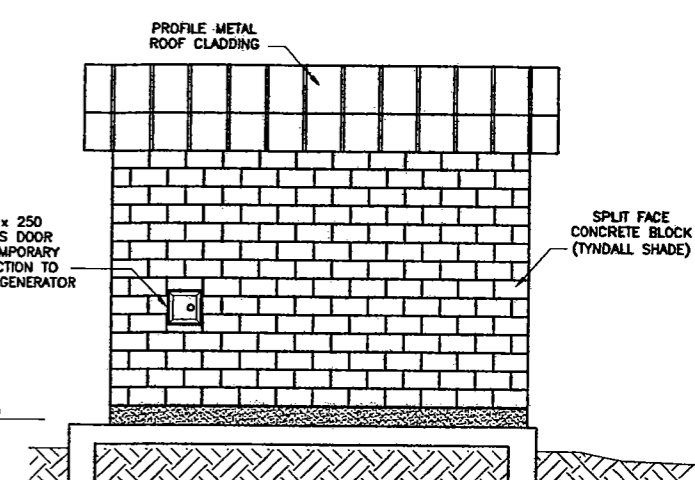


EAST ELEVATION
SCALE: 1:40

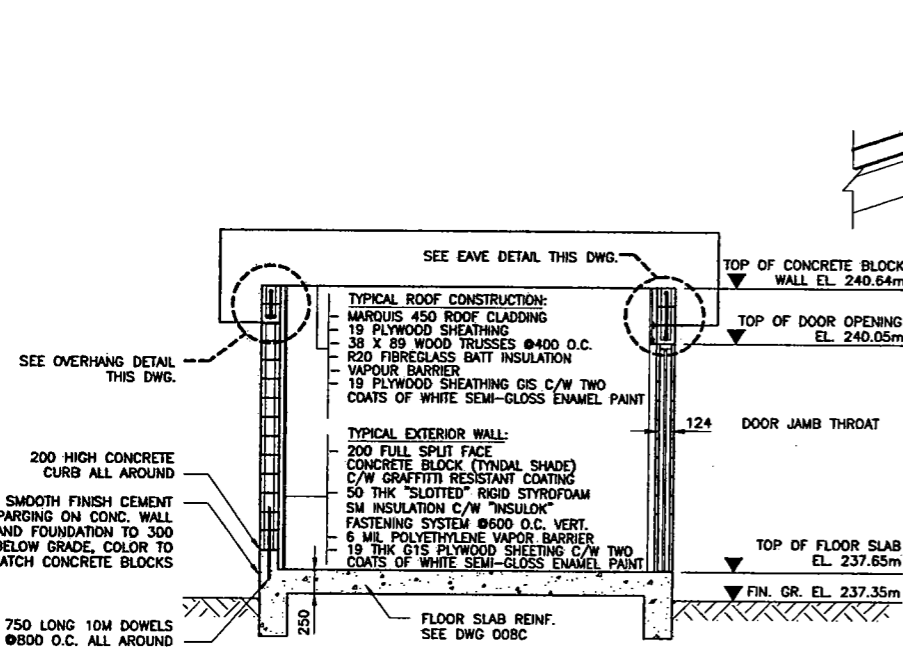

SECTION A-A
SCALE: 1:40

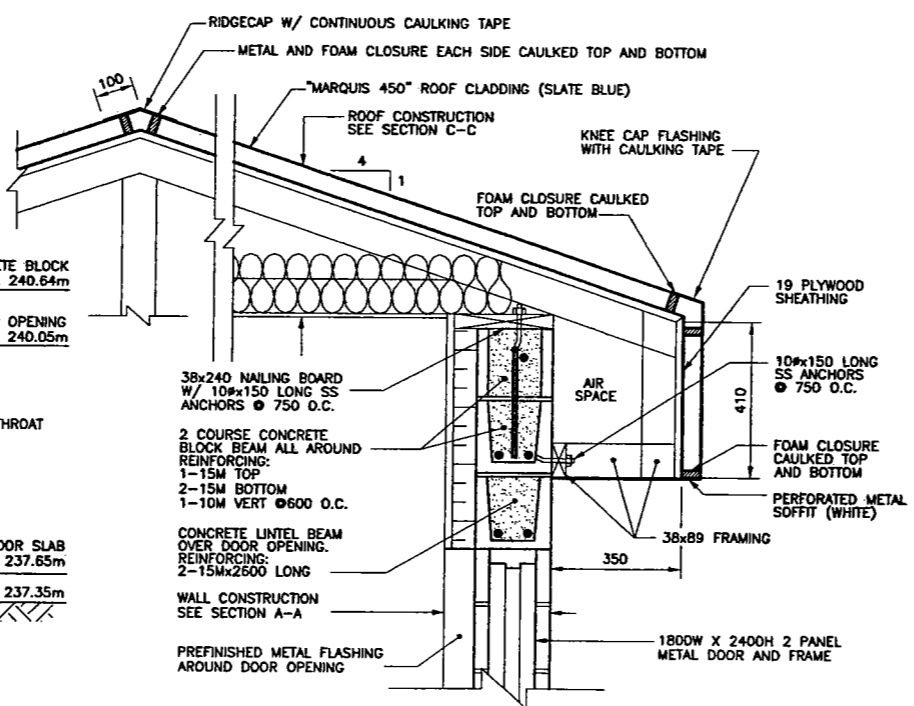


EAVE DETAIL
SCALE: 1:10

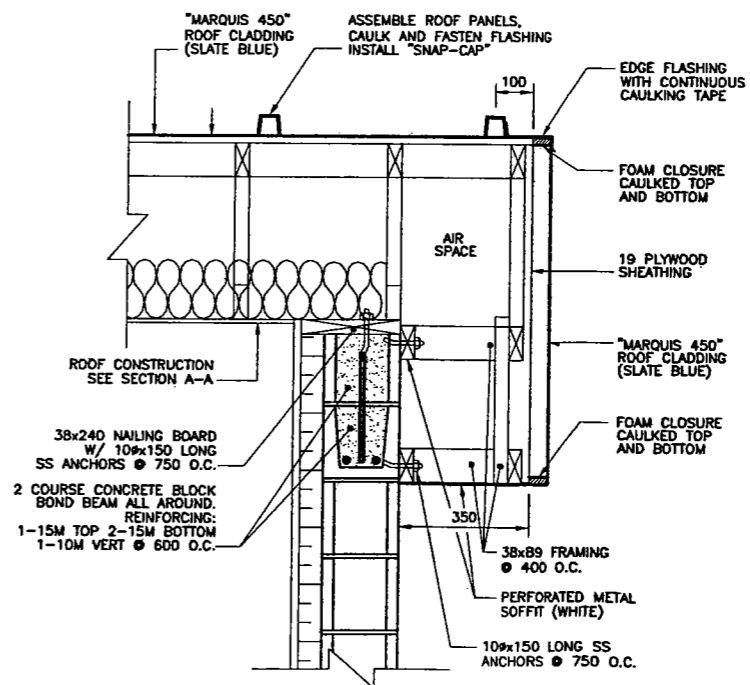

OVERHANG DETAIL
SCALE: 1:10

 1. REFER TO DRAWING 48aS-001c FOR GENERAL NOTES.



| | | | | |
|-----|----------|------------------------------------|----|------------|
| 00 | 04/07/06 | ISSUED FOR TENDER AND CONSTRUCTION | TF | CMS/JBS |
| NO. | DATE | REVISIONS | BY | CHKD./APP. |

KGS GROUP
SUBCONSULTANT DWG NO.:

C of A

ENG. STAMP
C.M. SIEPMAN
Member
20613

| | | | | | |
|-------------------------------------|-----|--------------|-----------|--------|----------|
| DESIGNED BY: | TF | DRAWN BY: | EC | SCALE: | AS NOTED |
| CHECKED BY: | CMS | APPROVED BY: | J B SMITH | DATE: | MAY 2006 |
| KGS GROUP SUBMITTED BY: RICK CARSON | | | | | |

OWNER
MANITOBA FLOODWAY AUTHORITY

PROJECT:
RED RIVER FLOODWAY EXPANSION

PHASE:
MAIN CHANNEL CONTRACT No. C5

TITLE:
KILDARE LAND DRAINAGE FLOOD PUMPING STATION
STRUCTURAL WORKS
ELECTRICAL ROOM
PLAN, SECTION, ELEVATIONS & DETAILS

RELEASED FOR CONSTRUCTION:

DOUG McNEIL
VICE PRESIDENT OF ENGINEERING AND CONSTRUCTION

| | | | | | |
|----------------|---------------|------|----|------|----|
| OWNER DWG NO.: | CC5-48aS-015c | SHT. | 01 | REV. | 00 |
|----------------|---------------|------|----|------|----|



24x36 // E094914 // P:\Projects\2005-05-0107-17\Civil\Drawings\REVISED\005-015c-01-00.dwg - Tab: S15 - Apr 05, 2007 - 3:59pm - User: jgnitzinger