


NOTES

1. FOR GENERAL NOTES REFER TO DWG. 76012-05-5112
2. R.D. DENOTES ROOF DRAIN
3. SEE DWG. M111 FOR FURTHER DETAILS ON ROOF DRAINAGE.

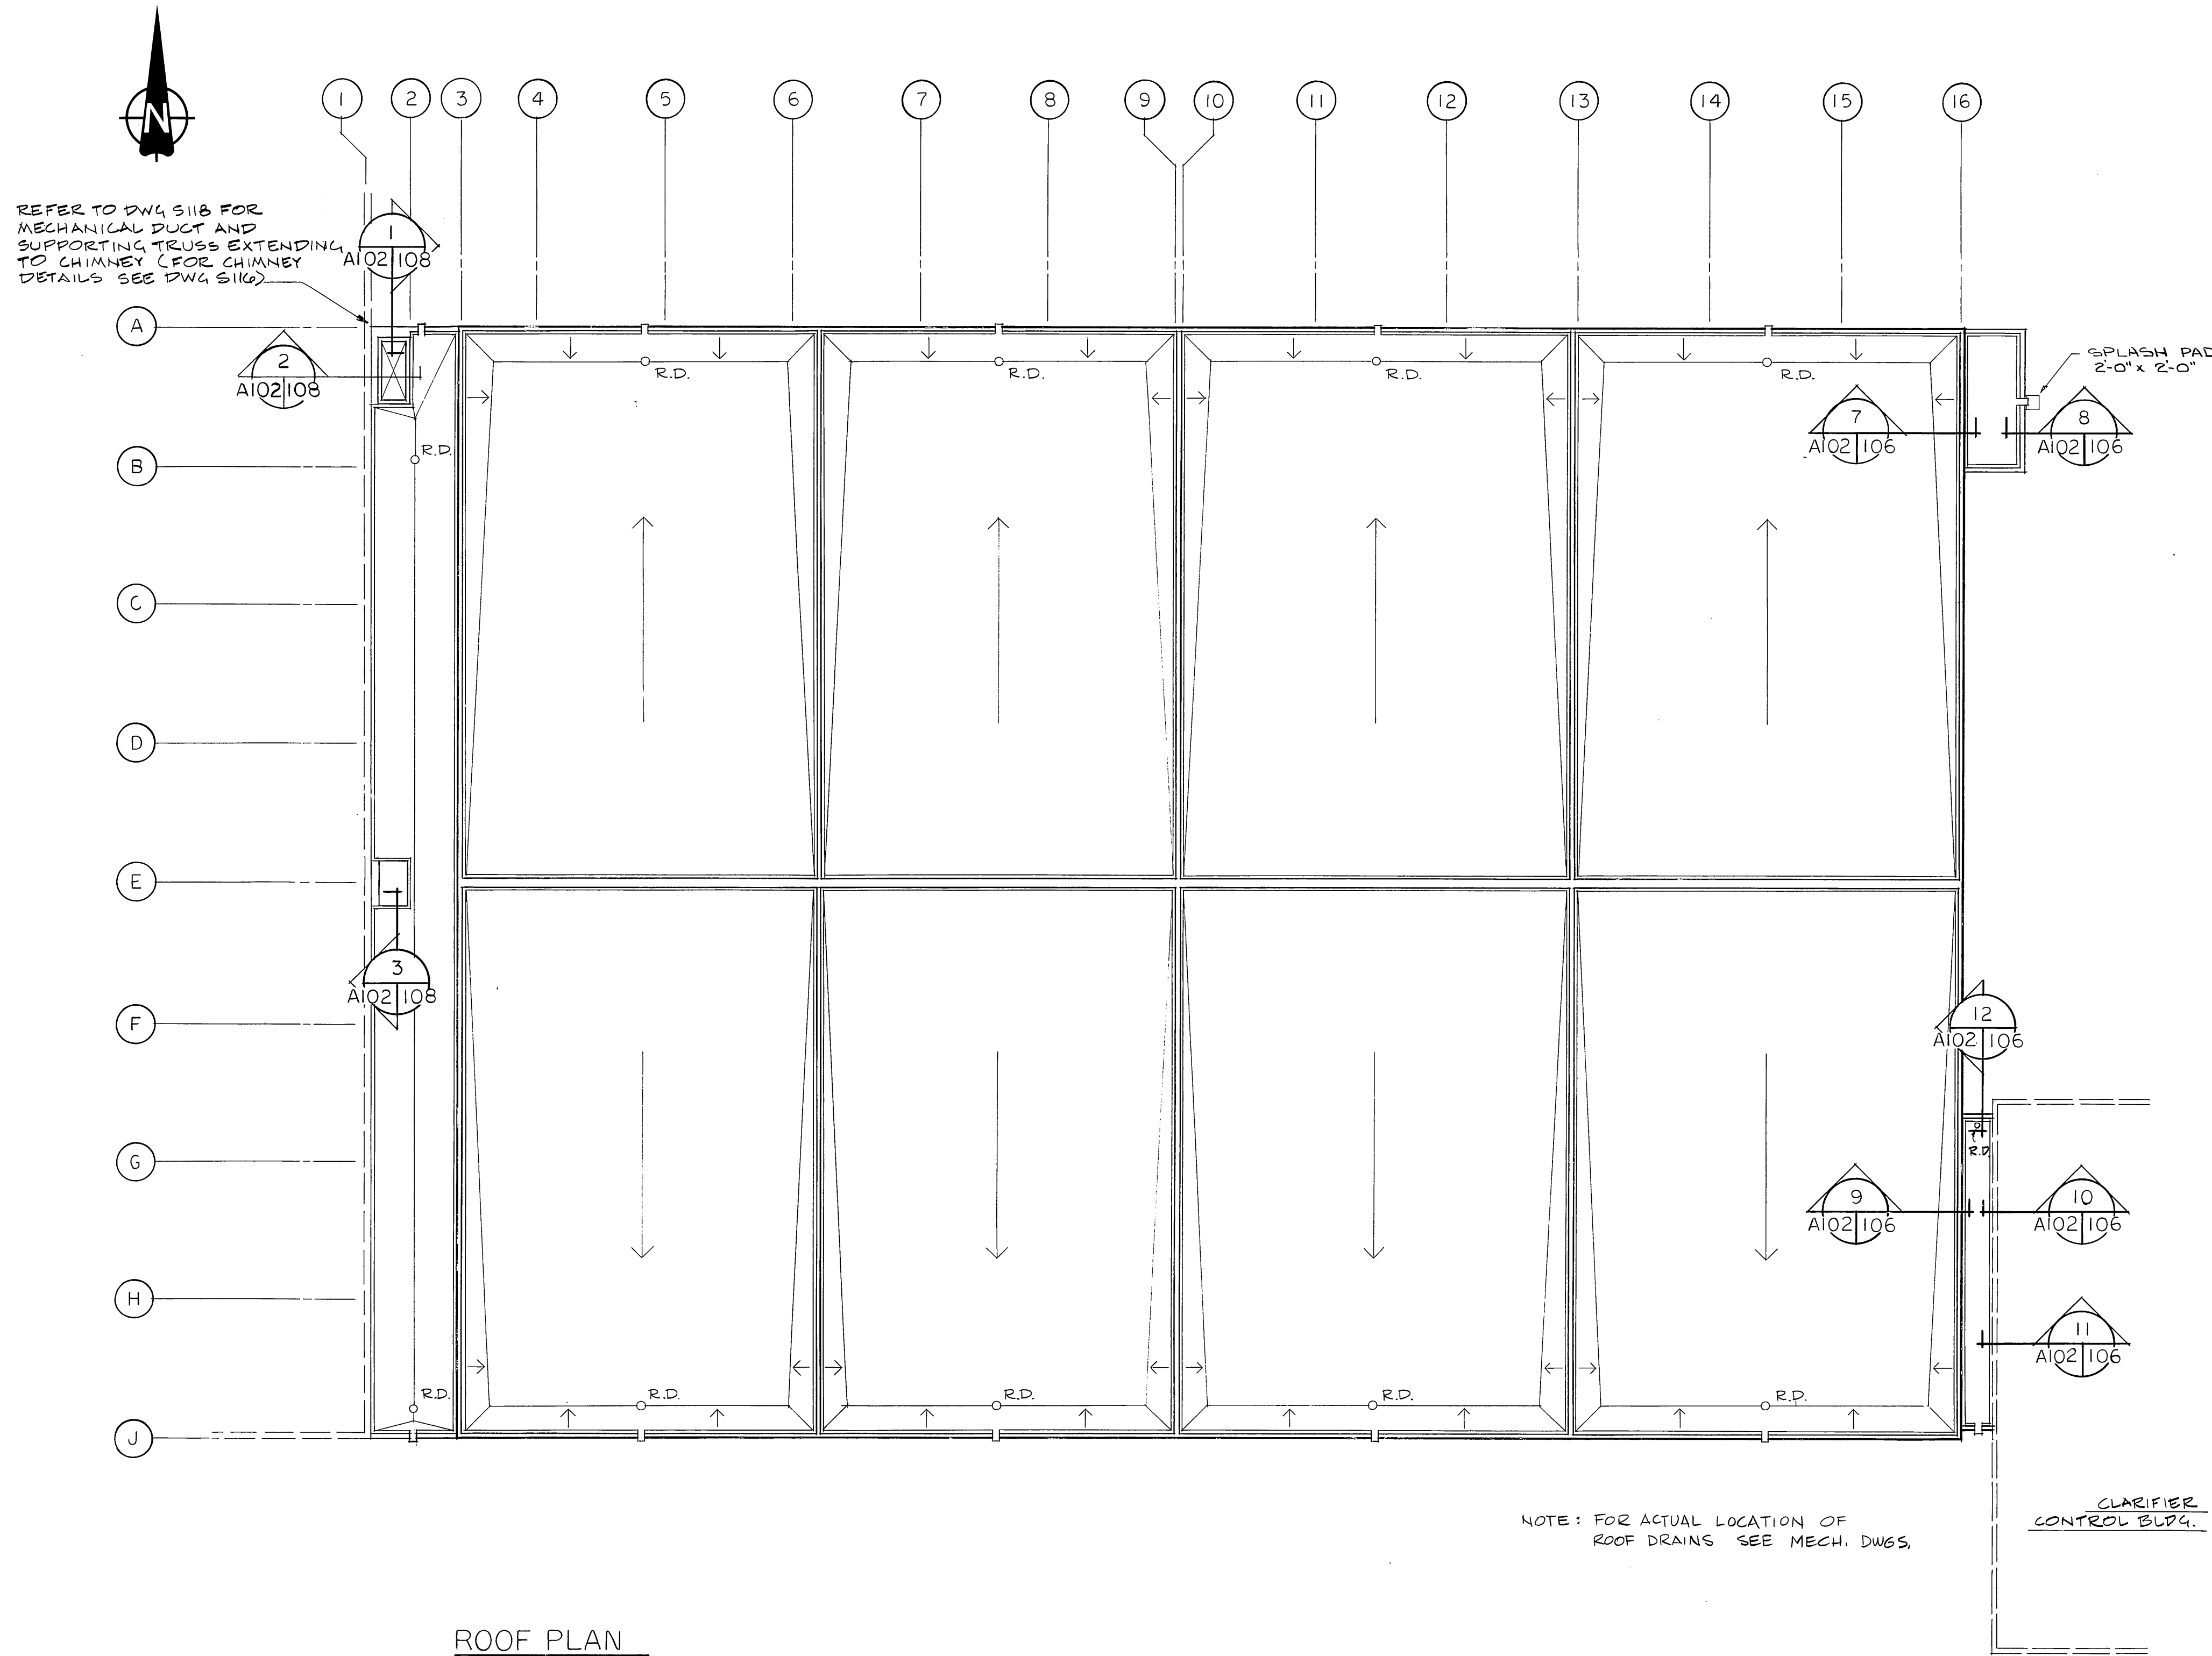


REFER TO DWG 5118 FOR MECHANICAL DUCT AND SUPPORTING TRUSS EXTENDING TO CHIMNEY (FOR CHIMNEY DETAILS SEE DWG 5116)

ROOF PLAN
1/16" = 1'-0"

MICROFILMED MAR 31 1980

CONSULTANT	CENTRAL FILE	ENGINEERING FILE	SHEET NO.	NO. OF SHEETS	MEDIUM	SCALE	DATE FILMED
OFFICE	DRAWING FILE	NUMBER	NO.	SIZE	SECTION	FRAME	
	GRID CO-ORDINATES				PROPOSED	REVISED	
MICROFILMING	WORKS & OPERATIONS DEPT.						

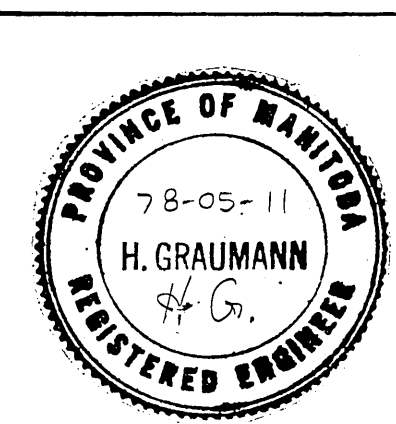

REV.	DESCRIPTION	BY	DATE
0	AS BUILT CSA	H.G.	SEPT. 79
1	ISSUED FOR TENDER	H.G.	MAY 1978

W.L. WARDROP & ASSOCIATES LTD. JAMES F. MACLAREN LIMITED ENGINEERING CONSULTANTS	
DRAWN BY: R.N.	DESIGNED BY: J.K.
CHECKED BY: H.G.	APPROVED BY: <i>[Signature]</i>
	DATE:

THE CITY OF WINNIPEG
WORKS & OPERATIONS DEPARTMENT
WATERWORKS, WASTE & DISPOSAL DIVISION

**NORTH END WATER POLLUTION CONTROL CENTRE
PRIMARY CLARIFIER ADDITION
ARCHITECTURAL
ROOF PLAN**

SCALE:	AS SHOWN
DATE:	MAY 1978
CONSULTANT DRAWING NO.	76012-05-A102
CITY DRAWING NO.	NEP-925

NEP-0925

NR 11101