




1 SECTION
A101105 1" = 1'-0"

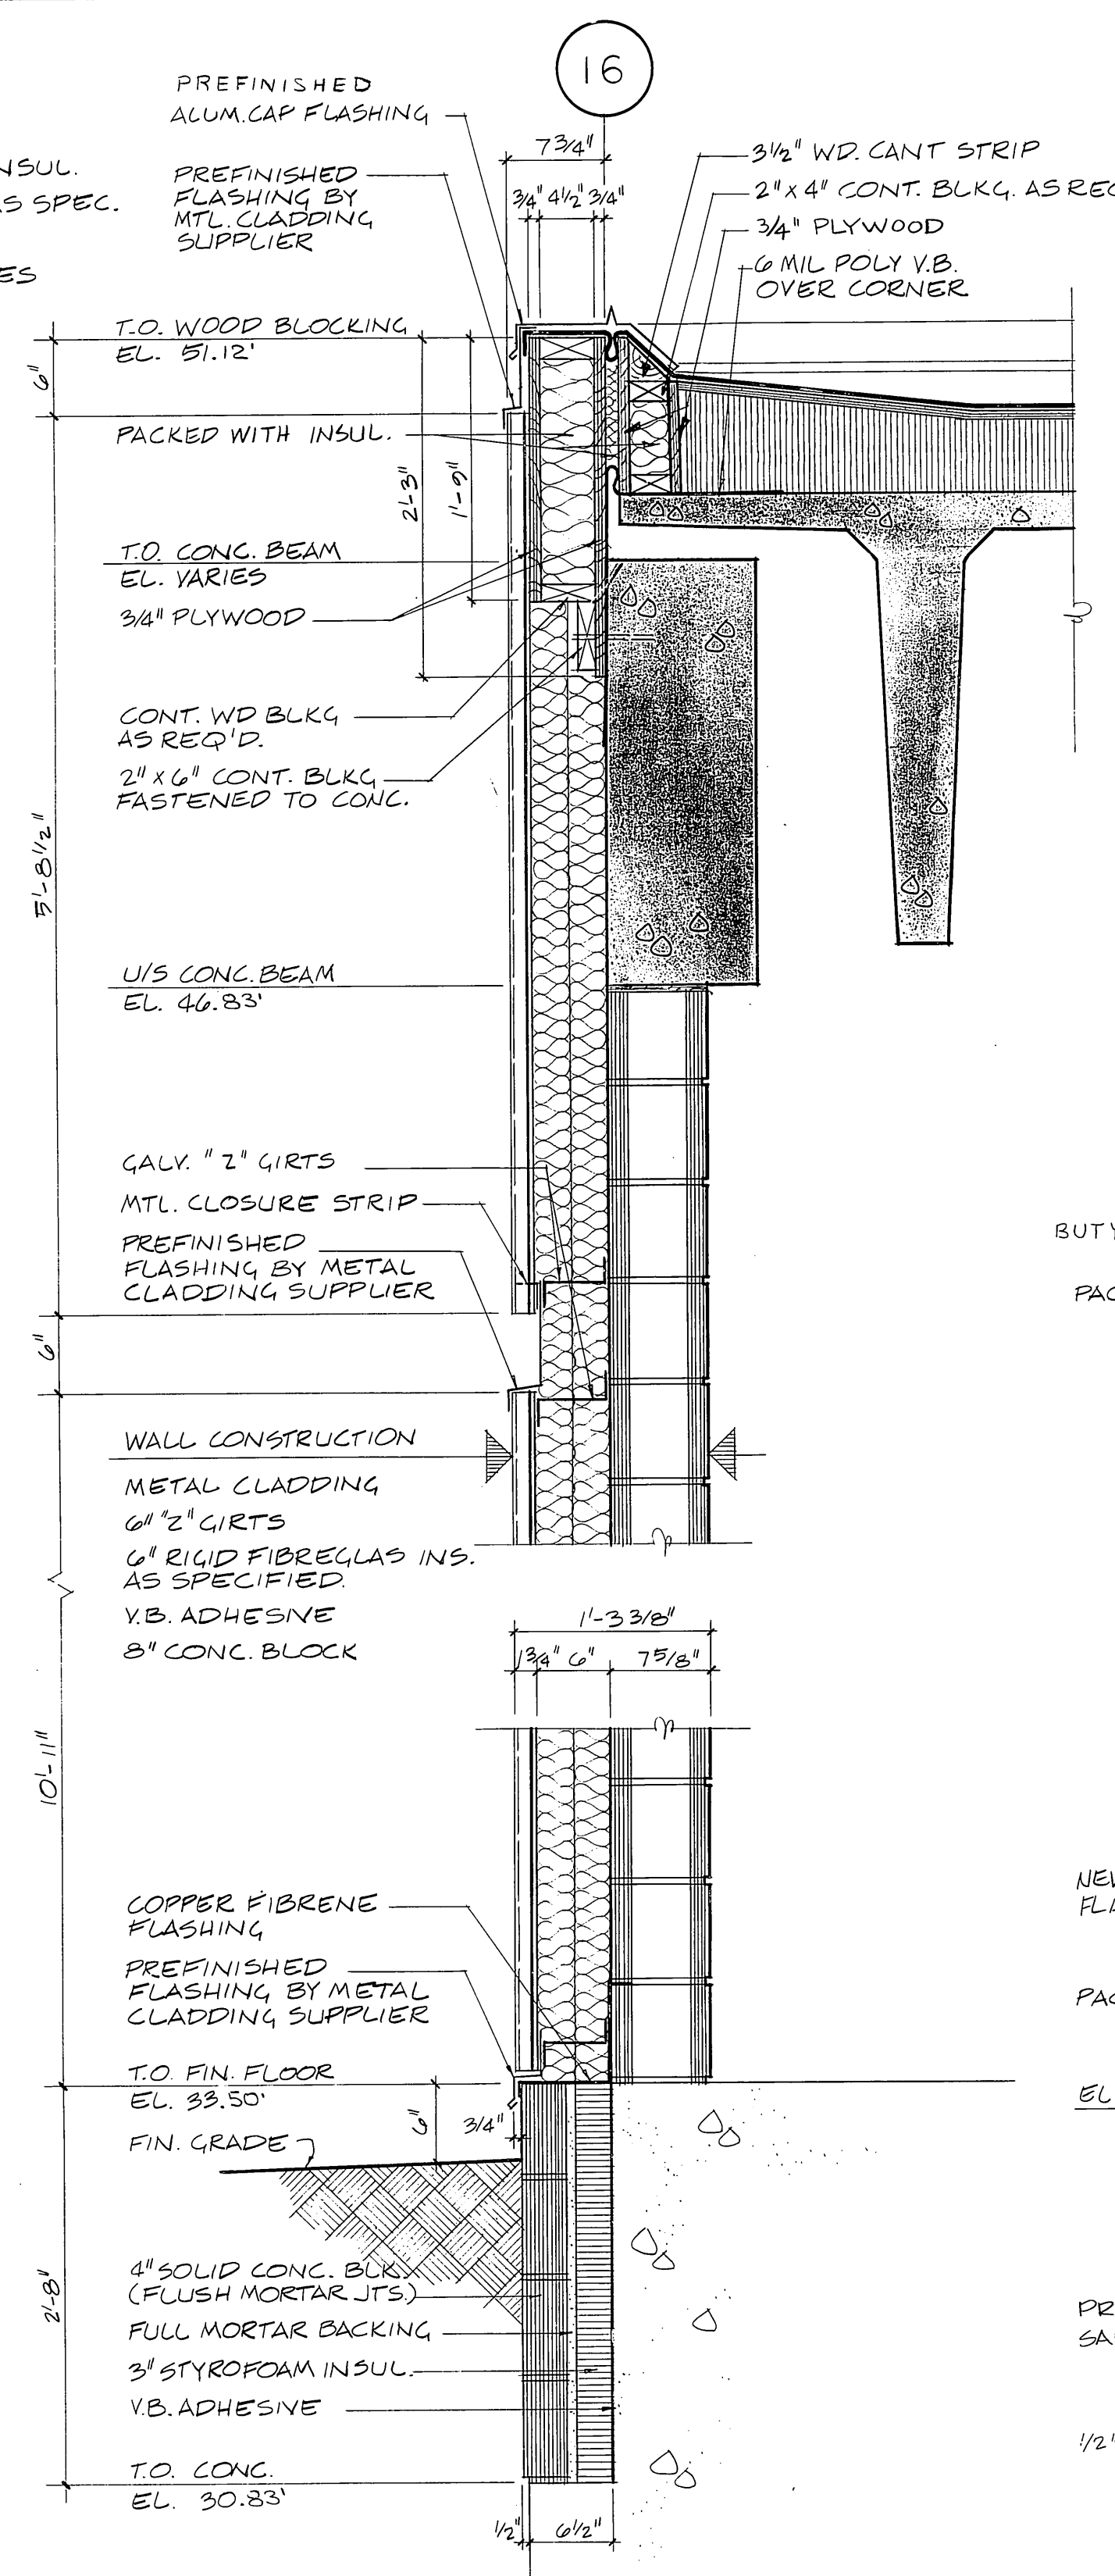


2 SECTION
A101105 1" = 1'-0"

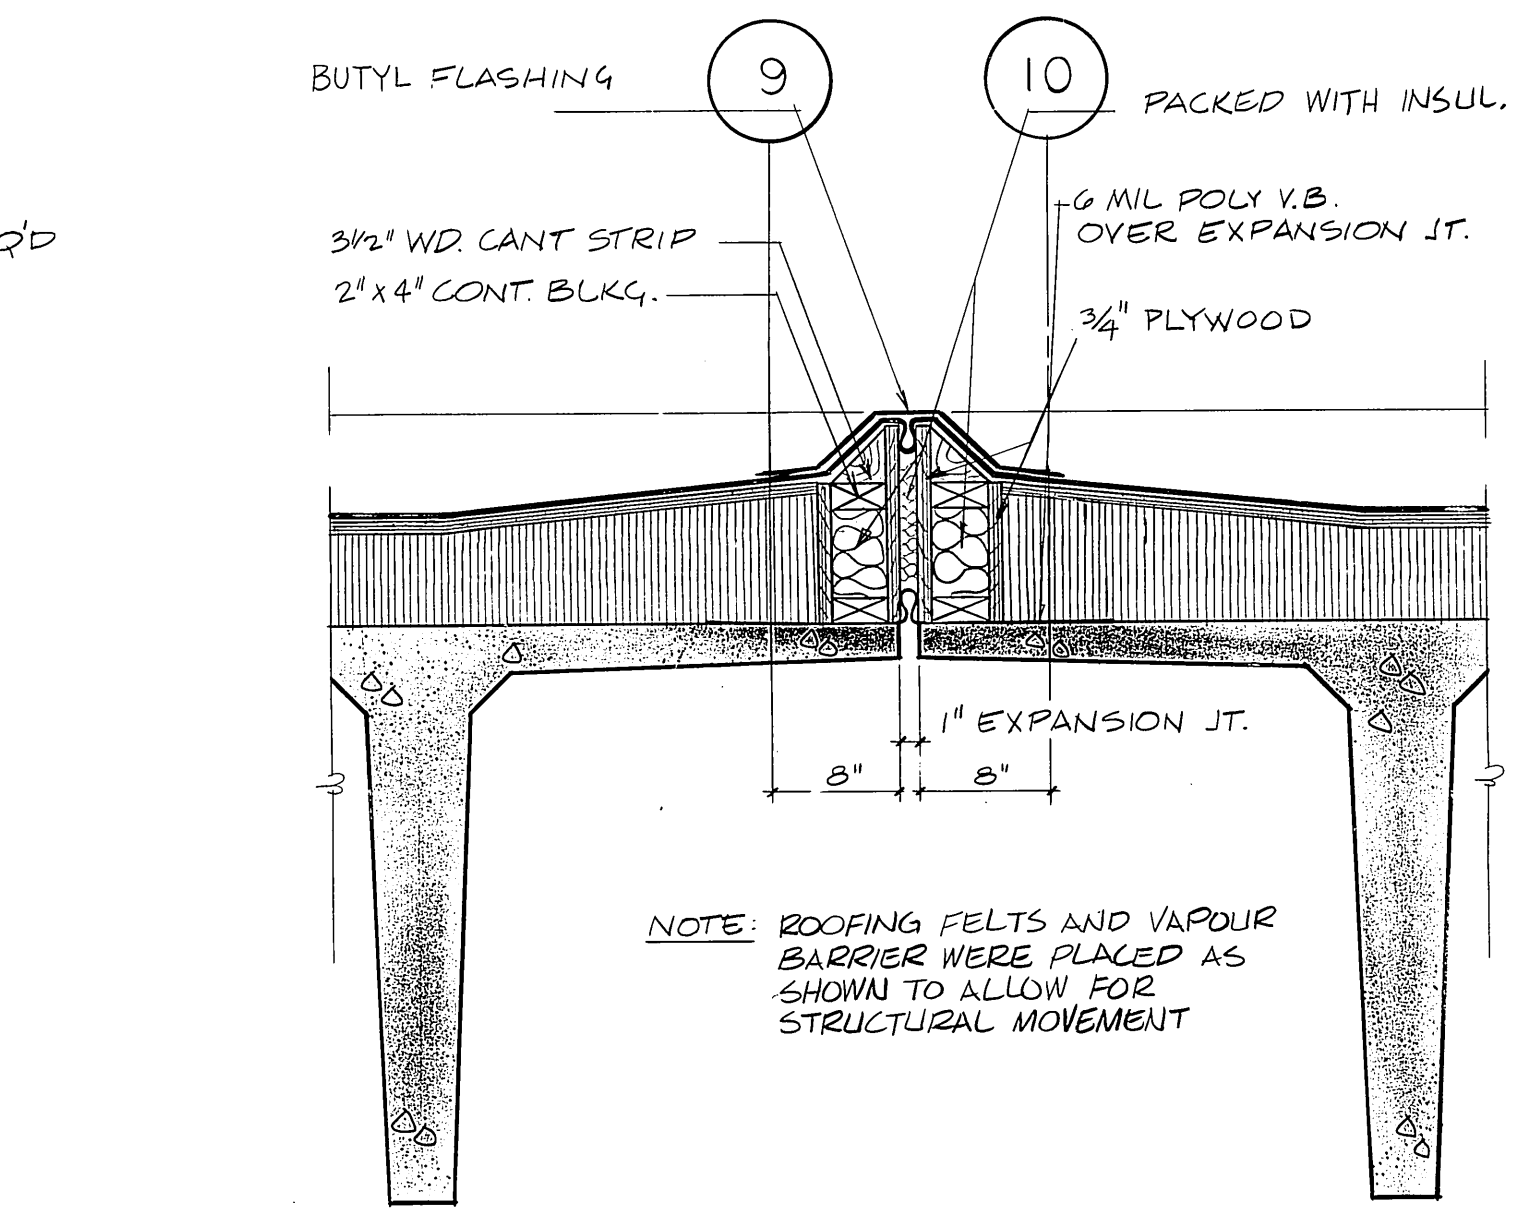


3 DETAIL
A104105 1" = 1'-0"

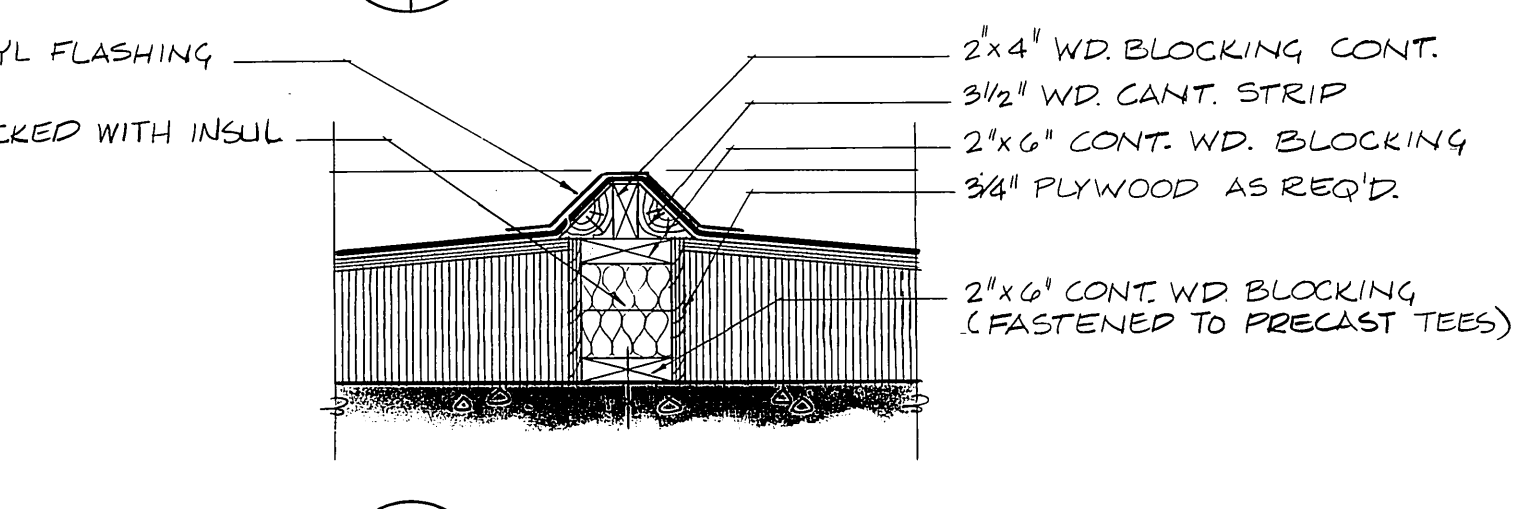


4 DETAIL
A104105 1" = 1'-0"

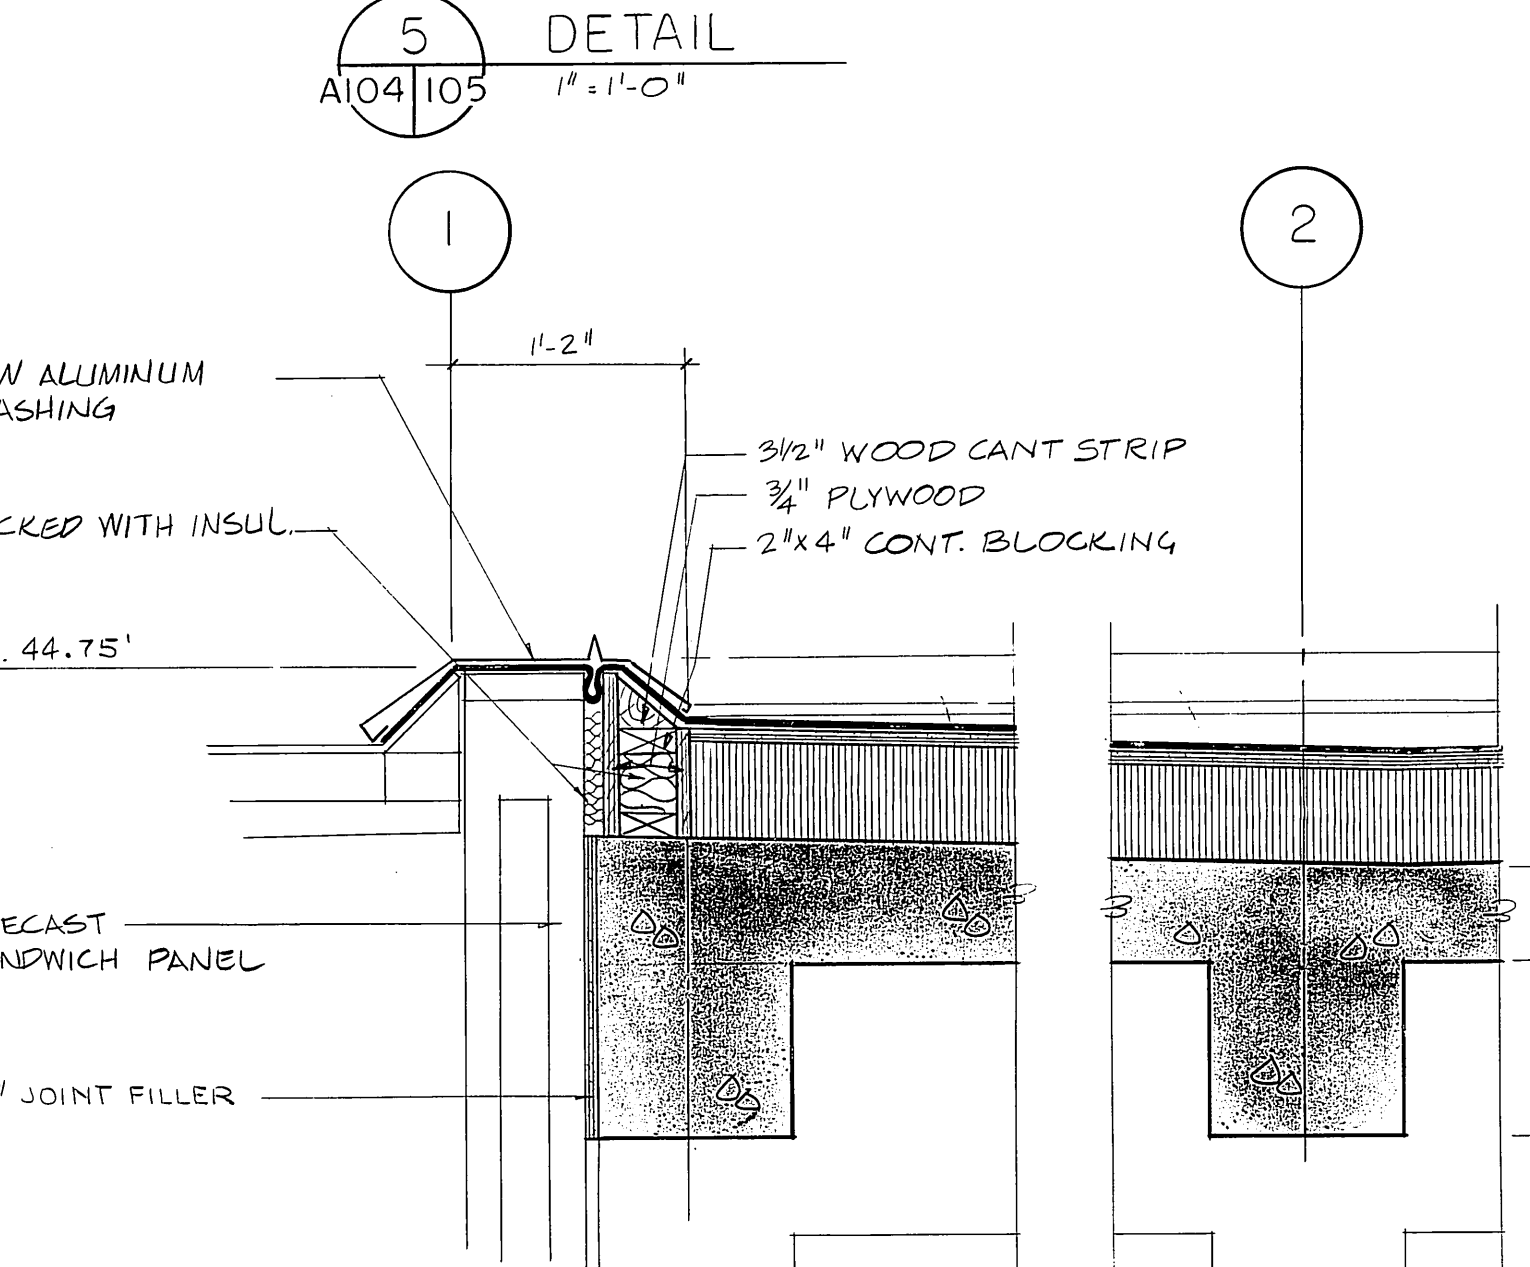

5 DETAIL
A104105 1" = 1'-0"

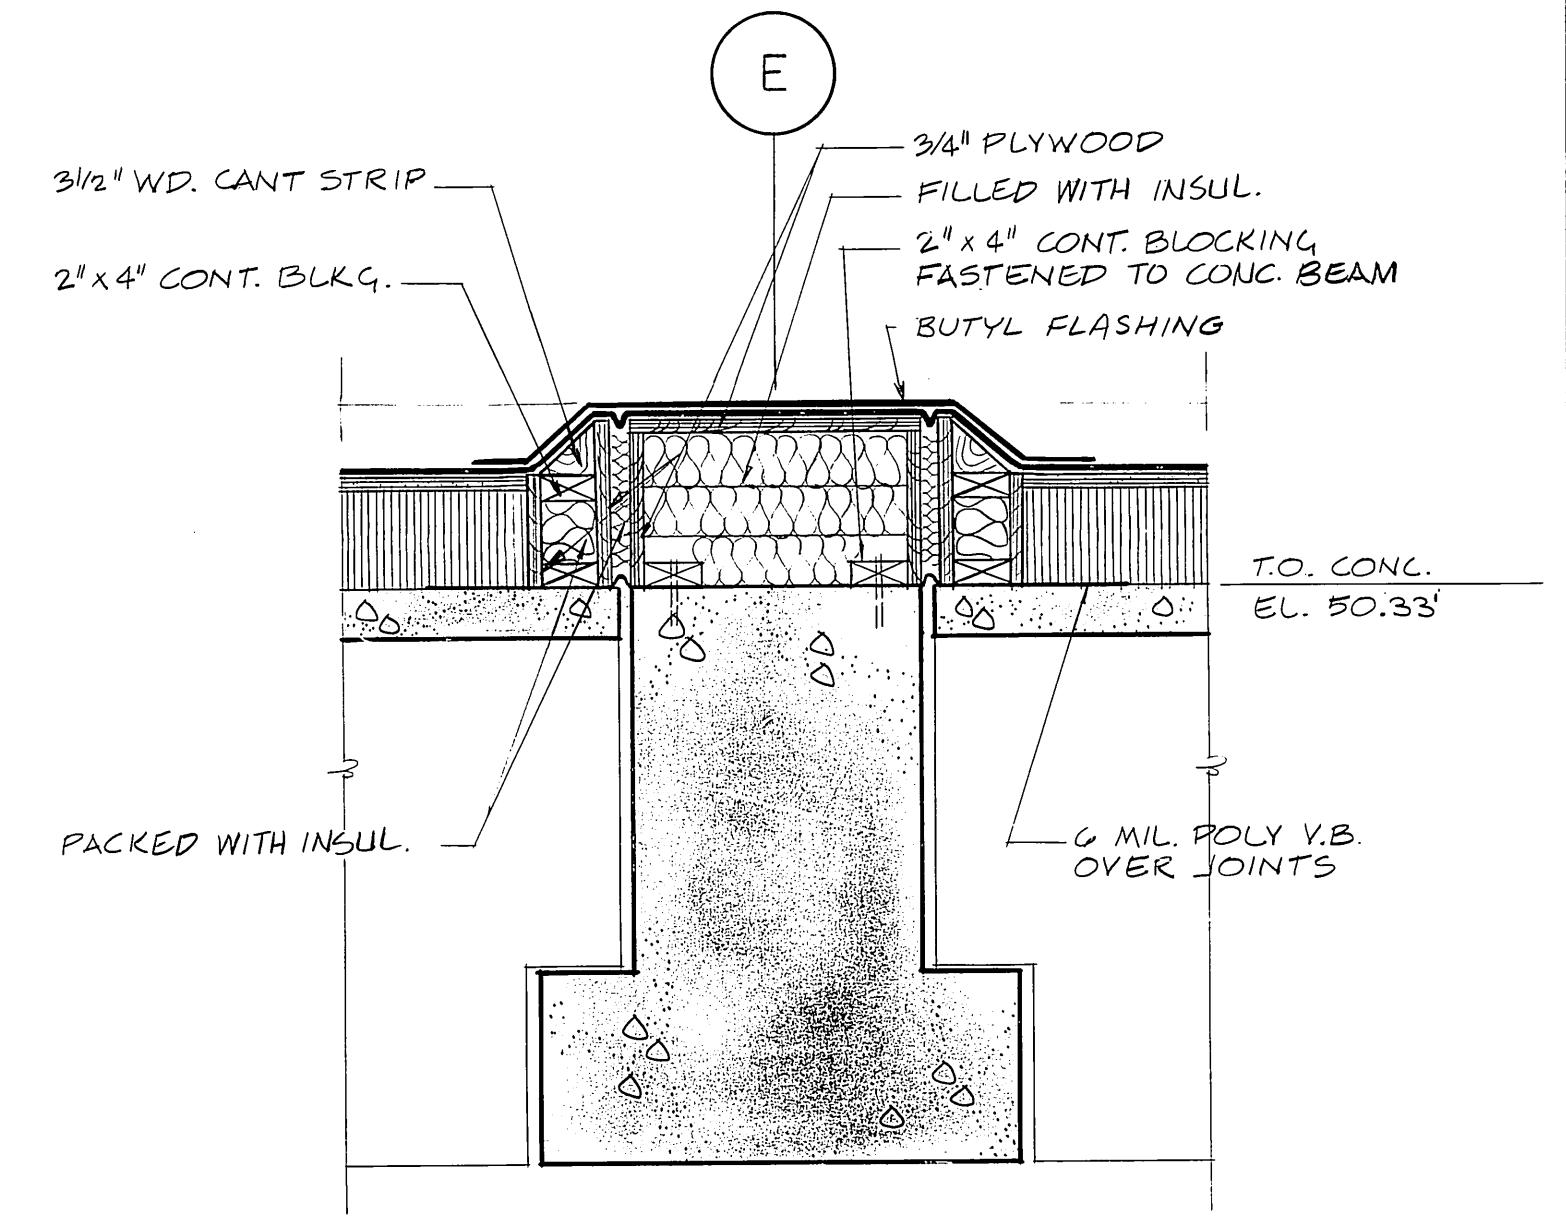

6 DETAIL
A104105 1" = 1'-0"

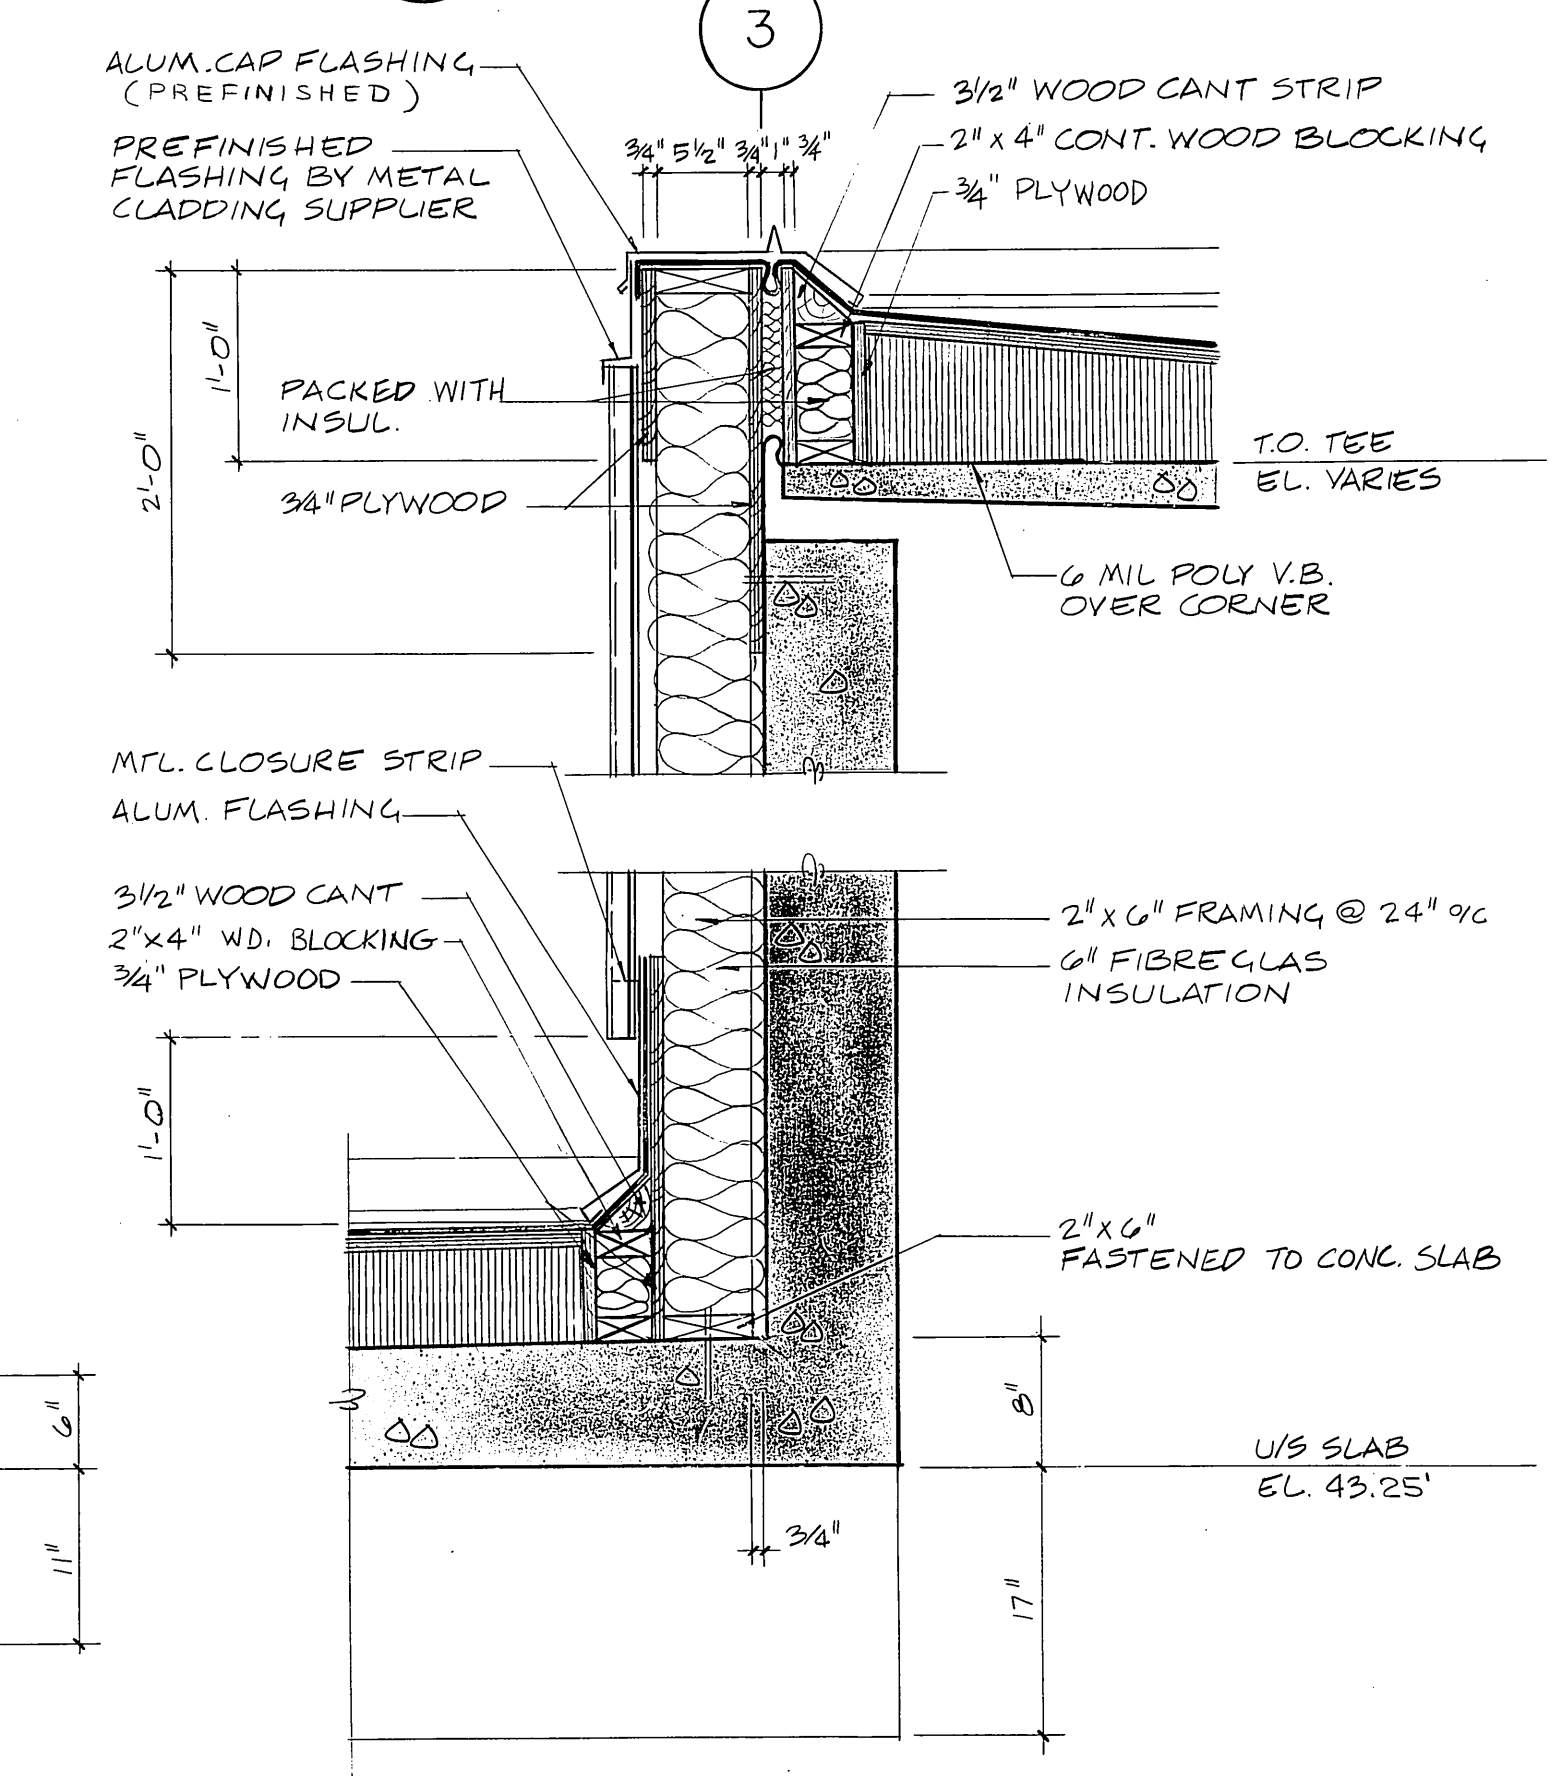


7 DETAIL
A104105 1" = 1'-0"

NOTES:
 1) FOR GENERAL NOTES REFER TO DWG. 76012-05-5112

MICROFILMED MAR 31 1980

NO.	DATE	DESCRIPTION
0	AS BUILT	ISSUED FOR TENDER
1	1978	ISSUED FOR TENDER

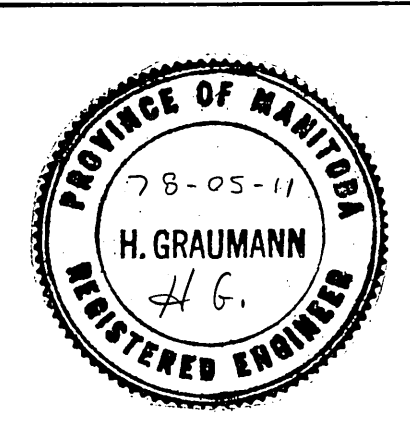

NO.	DATE	DESCRIPTION
0	AS BUILT	ISSUED FOR TENDER
1	1978	ISSUED FOR TENDER

W. L. WARDROP & ASSOCIATES LTD.
 JAMES F. MACLAREN LIMITED
 ENGINEERING CONSULTANTS

DRAWN BY: R.N.
 DESIGNED BY: J.K.
 CHECKED BY: H.G.
 APPROVED BY: J. Maguire

THE CITY OF WINNIPEG
 WORKS & OPERATIONS DEPARTMENT
 WATERWORKS, WASTE & DISPOSAL DIVISION

NORTH END WATER POLLUTION CONTROL CENTRE
 PRIMARY CLARIFIER ADDITION
 ARCHITECTURAL
 WALL SECTIONS & DETAILS

SCALE: AS SHOWN
 DATE: MAY 1978
 CONSULTANT DRAWING NO. 76012-05-A105
 CITY DRAWING NO. NEP-928

NR11104