




FAN HOUSE ELEVATIONS
SCALE 1:100

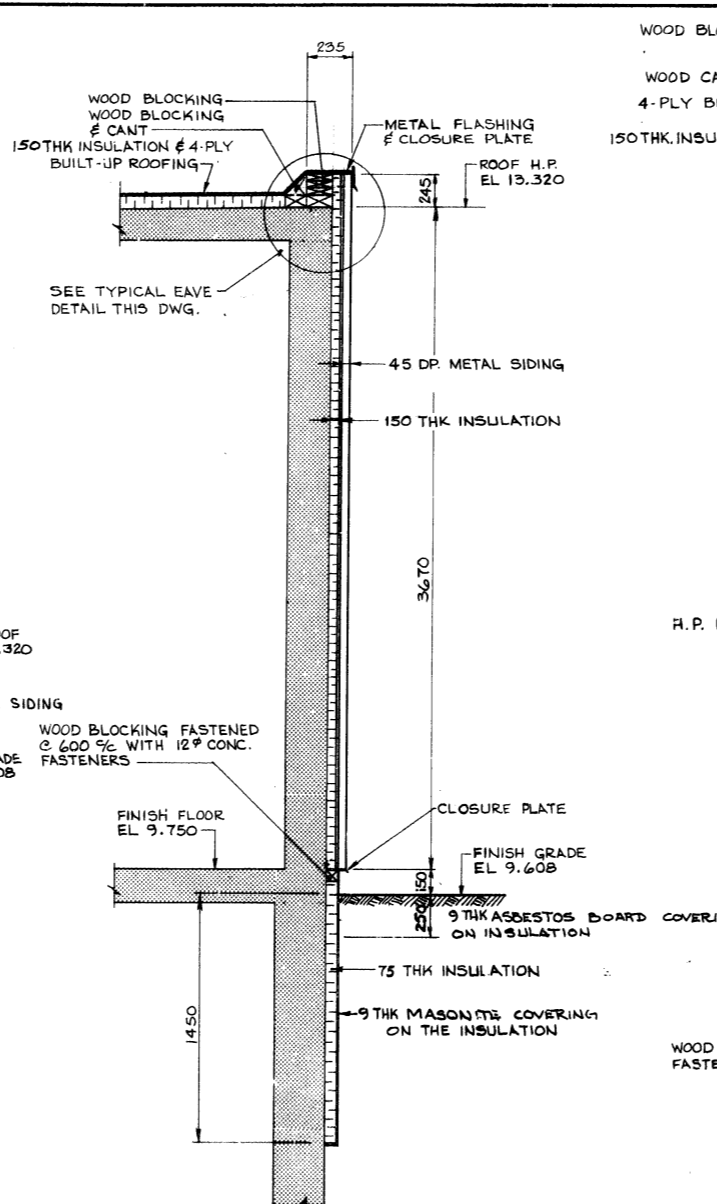


TYPICAL WALL SECTION (FAN HOUSE)
SCALE 1:20

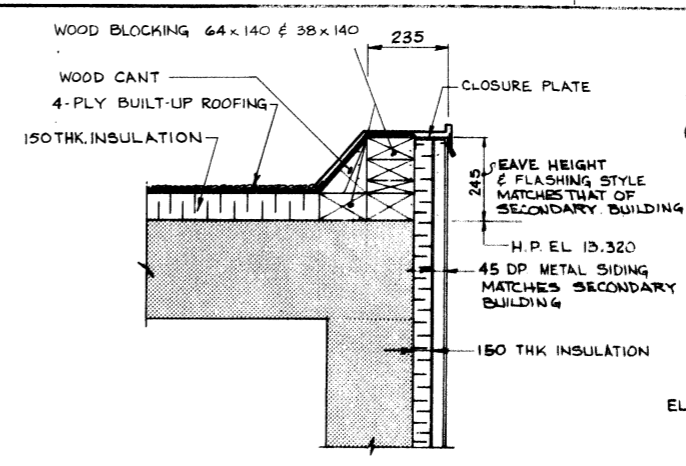


TYPICAL EAVE DETAIL
SCALE 1:10

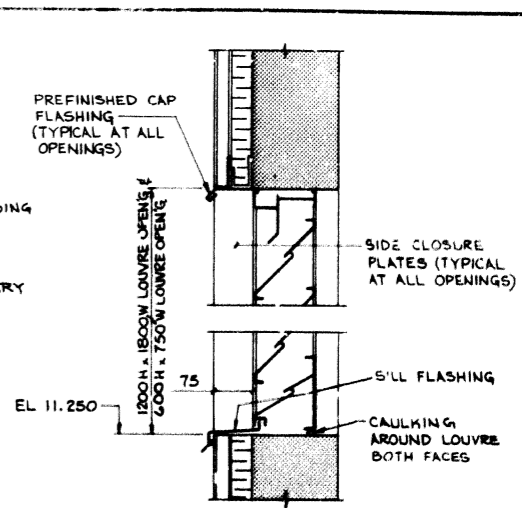


LOUVRE DETAIL
SCALE 1:10

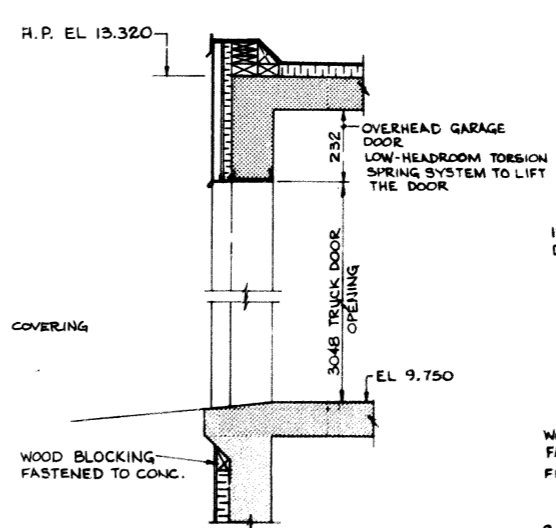


TRUCK DOOR DETAIL
SCALE 1:20

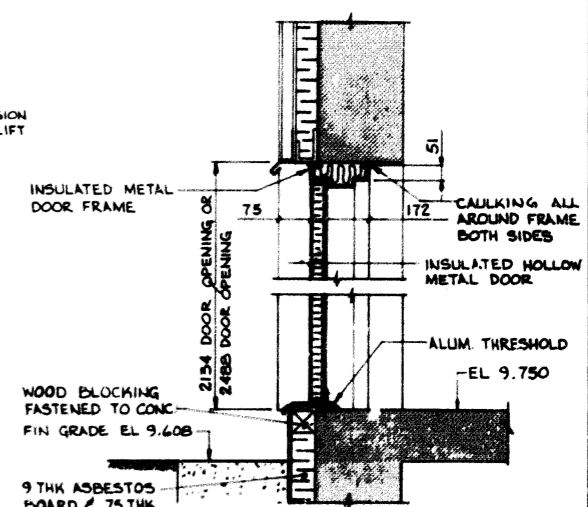


TYPICAL MAN DOOR DETAIL
SCALE 1:10

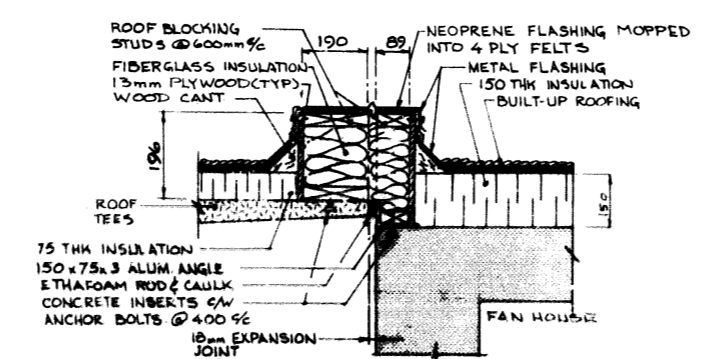

ROOF EXPANSION JOINT DETAIL
SCALE 1:10

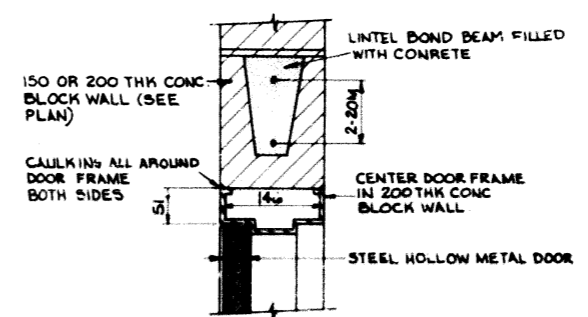

TYPICAL DOOR LINTEL DETAIL
SCALE 1:5

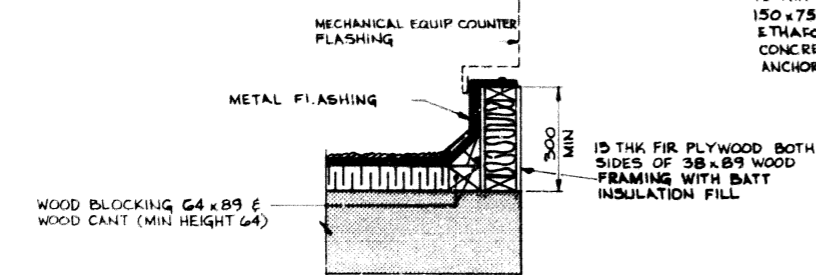


DETAIL 2
SCALE 1:10

AS - BUILT	
DATE	PR. NO. / PAGE
MAY 88	

NO.	REVISIONS	DATE	APP.
1	AS CONSTRUCTED	MAY 88	
2	ISSUED FOR TENDER	SEPT 85	
3	ISSUED FOR CLIENT REVIEW	SEPT 85	



W.L. WARDROP & ASSOCIATES LTD. MacLAREN ENGINEERS INC.	
DESIGNED BY J.P.S.	DRAWN BY J.P.S.
CHECKED BY A.L.	DATE SEPT 1985

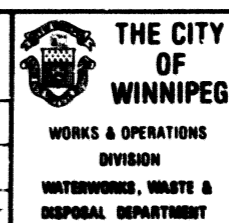

NORTH END WATER POLLUTION CONTROL CENTRE SECONDARY TREATMENT EXPANSION SECONDARY CLARIFIERS - STRUCTURAL FAN HOUSE EXTERIOR FINISH DETAILS	
RELEASED FOR CONSTRUCTION	DATE
AS SHOWN	DRAWING NO. NEP 1398

METRIC
WHOLE NUMBERS INDICATE MILLIMETRES
DECIMALIZED NUMBERS INDICATE METRES