


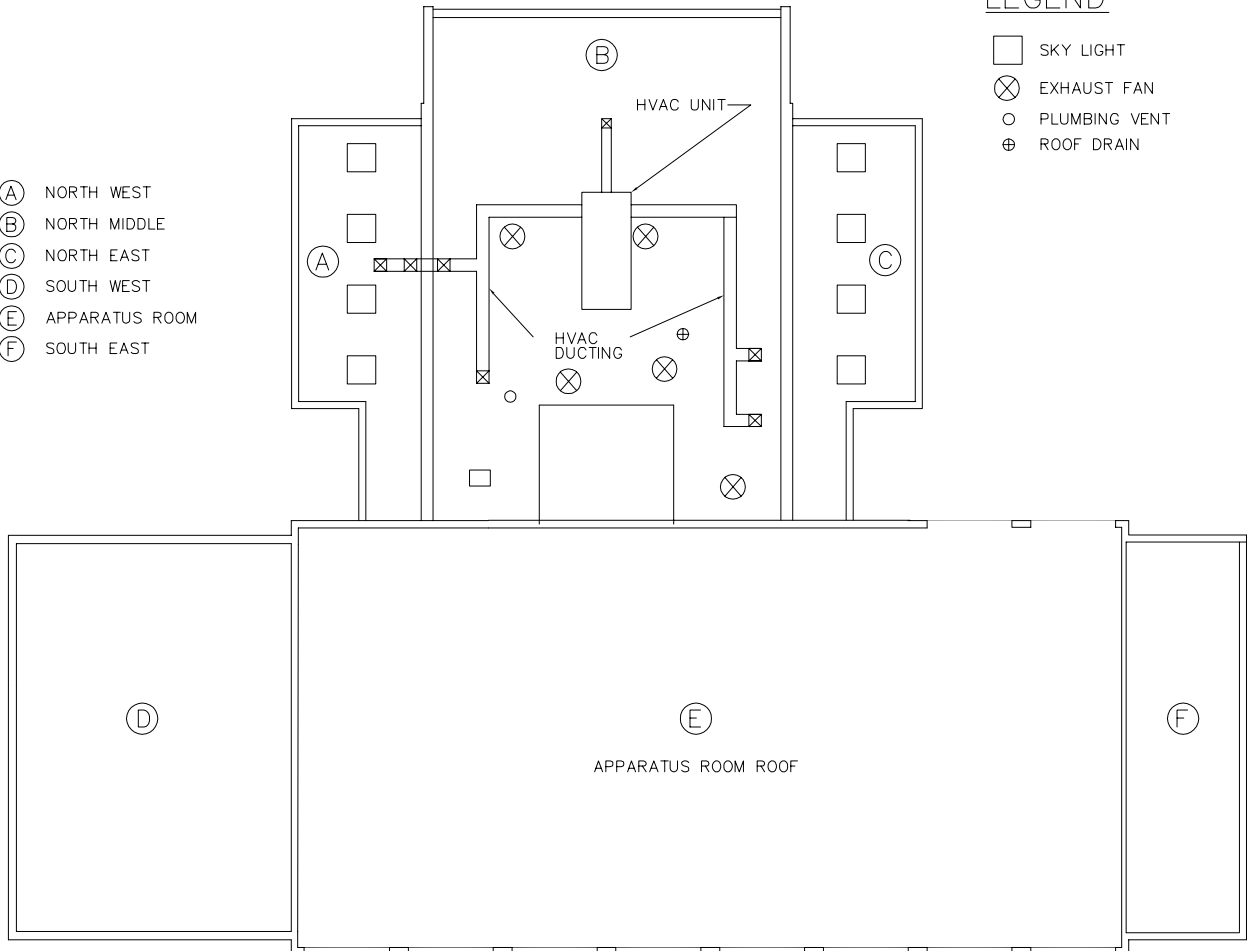

- (A) NORTH WEST
- (B) NORTH MIDDLE
- (C) NORTH EAST
- (D) SOUTH WEST
- (E) APPARATUS ROOM
- (F) SOUTH EAST

LEGEND

- SKY LIGHT
- ⊗ EXHAUST FAN
- PLUMBING VENT
- ⊕ ROOF DRAIN



CITY OF WINNIPEG
 PLANNING, PROPERTY AND
 DEVELOPMENT DEPARTMENT
 CIVIC ACCOMMODATIONS DIVISION
 300-65 GARRY STREET R3C 4K4

PROJECT
 FIRE PARAMEDIC SERVICE
 FIRE STATION NO. 1
 65 ELLEN STREET

SHEET TITLE
 ROOF PLAN

DRAWN BY

MBD

CHECKED BY

LR

APPROVED BY

LR

DATE

2007.04.19

eFILE

200026A1 .dwg

SCALE

1/8" = 1'-0"

PROJECT

NO. 2007-026

SHEET NO.

A1