 

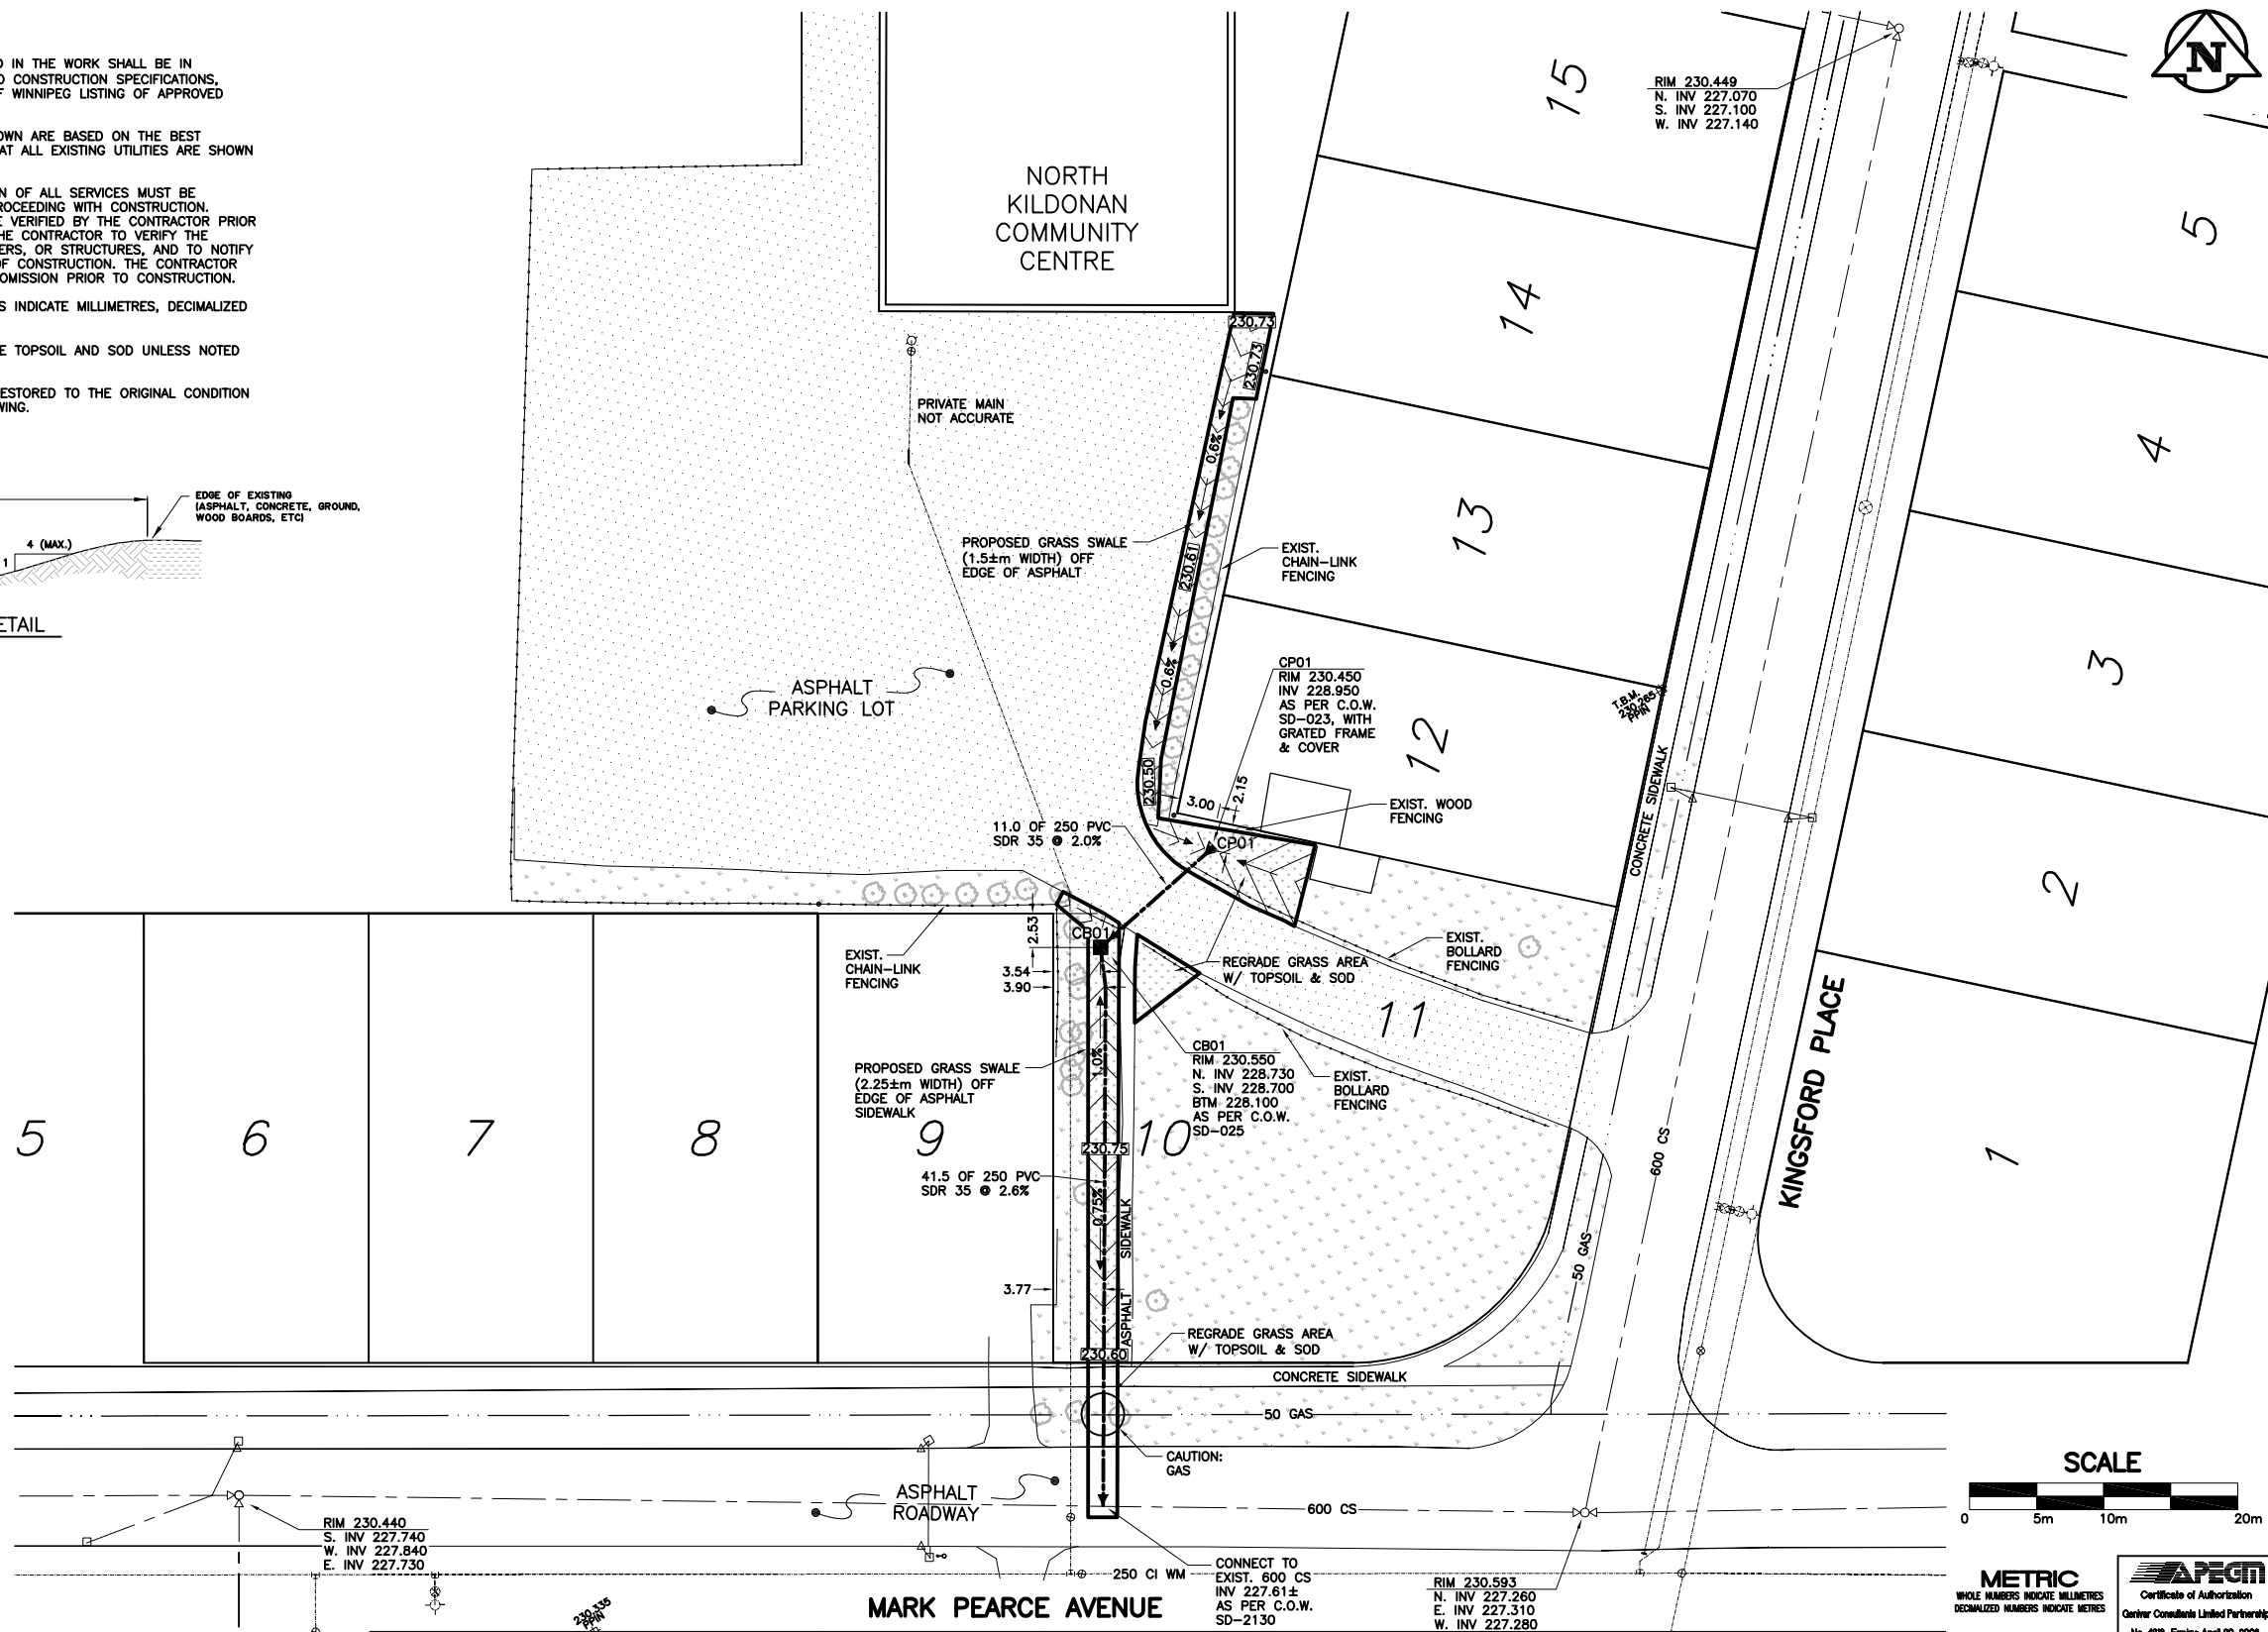


CONSTRUCTION NOTES:

1. ALL CONSTRUCTION AND PRODUCTS INCORPORATED IN THE WORK SHALL BE IN ACCORDANCE WITH THE CITY OF WINNIPEG "STANDARD CONSTRUCTION SPECIFICATIONS, LATEST EDITION, AND BE REGISTERED IN THE CITY OF WINNIPEG LISTING OF APPROVED PRODUCTS.
2. LOCATION OF UNDERGROUND STRUCTURES AS SHOWN ARE BASED ON THE BEST INFORMATION AVAILABLE. NO GUARANTEE IS GIVEN THAT ALL EXISTING UTILITIES ARE SHOWN OR THAT THE GIVEN LOCATIONS ARE EXACT.
3. CONFIRMATION OF EXISTENCE AND EXACT LOCATION OF ALL SERVICES MUST BE OBTAINED FROM THE INDIVIDUAL UTILITIES BEFORE PROCEEDING WITH CONSTRUCTION. LOCATION AND ELEVATION OF EXISTING WORKS TO BE VERIFIED BY THE CONTRACTOR PRIOR TO CONSTRUCTION. IT IS THE RESPONSIBILITY OF THE CONTRACTOR TO VERIFY THE LOCATIONS OF SUCH UTILITIES, PIPES, SURVEY MARKERS, OR STRUCTURES, AND TO NOTIFY ALL RELEVANT UTILITIES PRIOR TO COMMENCEMENT OF CONSTRUCTION. THE CONTRACTOR SHALL NOTIFY THE CONSULTANT OF ANY ERROR OR OMISSION PRIOR TO CONSTRUCTION.
4. MEASUREMENTS ARE IN METRIC. WHOLE NUMBERS INDICATE MILLIMETRES, DECIMALIZED NUMBERS INDICATE METRES.
5. ALL REGRADED/DISTURBED SOD AREAS TO RECEIVE TOPSOIL AND SOD UNLESS NOTED OTHERWISE.
6. ALL AREAS AFFECTED BY CONSTRUCTION TO BE RESTORED TO THE ORIGINAL CONDITION OR BETTER UNLESS NOTED OTHERWISE ON THE DRAWING.

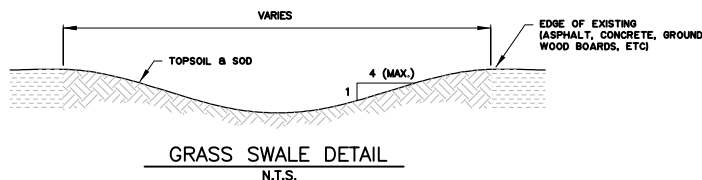

METRIC
WHOLE NUMBERS INDICATE MILLIMETRES
DECIMALIZED NUMBERS INDICATE METRES

APEGM
Certificate of Authorization
Ontario-Canada Limited Partnership
No. 438 Expiry April 30, 2008

150 mm WM	WATERMAIN	150 mm WM	HYDRO	150 mm WM	WATERMAIN
Hydrant	HYDRANT	MTS	MTS	Hydrant	HYDRANT
Valve	VALVE	Grass	Grass	Valve	VALVE
250 mm LDS	LAND DRAINAGE SEWER	Swale	SWALE	300 mm LDS	SEWER
250 mm CS	COMBINED SEWER	Curb Renewal	CURB RENEWAL		
Manhole	MANHOLE	Asphalt	ASPHALT		
Catch Basin (CB)	CATCH BASIN (CB)	Elevations	ELEVATIONS		
Catch Pit (CP)	CATCH PIT (CP)	Property Line	PROPERTY LINE		
Sign	SIGN	Survey Bar	SURVEY BAR		
Lamp Standard	LAMP STANDARD	Curb Stop	CURB STOP		
Gas	GAS	Ramp Curb	RAMP CURB		
EXISTING	LEGEND - PLAN	NEW	EXISTING	LEGEND - PLAN	NEW
				LEGEND - PROFILE	NEW

LOCATION APPROVED UNDERGROUND STRUCTURES

DATE: _____

NOTE:
LOCATION OF UNDERGROUND STRUCTURES AS SHOWN ARE BASED ON THE BEST INFORMATION AVAILABLE. BUT NO GUARANTEE IS GIVEN THAT ALL EXISTING UTILITIES ARE SHOWN OR THAT THE GIVEN LOCATIONS ARE EXACT. CONFIRMATION OF EXISTENCE AND EXACT LOCATION OF ALL SERVICES MUST BE OBTAINED FROM THE INDIVIDUAL UTILITIES BEFORE PROCEEDING WITH CONSTRUCTION.

T.B.M. 230.265m
N.E. CORNER OF LOT #12 KINGSFORD PLACE
1/2 INCH PROPERTY BAR LOCATED NEXT TO SIDEWALK.

ISSUED FOR TENDER	070703	WDM
NO. REVISIONS	DATE	BY

GENIVAR
600-5 DONALD STREET
WINNIPEG, MB R3L 2T4
Tel: (204)477-6650
Fax: (204)474-2864

DESIGNED BY: W.D.M.
CHECKED BY: D.T.B.
DRAWN BY: W.D.M.
APPROVED BY: B.D.E.

HOR. SCALE: 1:250
DATE: June 29, 2007

ENGINEER'S SEAL
PROVINCE OF MANITOBA
D.T. BLACKBURN
Member 23146
CONSULTANT DRAWING NO. 07093C02

THE CITY OF WINNIPEG
PUBLIC WORKS DEPARTMENT

NORTH KILDONAN C.C.
DRAINAGE IMPROVEMENT PROJECT
PROPOSED SITE PLAN

CITY DRAWING NUMBER 374-2007-C02
SHEET 2 OF 2
REV. 2 0

L:\Projects\2007\WE-07-093-WE\Drawings\02 Working Drawings\04 Civil\Tender drawings\374-2007_DRAWING_C02-RO.dwg, 7/4/2007 4:12:02 PM