




NORTHBOUND MAIN N/S ASSINIBOINE
STOP 10624 ASSINIBOINE

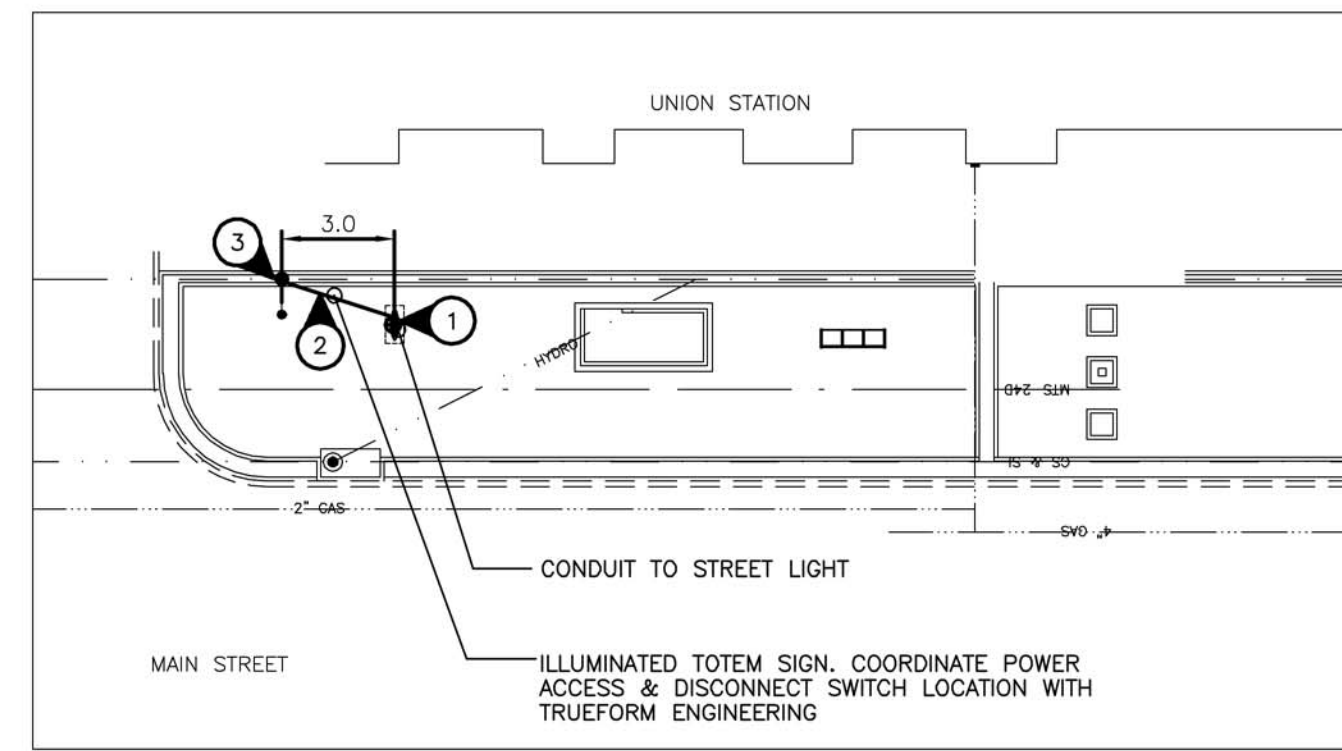


NORTHBOUND MAIN F/S BROADWAY
STOP 10625 UNION STATION

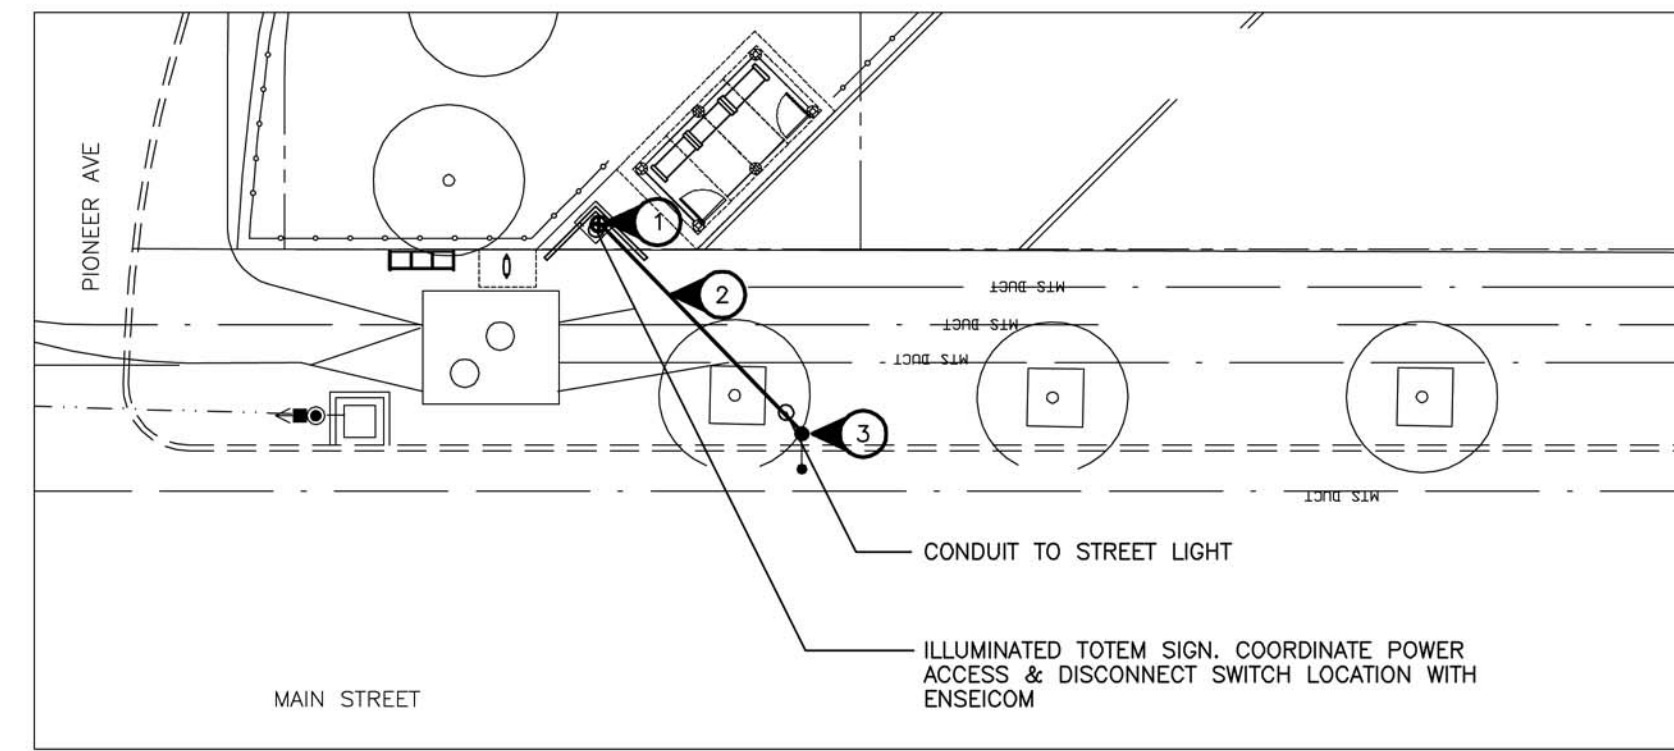


NORTHBOUND MAIN N/S PIONEER
STOP 10627 PIONEER

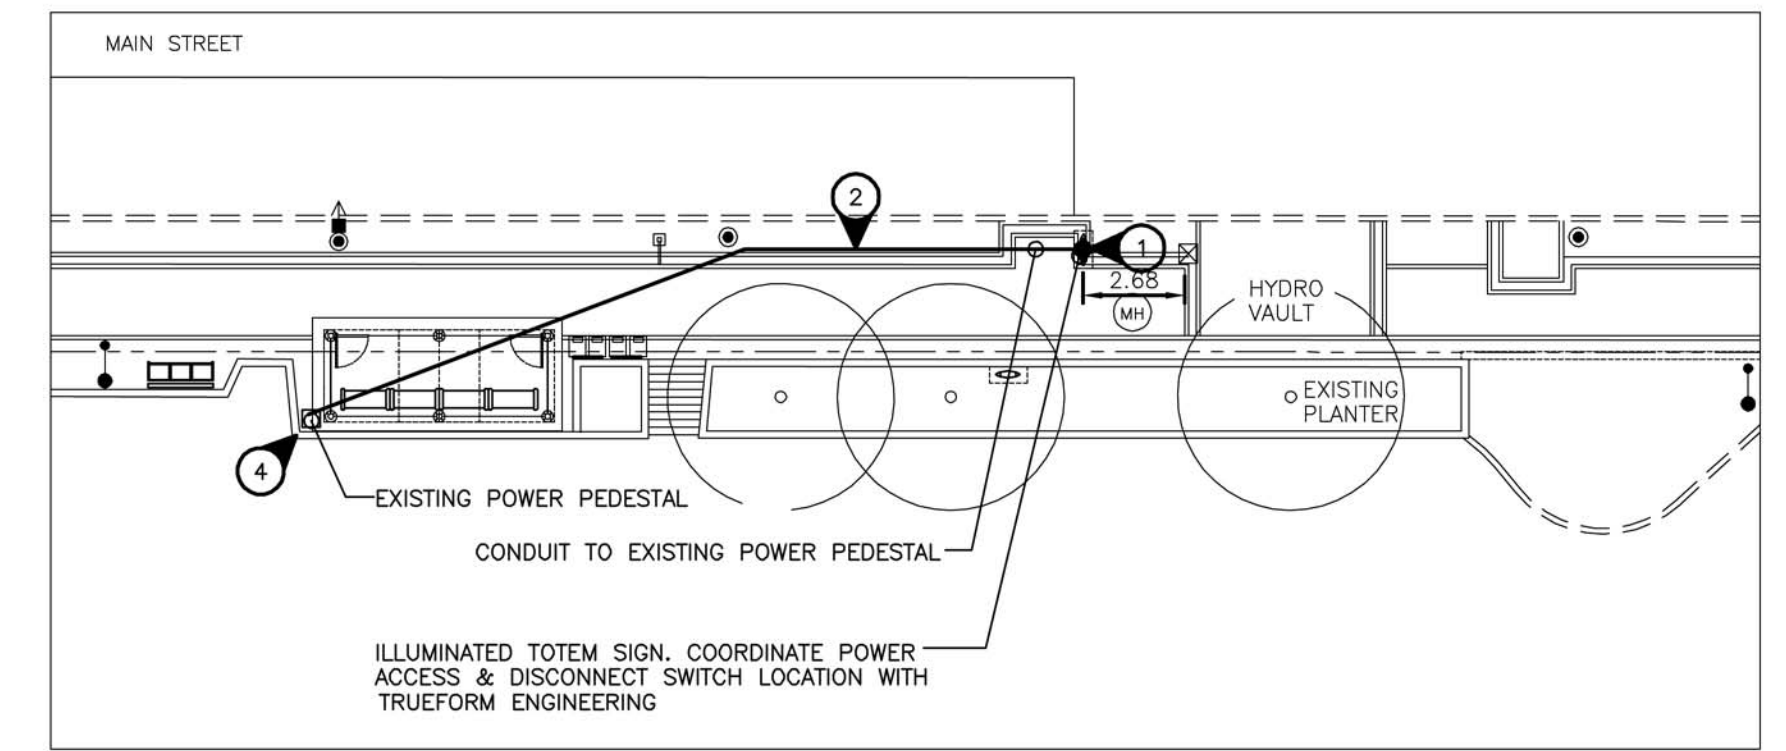


SOUTHBOUND MAIN F/S PIONEER
STOP 10638 PIONEER

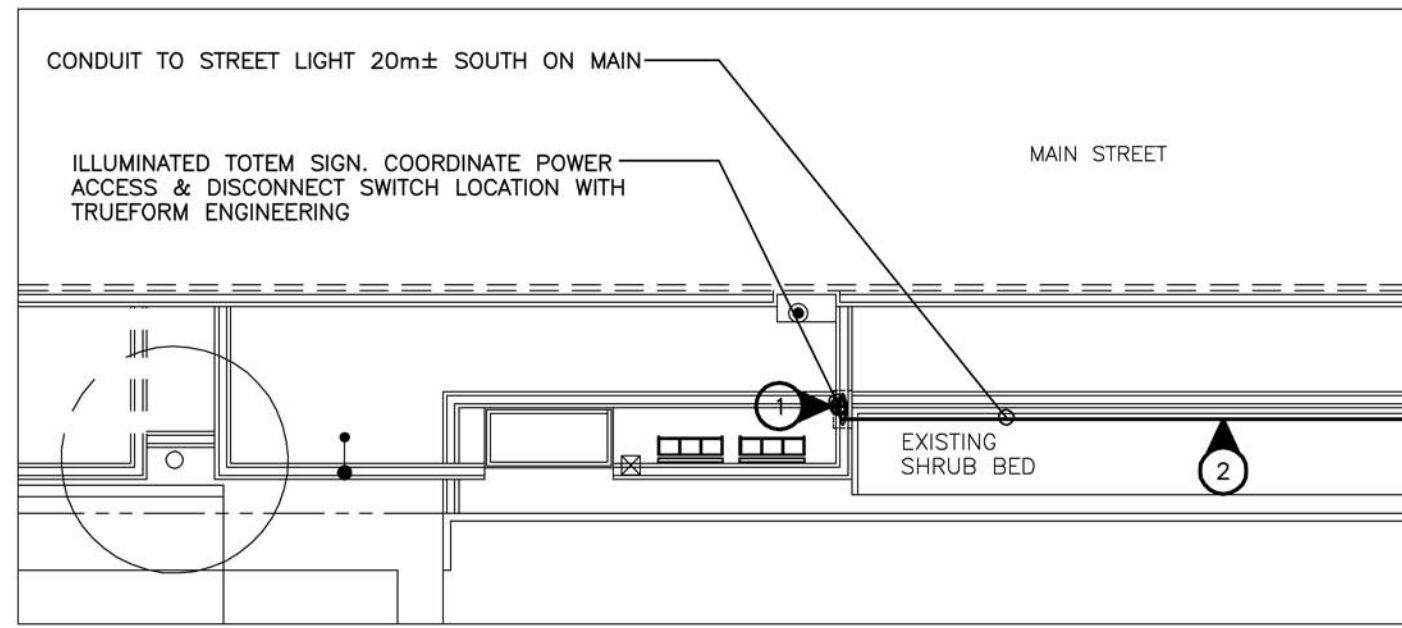


SOUTHBOUND MAIN N/S ASSINIBOINE
STOP 10642 ASSINIBOINE

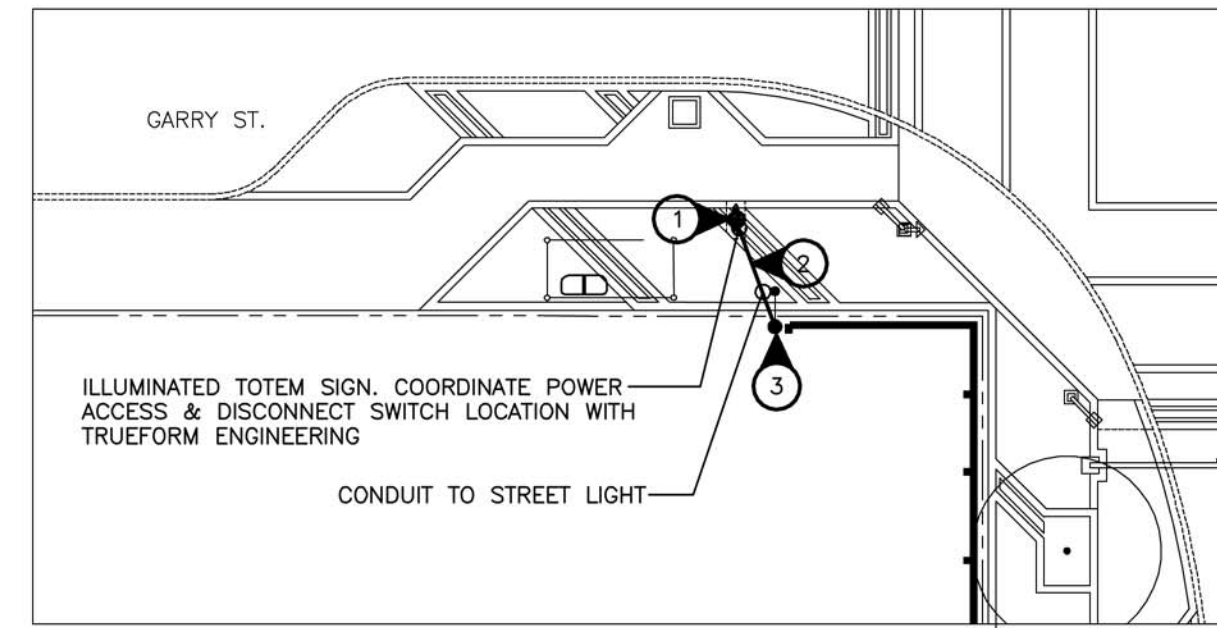


SOUTHBOUND GARRY N/S GRAHAM
STOP 10650 GRAHAM

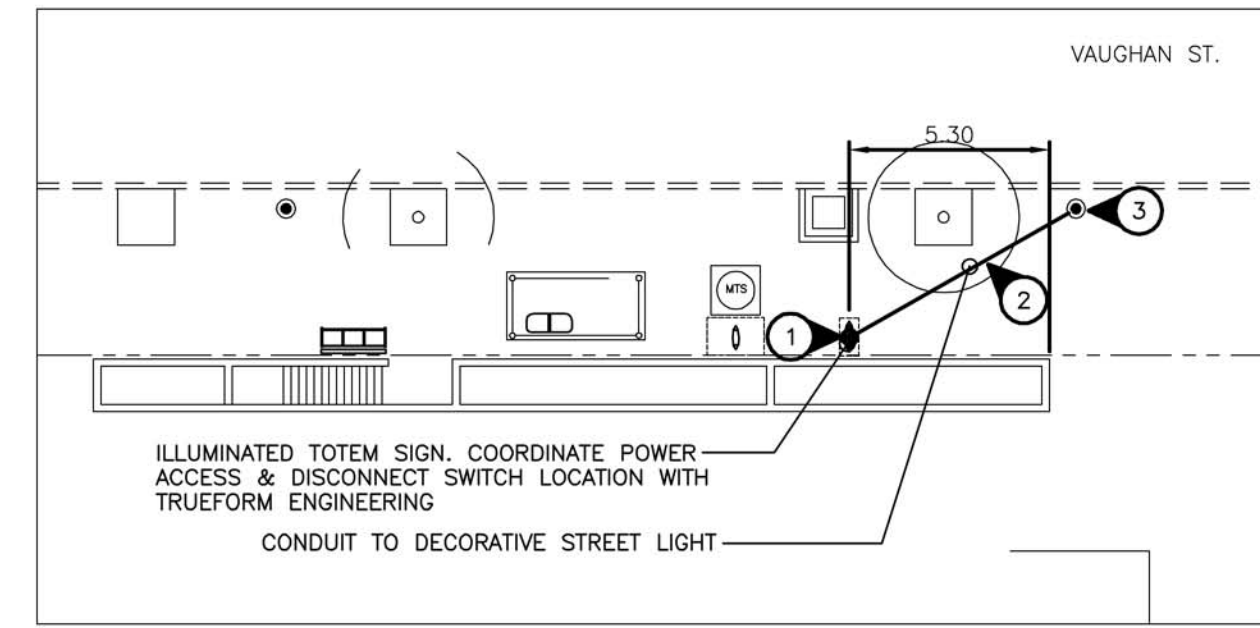


SOUTHBOUND VAUGHAN N/S PORTAGE
STOP 10132 PORTAGE

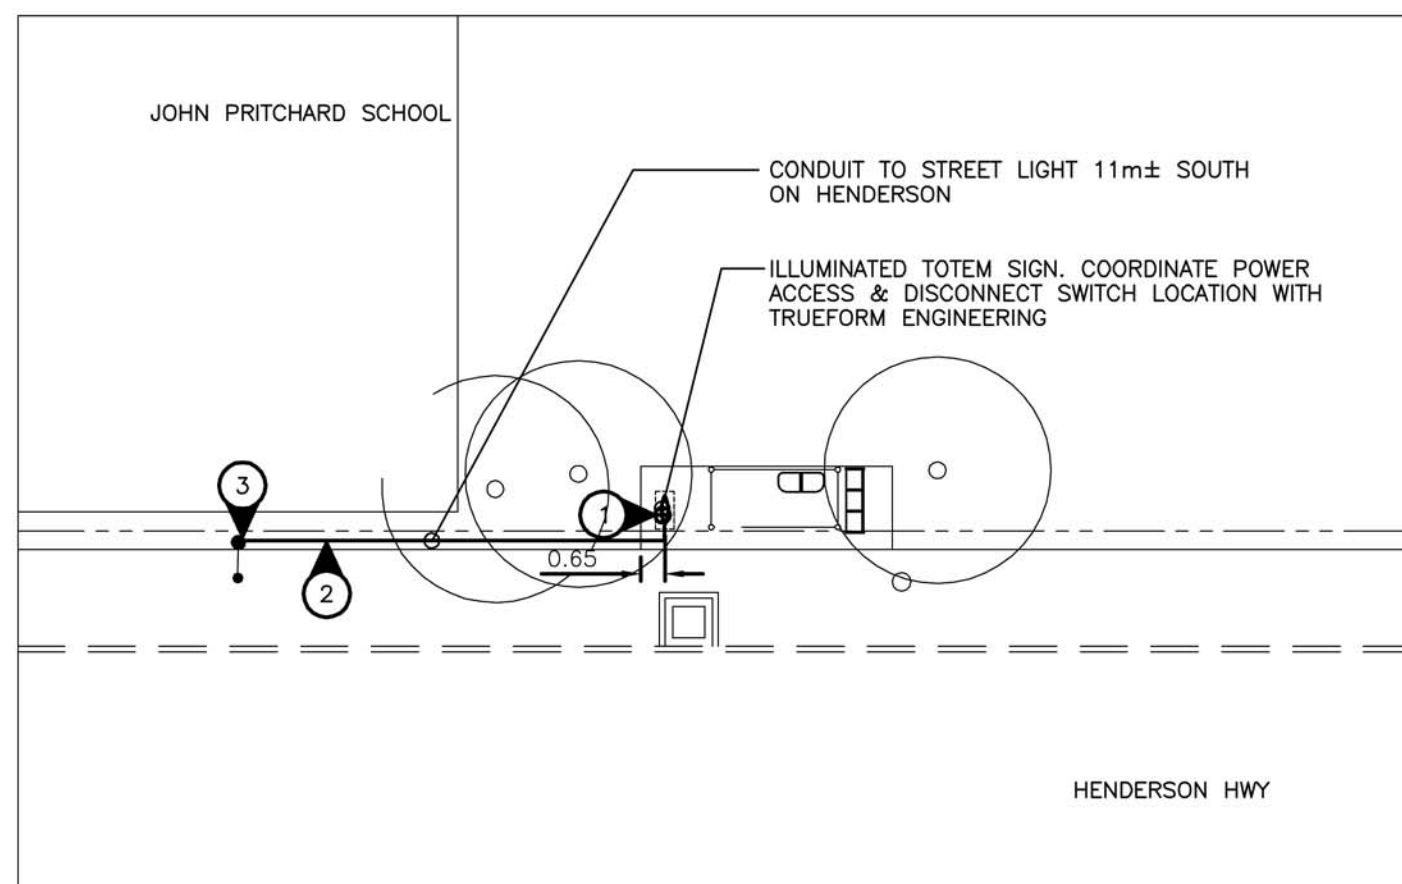


SOUTHBOUND HENDERSON N/S WHELLAMS
STOP 40415 WHELLAMS

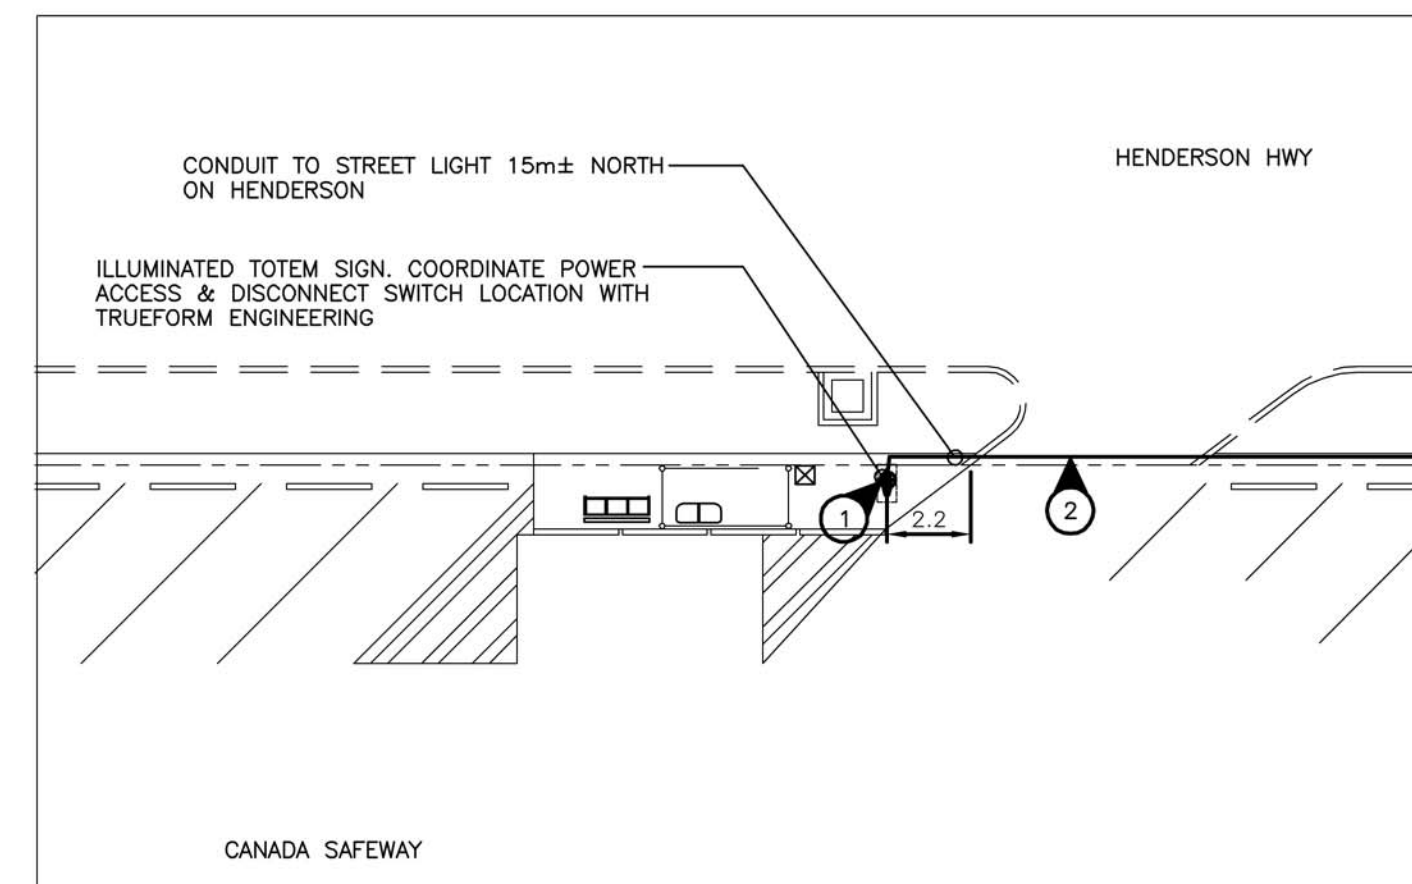

NORTHBOUND HENDERSON N/S KIMBERLEY
STOP 40379 KIMBERLEY

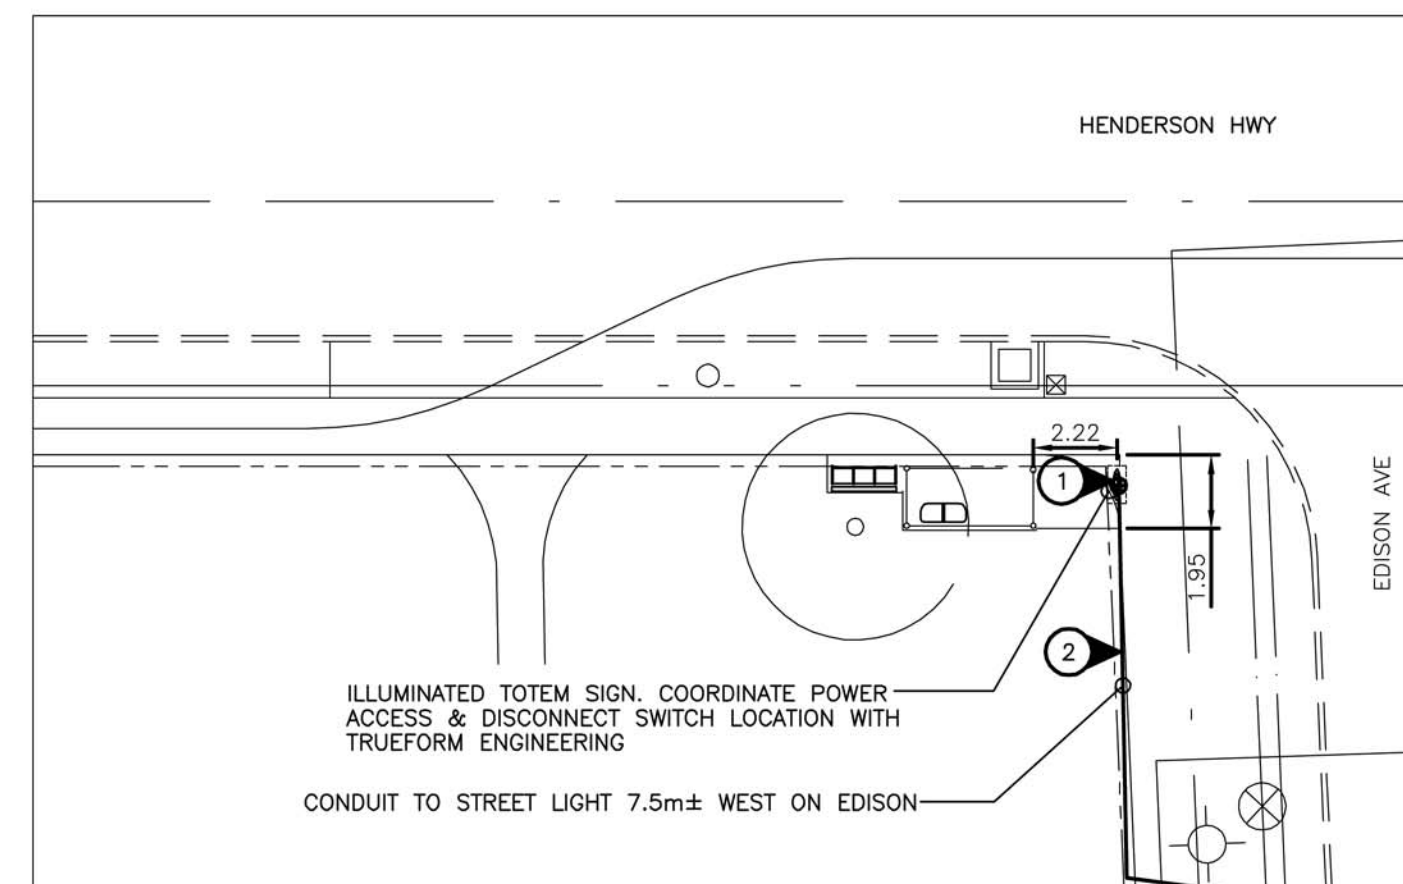

NORTHBOUND HENDERSON N/S EDISON
STOP 40390 EDISON

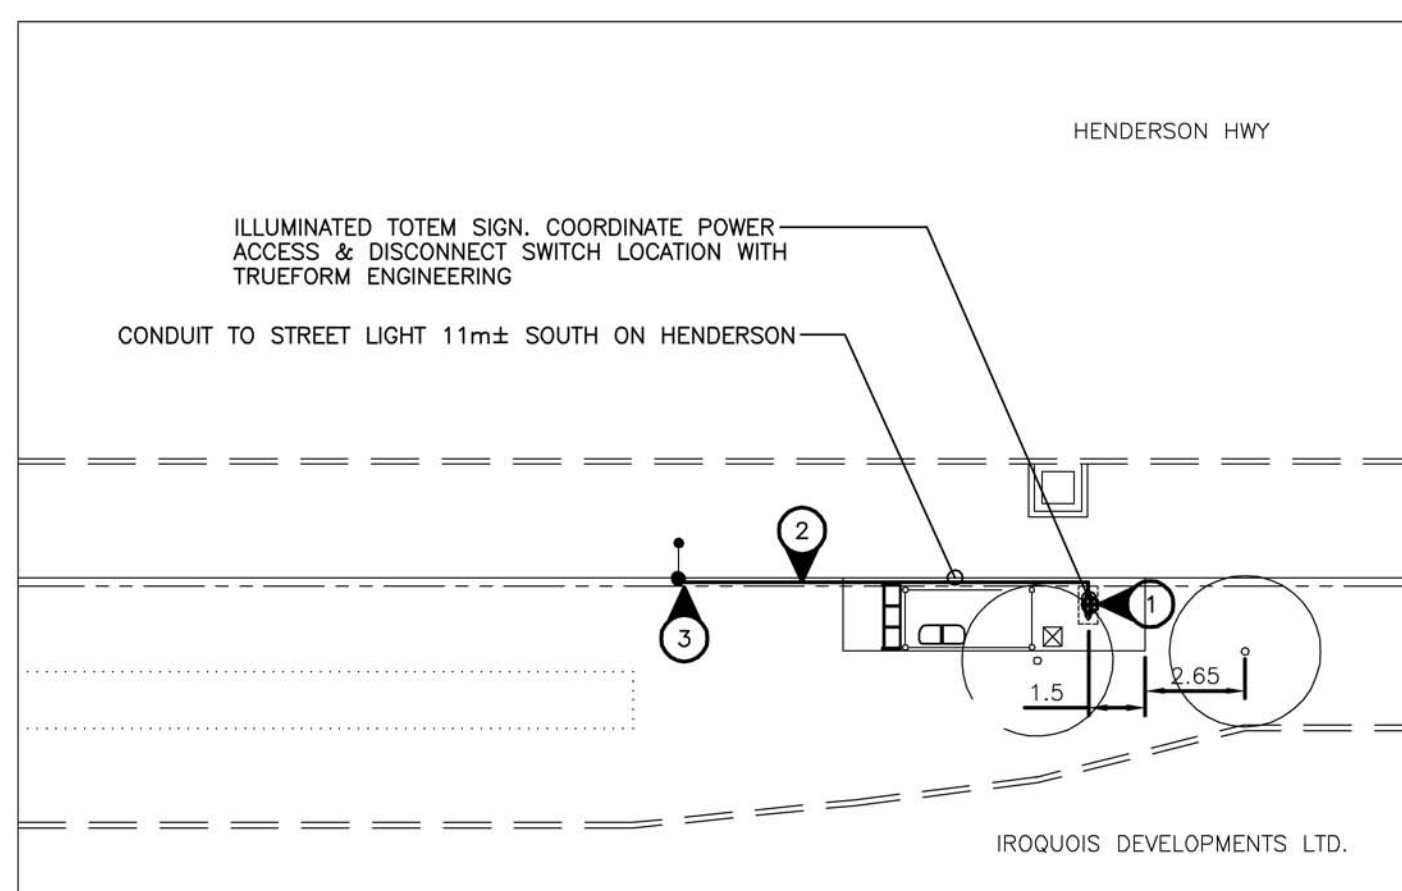



NORTHBOUND HENDERSON OPP. WHELLAMS
STOP 40393 WHELLAMS



SPECIFIC ELECTRICAL NOTES


- 1 WIRE & CONNECT ILLUMINATED TRANSIT SIGN AS REQUIRED. COORDINATE EXACT LOCATION AND REQUIREMENTS WITH SIGNAGE SUPPLIER.
- 2 BURIED 2 #12 RWJ-90 CU AND GROUND IN A 25mm RIGID PVC CONDUIT. PROVIDE TRENCHING, BACKFILLING AND SURFACE REPAIR AS REQUIRED. PUSH BELOW SURFACE WHERE PRACTICAL. PURCHASE CONDUIT FROM MB HYDRO.
- 3 CONNECT NEW SIGN TO EXISTING STREET LIGHT INDICATED. PROVIDE A 15A-2P WEATHER-PROOF SERVICE ENTRANCE RATED DISCONNECT AT SIGN (240V-1FH). FPE RH 102-2.
- 4 PROVIDE A MATCHING 15A-1P C.B. IN EXISTING POWER PEDESTAL FOR SIGN LIGHTING CIRCUIT. CIRCUIT TO BE PHOTOCELL CONTROLLED.

0	ISSUED FOR PERMIT	08/05/07	DZ
No.	Revisions	Date	By
Date Scale 08-05-07 1:200			
Designed By	DZ	Drawn By	JW/SL
		Checked By	DZ

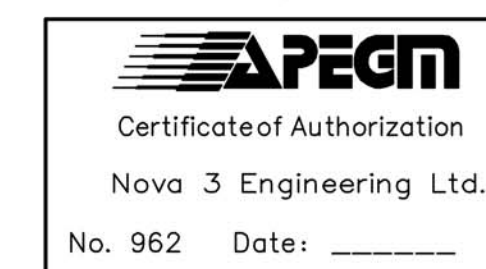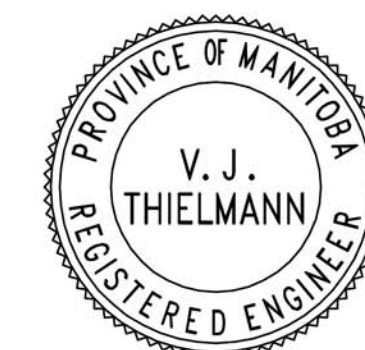

NOVA 3 ENGINEERING LTD.
CONSULTING ENGINEERS
201-120 FORT STREET WINNIPEG, MANITOBA R3C 1C7
TEL: (204) 943-6142 FAX: (204) 942-1276

THIS DRAWING IS THE EXCLUSIVE PROPERTY OF NOVA 3 ENGINEERING LTD. AND MAY ONLY BE REPRODUCED WITH THE WRITTEN PERMISSION OF NOVA 3 ENGINEERING LTD. THE CONCEPT AND DESIGN INCORPORATED INTO THIS DRAWING ARE BASED ON INFORMATION PROVIDED BY THE CLIENT AND OTHER RELATED SOURCES. PROFESSIONAL ENGINEER ACCEPTS NO RESPONSIBILITY FOR DRAWING AND DESIGN UNLESS DRAWING IS ACCOMPANIED BY ORIGINAL SEALED AND SIGNED LETTER OF INTENT AND CERTIFICATE OF INSPECTION.

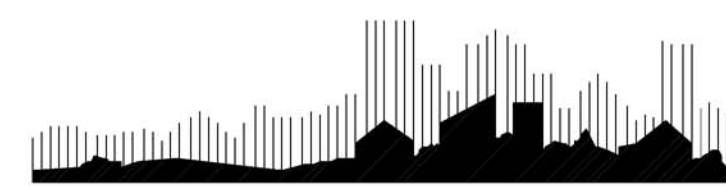

McGOWAN RUSSELL
Client

WINNIPEG TRANSIT
Project Title
BUS STOP UPGRAD PROGRAM PHASE 2 ELECTRICAL WORK

Sheet Title
ELECTRICAL PLANS

Project No. 27-098 Drawing No. E-1