


# Notes:

1. Supply & install new 120 / 208V, 30 cct. panel LP-4A.
2. Relocate 3 existing 15A 1P bkr. from Panel LP-4, cct. 37,39 & 41 to new Panel LP-4A.
3. Supply & install new 60A 3P bkr. cct. 37,39,41 in Panel LP-4 & 4/C #6 in 1" EMT to new Panel LP-4A.
4. Supply & install 2 new 15A 3P bkr. in LP-4A for new pumps PU-1 & PU-2.
5. Supply & install 2-#12 from each pool temperature sensor to control Boiler Pumps. Sensor 1 to control PU-1 & Sensor 2 to control PU-2.

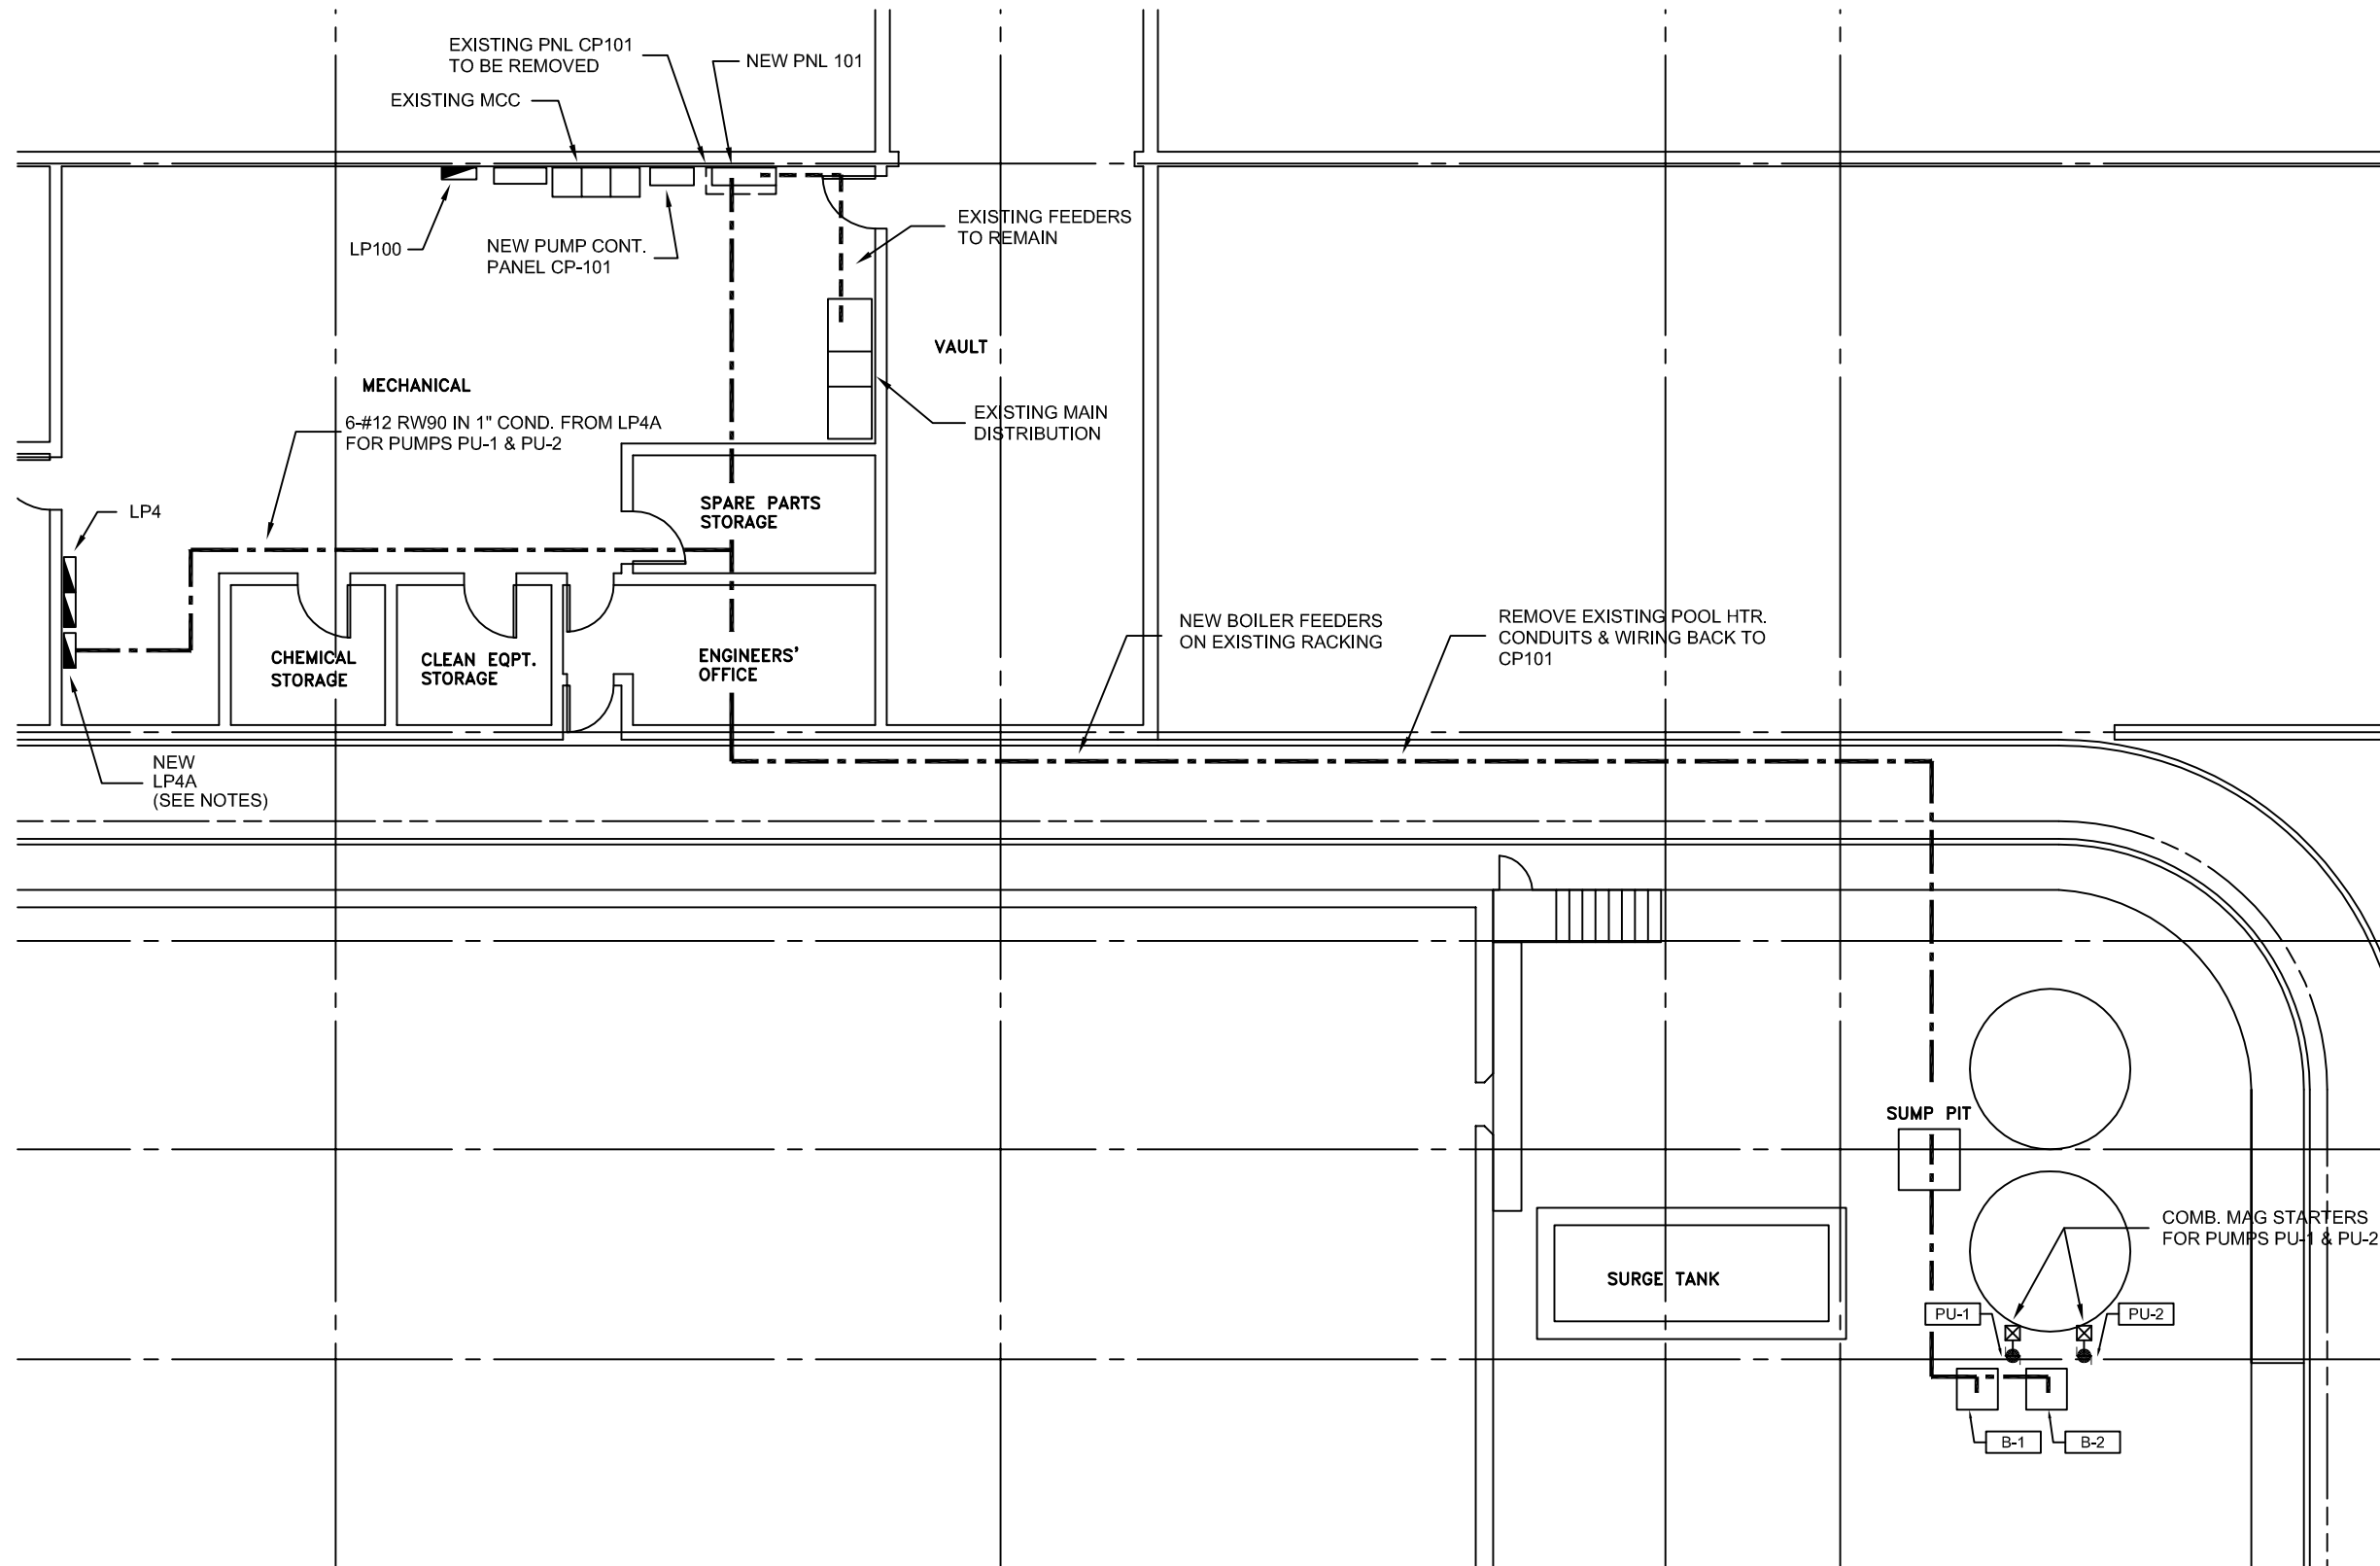

**BASEMENT FLOOR PLAN**  
SCALE: 3/32" = 1'-0"

0 07/06/07 ISSUED FOR TENDER & CONSTRUCTION  
No. DATE ISSUANCE  
Seal



**A.J. Dunsmore Engineering**  
CONSULTING ELECTRICAL ENGINEER  
221 Kerr Ave., Dauphin, MB  
R7N 3J5

Client

**CITY OF WINNIPEG  
BUILDING SERVICES**

Project  
CINDY KLASSEN RECREATION COMPLEX  
POOL BOILER INSTALLATION  
BID OPPORTUNITY# 434-2007

Sheet Title

ELECTRICAL  
FLOOR PLAN

SCALE: AS SHOWN

PROJECT NO: 2007-13

**E-1**