


MAIN FLOOR PLAN - LIGHTING

0 1000 2000 3000 mm SCALE 1:100

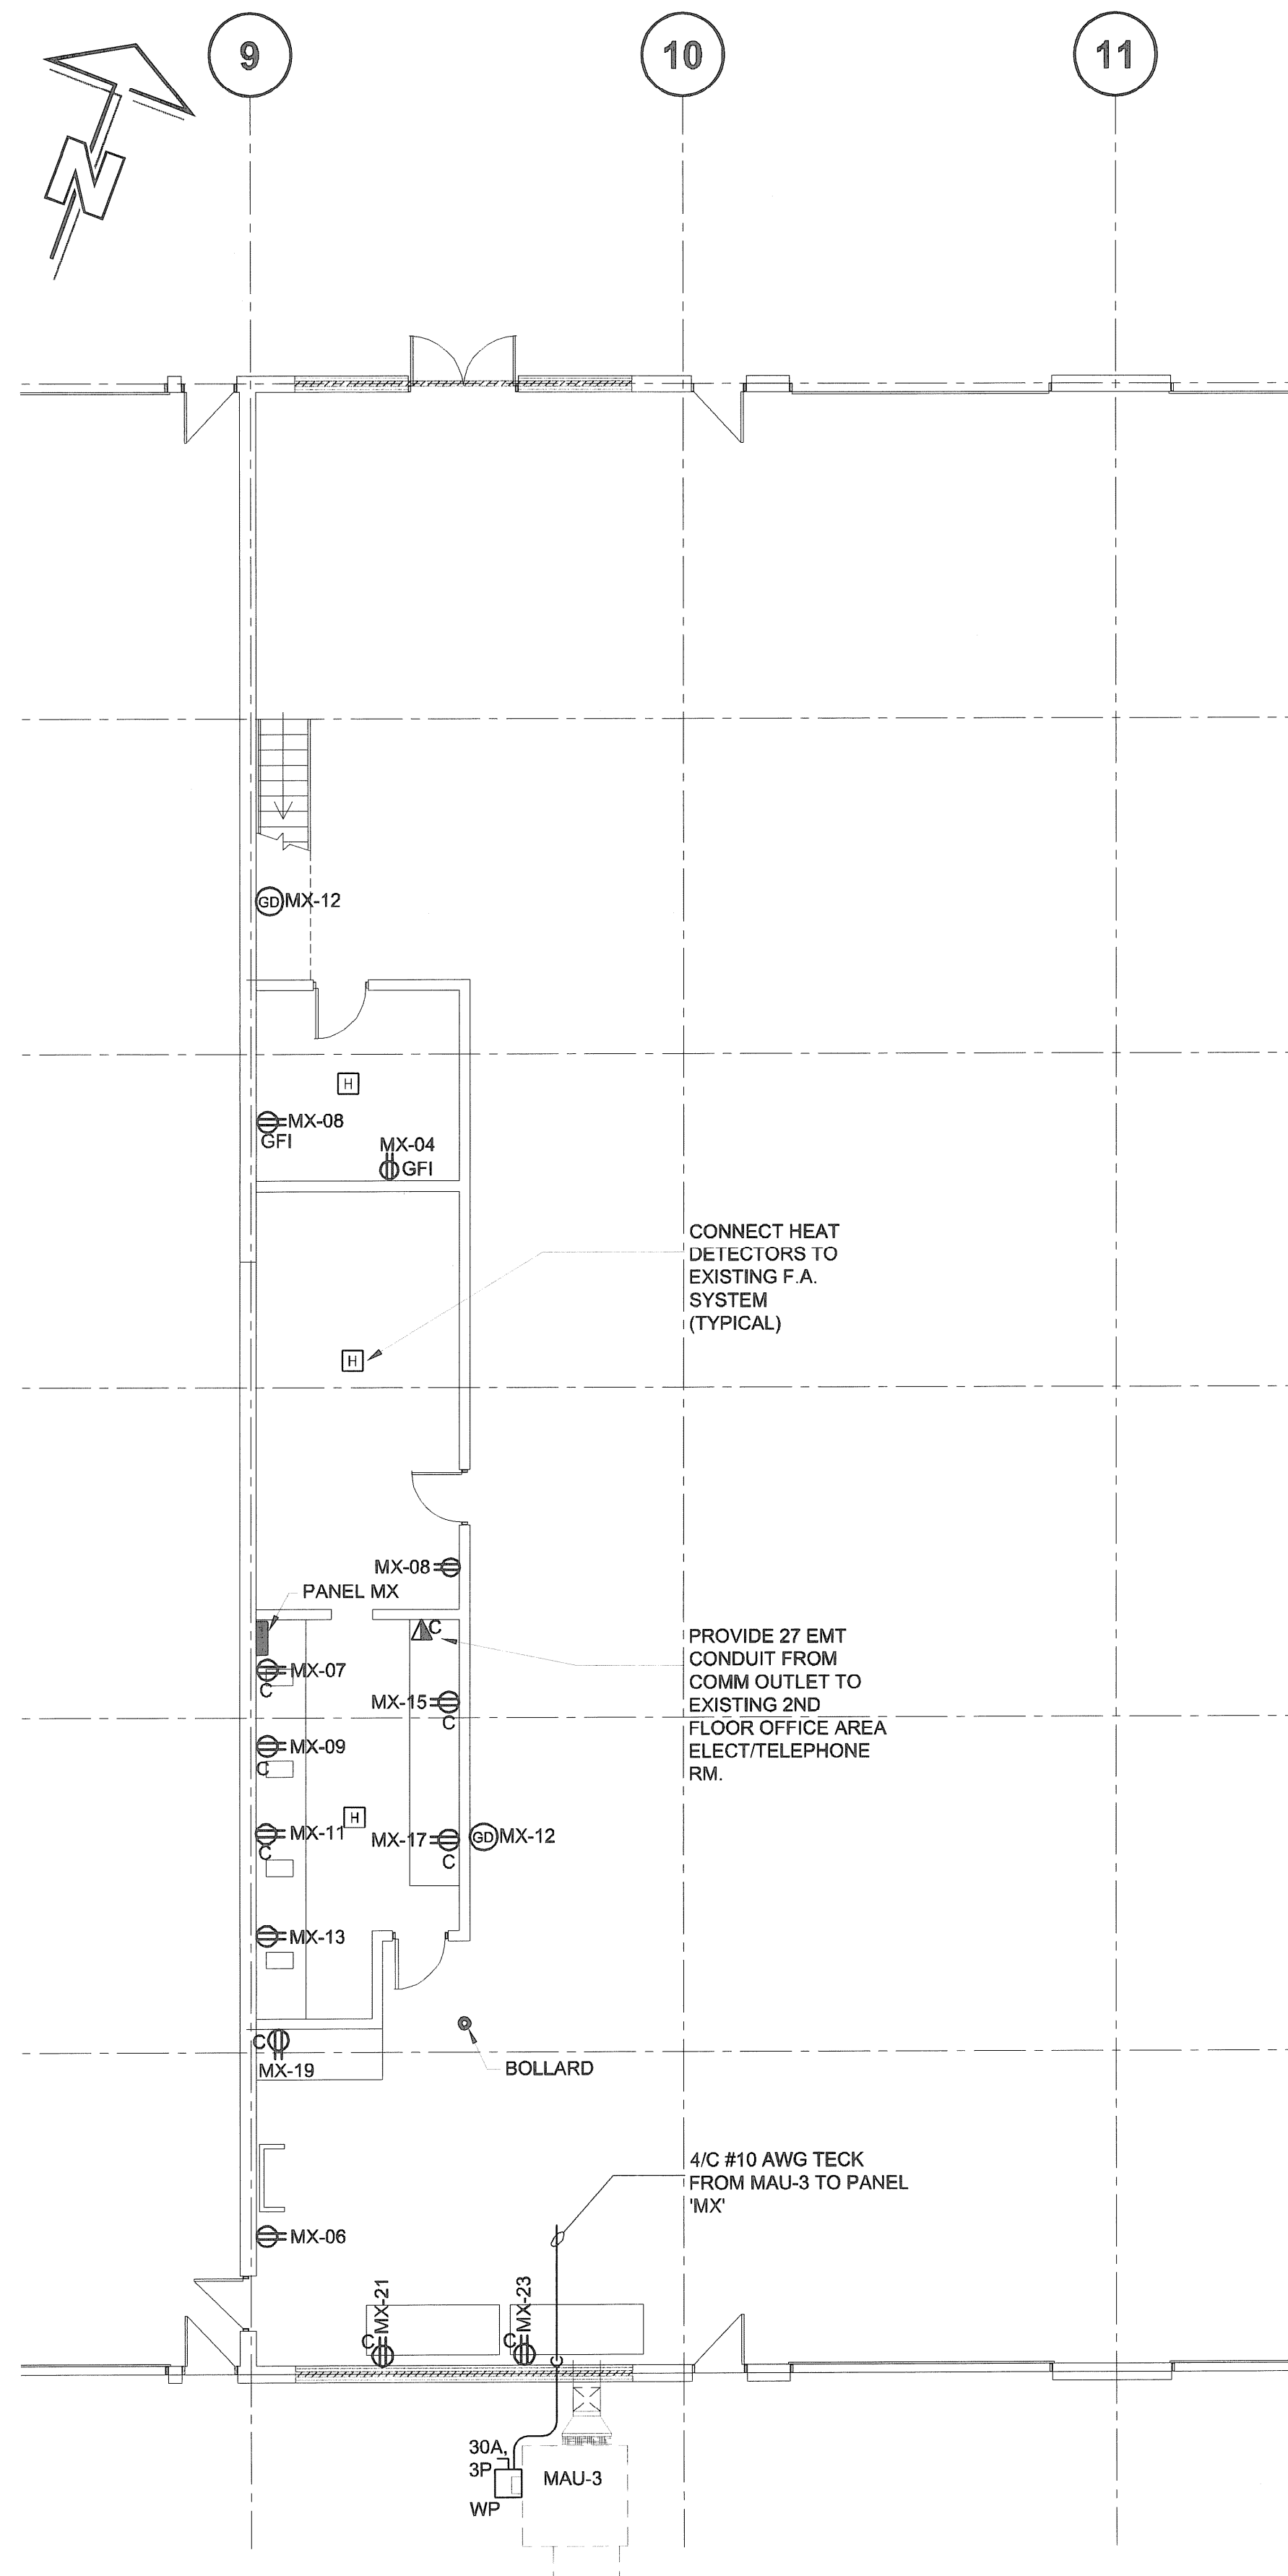

MAIN FLOOR PLAN - POWER

0 1000 2000 3000 mm SCALE 1:100

PANEL 'MX'									
CCT NO	DESCRIPTION	LOAD	TRIP AMPS	N	TRIP AMPS	LOAD	DESCRIPTION	CCT NO	
01	MEZZANINE FLUOR. LTG.		15		15		MEZZANINE RECEPT.	02	
03	WASHROOM & STORAGE RM. LTG		15		15		WASHER RECEPT.	04	
05	WORK BENCH FLUOR. LTG.		15		15		GARAGE RECEPT.	06	
07	WORKBENCH RECEPT.		15		15		WASH. RM. & STOR. RM. RECEPT	08	
09	WORKBENCH RECEPT.		15		15		METASYS CABINET	10	
11	WORKBENCH RECEPT.		15		15		CO & NO2 DETECTORS	12	
13	WORKBENCH RECEPT.		15		15			14	
15	WORKBENCH RECEPT.		15		25		SPARE	16	
17	WORKBENCH RECEPT.		15		3P			18	
19	GARAGE WORKBENCH RECEPT.		15					20	
21	GARAGE WORKBENCH RECEPT.		15		20		MAU-3	22	
23	GARAGE WORKBENCH RECEPT.		15		3P			24	
25					15		SPARE	26	
27	EF-1		25		15		SPARE	28	
29			3P		15		SPARE	30	
31							SPACE	32	
33	SPARE						SPACE	34	
35			25				SPACE	36	
37			3P				SPACE	38	
39	SPARE				25		SPACE	40	
41			3P				SPACE	42	


VOLTAGE: 120/208V PHASE: 3 WIRE: 4 BREAKER I.C.: 10kA
 MAIN BREAKER: - MAINS: 225A FEEDER: 4 #4/0 AWG R90 IN 53C
 MOUNTING: SURFACE LOCATION: GARAGE
 FED FROM: MAIN 2000A DISTRIBUTION

NOTES: -
 -
 -



D	ISSUED FOR TENDER	SCK	07/11/07
C	ISSUED FOR FINAL REVIEW	SCK	07/10/07
B	ISSUED FOR 100% REVIEW	SCK	07/09/07
A	ISSUED FOR CLIENT REVIEW	QL	07/08/07
NO.	REVISION/DESCRIPTION	BY	DATE

SEALS

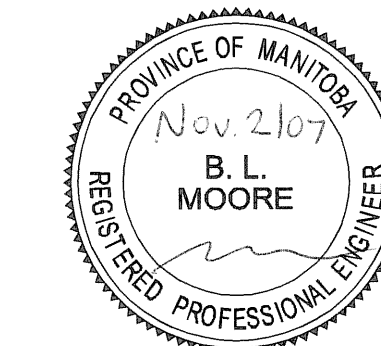

DRAWN BY SCK CHECKED BY - APPROVED -
DATE 2007.05.09 USER APPROVAL

CITY OF WINNIPEG
PLANNING, PROPERTY &
DEVELOPMENT DEPARTMENT
CIVIC ACCOMMODATIONS DIVISION
300 - 65 GARRY ST. R3C 4K4


PROJECT
FORESTRY & LANDSCAPE DEVELOPMENT
FACILITY ENHANCEMENT PROJECT

PROJECT ADDRESS

SHEET TITLE

ELECTRICAL
GARAGE MAIN FLOOR
LIGHTING AND POWER

DRN	CHK	DES	ENG	IDR
UMA AECOM REVIEW				

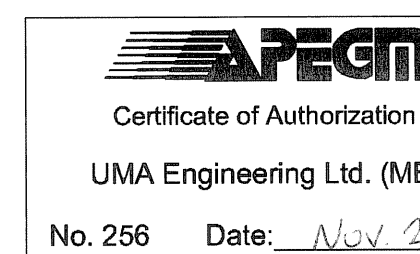

SCALE 1:500 PROJECT NO. 0265-395-02 SHEET NO. GAR-E1.1