

KEY NOTES:

SYMBOL SCHEDULE	
	FLUORESCENT LUMINAIRE ("1" DENOTES TYPE)
	LUMINAIRE ON EMERGENCY / NIGHT LIGHT CIRCUIT
	INCANDESCENT LUMINAIRE
	INCANDESCENT LUMINAIRE WALL MTD.
	SINGLE POLE SWITCH
	2 - GANG SWITCH ("a" & "b" DENOTES SWITCHING)
	3 - WAY SWITCH
	DUPLEX RECEPTACLE
	SPECIAL RECEPTACLE ("A" DENOTES TYPE)
	DIRECT CONNECTION
	MOTOR CONNECTION
	DISCONNECT SWITCH
	POWER PANEL
	SYSTEMS PANEL AS INDICATED
	DATA OUTLET (2 DATA DROPS)
	TELEPHONE OUTLET (1 VOICE DROP)
	ELECTRIC HEATER ("A" DENOTES TYPE)
	THERMOSTAT
	DOOR CONTACT
	SMOKE ALARM (120 VAC)

ABBREVIATIONS	
C	MTD. ABOVE COUNTER
CLG	CEILING MOUNTED
CP	COPIER
CS	MTD. IN CRAWLSPACE
D	DELETE
E	EXISTING
EBB	EMERGENCY BATTERY BANK
EM	EMERGENCY
FX	FAX
GFI	GROUND FAULT INTERRUPTER
PR	PRINTER
R	RELOCATE(D)
WP	WEATHER PROOF
T	THERMOSTAT LINE VOLTAGE



5996

REV DATE (yyyy/mm/dd) DESCRIPTION BY

A 2007/06/18 ISSUED FOR TENDER GD

DRAWINGS AND SPECIFICATIONS, INCLUDING ELECTRIC INFORMATION, AS INSTRUMENTS OF SERVICE ARE THE PROPERTY OF... THE COPYRIGHT IN THE SAME BEING RESERVED TO... NO REPRODUCTION MAY BE MADE WITHOUT THE PERMISSION OF THE ARCHITECT AND WHEN MADE MUST BEAR THEIR NAME. ALL PRINTS ARE TO BE RETURNED TO THE ARCHITECT. THIS DOCUMENT SHALL NOT BE SCALED. FOLLOW GIVEN DIMENSIONS ONLY. THE CONTRACTOR SHALL VERIFY THAT ALL DIMENSIONS AND INFORMATION SHOWN IS CORRECT AND IS HELD RESPONSIBLE FOR REPORTING ANY DISCREPANCY TO THE ARCHITECT PRIOR TO COMMENCEMENT OF THE WORK. VARIATIONS AND MODIFICATIONS TO WORK SHOWN WILL NOT BE ALLOWED WITHOUT THE WRITTEN CONSENT OF THE ARCHITECT. THIS DOCUMENT SHALL NOT BE USED FOR BUILDING PURPOSES UNLESS SEALED AND SIGNED BY THE CONSULTANT.

CONSULTANTS

TECHNIC
DESIGN + MANGEMENT
 125 Wildwood Park, Winnipeg, MB R3T 0E1
 Tel: (204) 475-1085 • Fax: (204) 284-6322



PROJECT TITLE

CITY OF WINNIPEG
TREE NURSERY
 ST. NORBERT MANITOBA


SHEET TITLE

OFFICE STAFF
ELECTRICAL PLAN


SCALE DATE DRAWN FILE

As-Shown 06-20-07 NS 5996

SHEET NUMBER

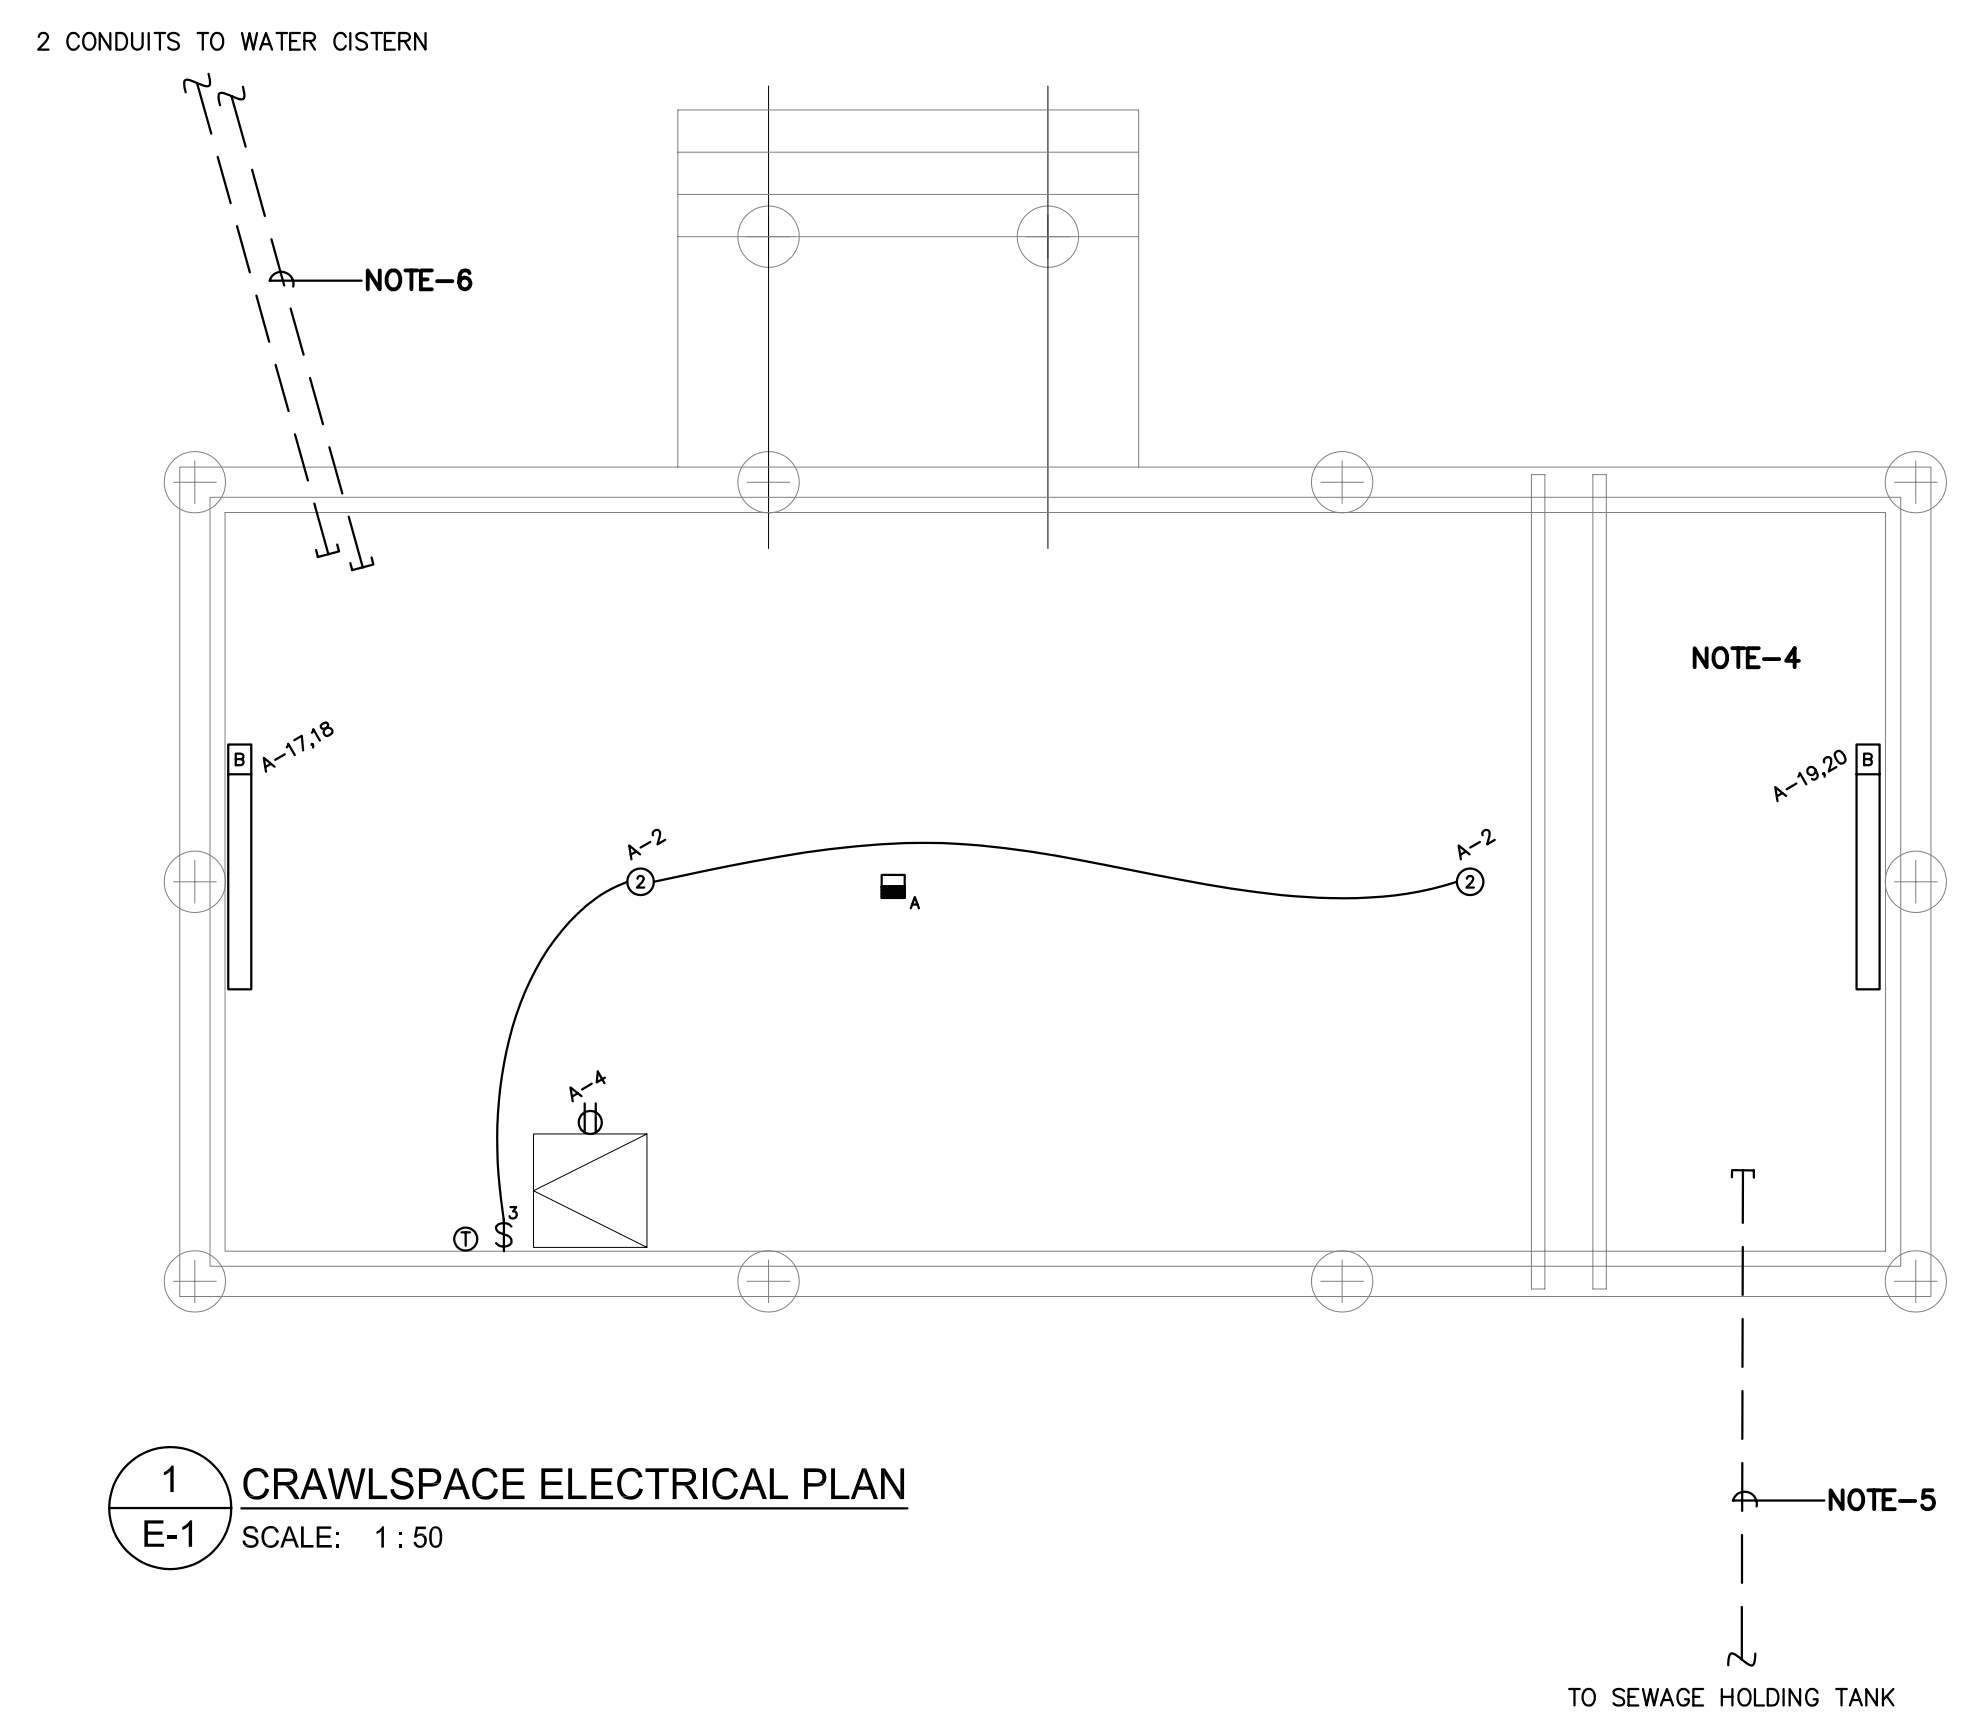

1 CRAWLSPACE ELECTRICAL PLAN
 E-1 SCALE: 1 : 50

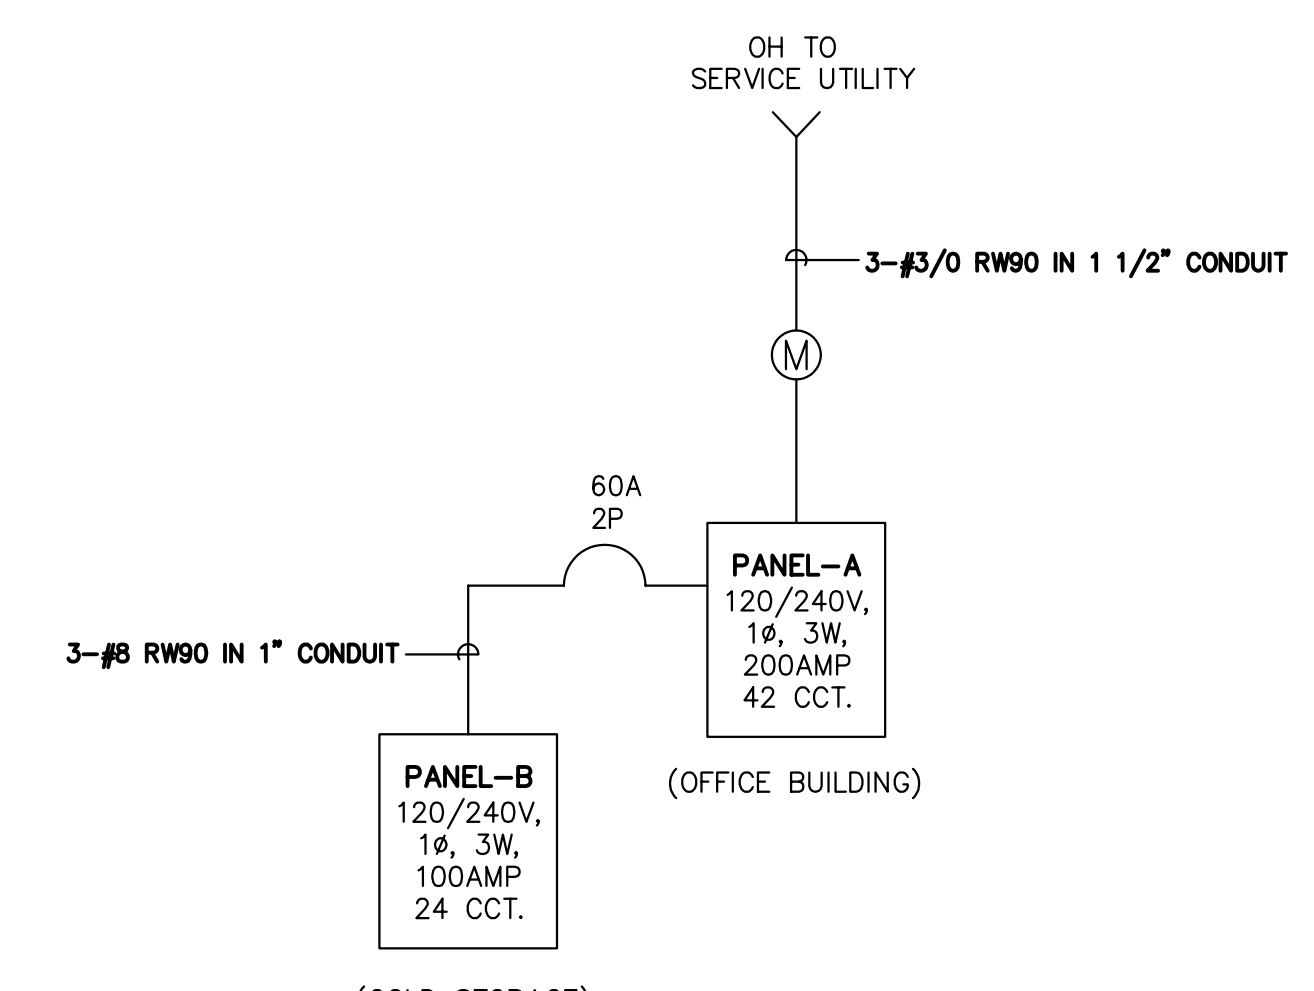

SINGLE LINE DISTRIBUTION
 SCALE: N.T.S.


- NOTES:**
1. NEW OVERHEAD SERVICE TO UTILITY. SEE SINGLE LINE DISTRIBUTION DETAIL.
 2. TELEPHONE DEMARC LOCATION. PROVIDE 1" CONDUIT RUN DOWN TO CRAWLSPACE FOR FUTURE.
 3. PROVIDE 3/4" EMPTY CONDUIT RUN DOWN TO CRAWLSPACE FOR FUTURE.
 4. PROVIDE 1" EMPTY CONDUIT FROM CRAWLSPACE OF OFFICE TO COLD STORAGE C/W PULLWIRE LOCATION SHOWN ON DRAWING E-2.
 5. PROVIDE 3/4" EMPTY CONDUIT STUBBED OUT TO SEWAGE HOLDING TANK FOR HIGH WATER LEVEL ALARM.
 6. PROVIDE 3/4" EMPTY CONDUIT STUBBED OUT TO WATER CISTERN FOR WATER LEVEL ALARM.

LUMINAIRE SCHEDULE:

TYPE	MANUFACTURER	CATALOGUE NO.	VOLTS	LAMPS	REMARKS
1	CFI LITHONIA METALUX PEERLESS	TH248 CLM232-GEB HWA-232-71-EB81 PF-4-232-7100-120-EL	120	2-F32T8	1 x 4 SURFACE MOUNTED WRAPAROUND C/W HOLOPHANE LENS AND ELECTRONIC BALLAST.
2	LIGHTOLIER PRESCOLITE HALO	1102/1178 BX-TL-30 HH7-426C-H930	120	1-60W	RECESSED SHOWER LIGHT C/W GASKETTED DROPPED OPAL DIFFUSER.
3	LITHONIA PRESCOLITE HALO LIGHTOLIER	AF2/26DTT8AR 120 GEB CFR926-S1372EB H7871E9870C 7226H1120/8056CL	120	2-26W	8" APERTURE SPECULAR CLEAR ALZAK, ELECTRONIC BALLAST. COMPACT FLUORESCENT POTLIGHT, RECESSED.
4	LITHONIA LUMARK POWERLITE KEENE	TWP70S120FS HMP-PC-70-12-LL WP2P70S4WL 313070LXL-1/335	120	1-70W HPS	HPS COMMERCIAL WALL PACKS STANDARD FINISH C/W POLYCARBONATE LENS AND BUILT-IN PHOTOCCELL.

HEATER SCHEDULE:

TYPE	MANUFACTURER	CATALOGUE NO.	WATTAGE	VOLTS/Ø	DESCRIPTION
A	OUELLET OR APPROVED EQUAL	F-1000	1kW	240V/1ø	DIRECTLY WIRED TO AN OTE-II ELECTRONIC STAT
B	OUELLET OR APPROVED EQUAL	F-1500	1.5kW	240V/1ø	DIRECTLY WIRED TO AN OTE-II ELECTRONIC STAT
C	OUELLET OR APPROVED EQUAL	F-500-TB1	0.5kW	240V/1ø	RECESSED C/W BUILT-IN THERMOSTAT

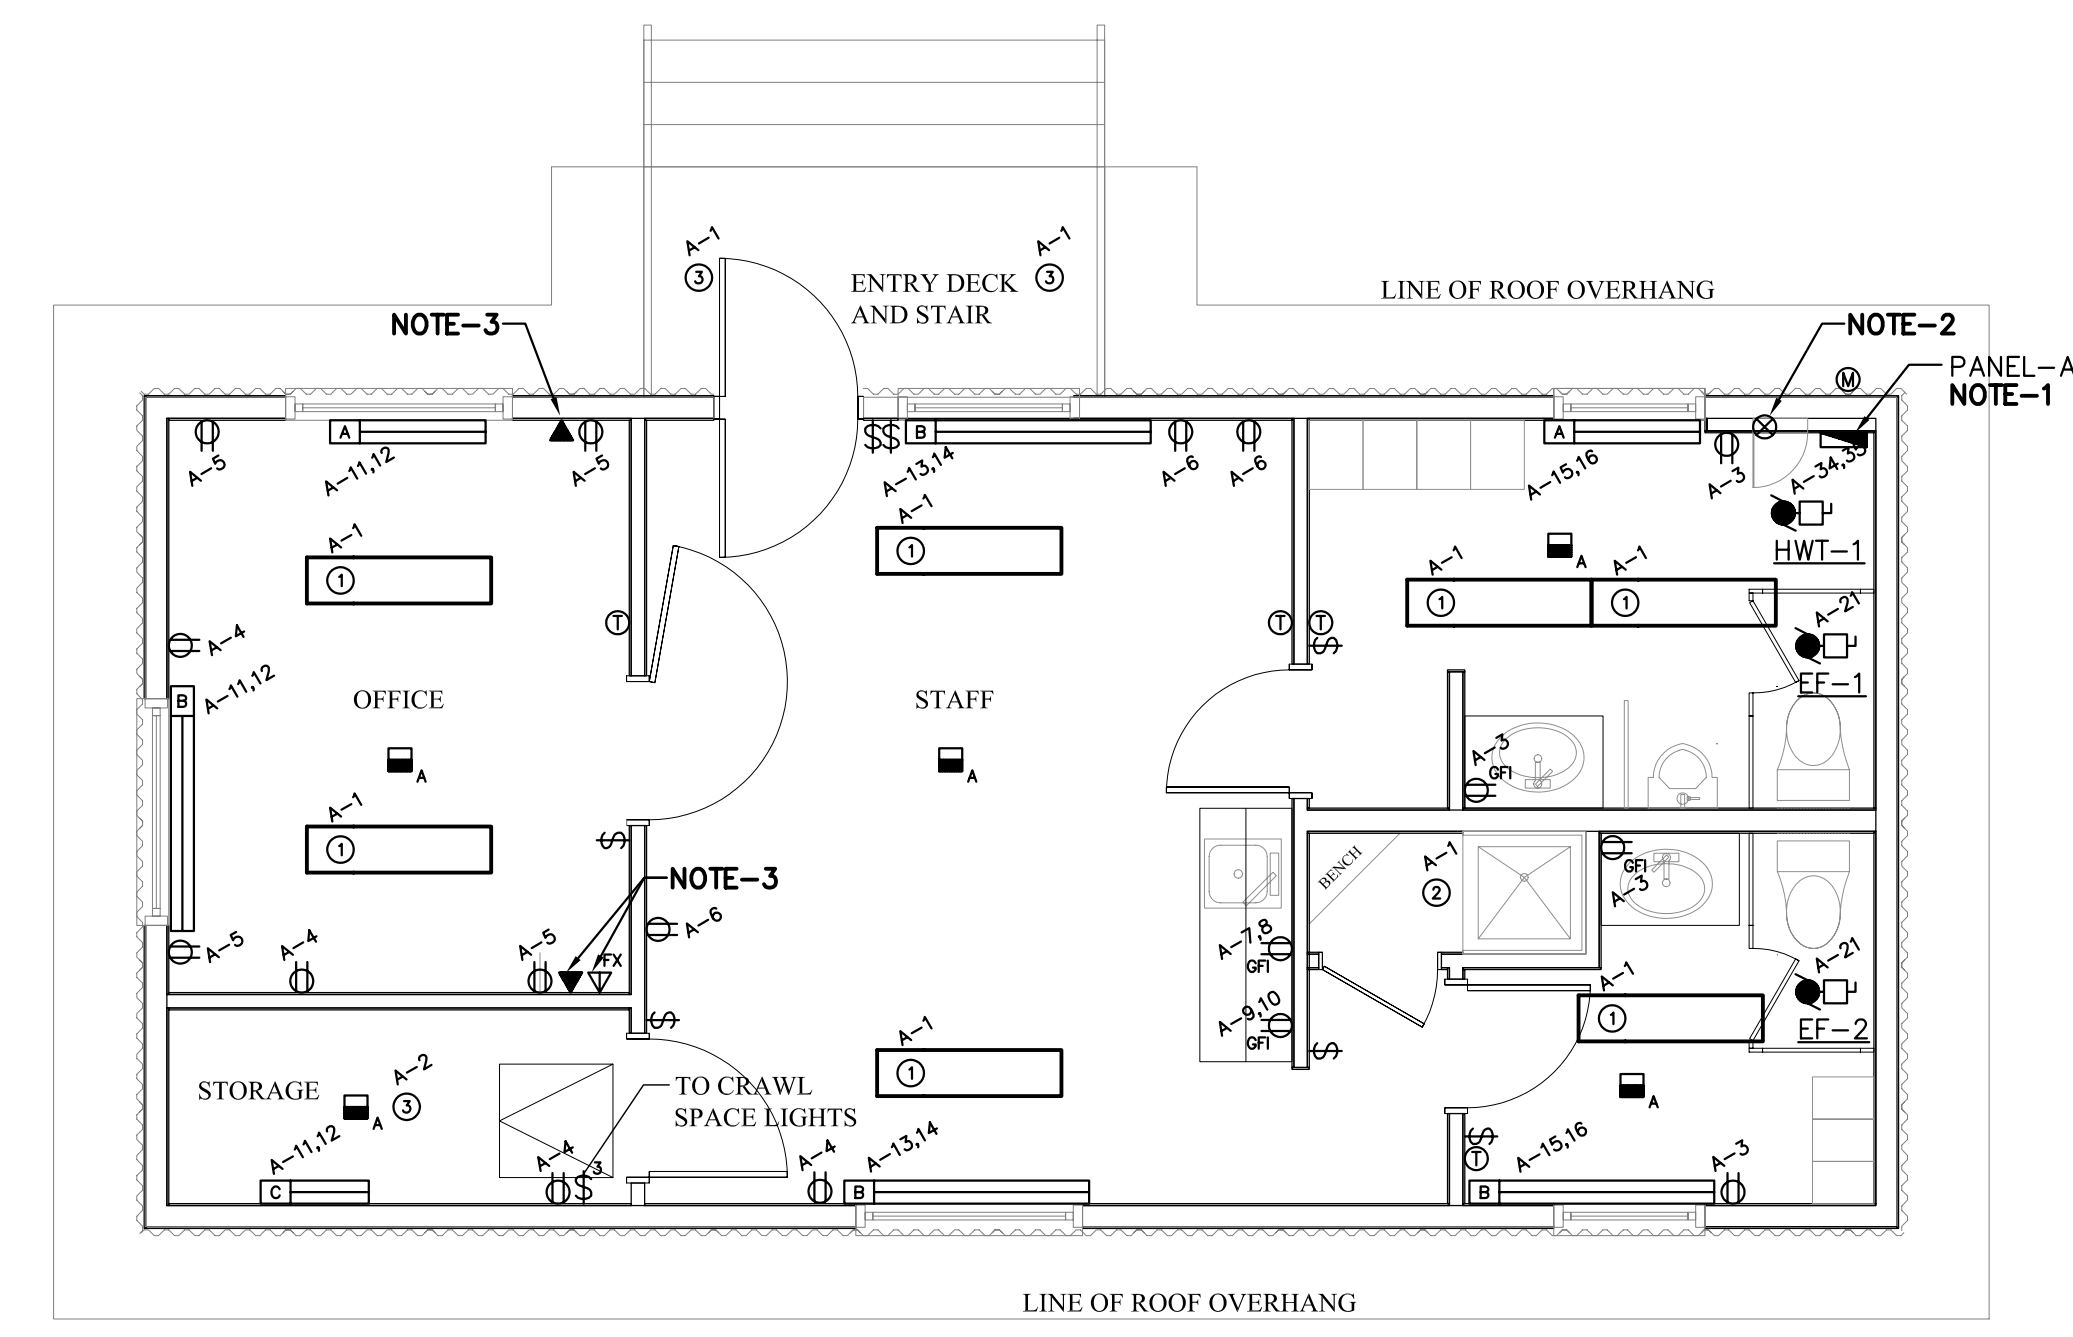

2 OFFICE ELECTRICAL PLAN
 E-1 SCALE: 1 : 50