



D SIZE 22" x 34" (559mm x 864mm)

PLOT: 12/18/2007 10:17:23 AM

NCA FILE NAME: AR\_ELEV2.dwg Saved By: amercico

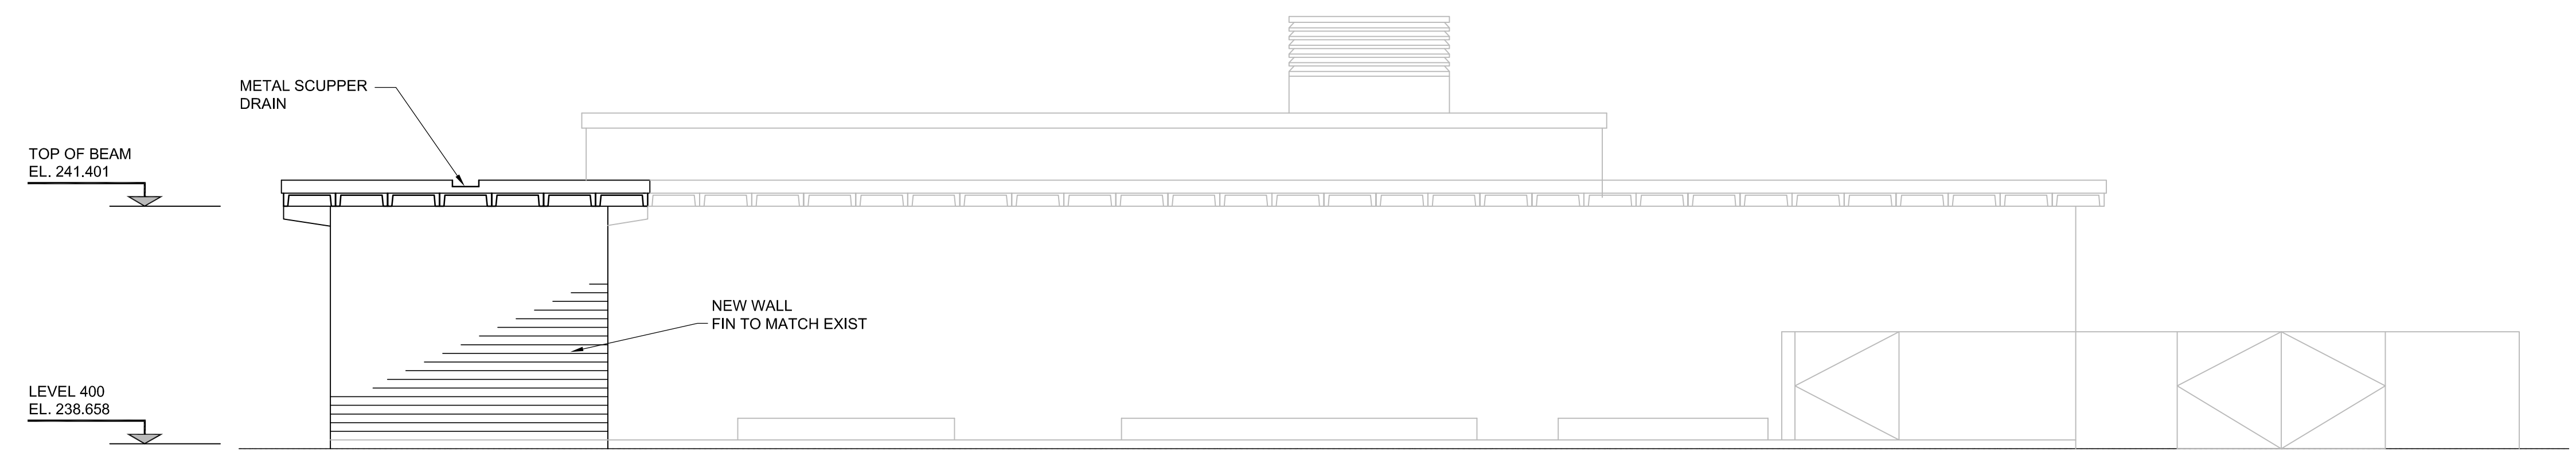

**3 NORTH ELEVATION**  
SCALE: 1:50  
A12

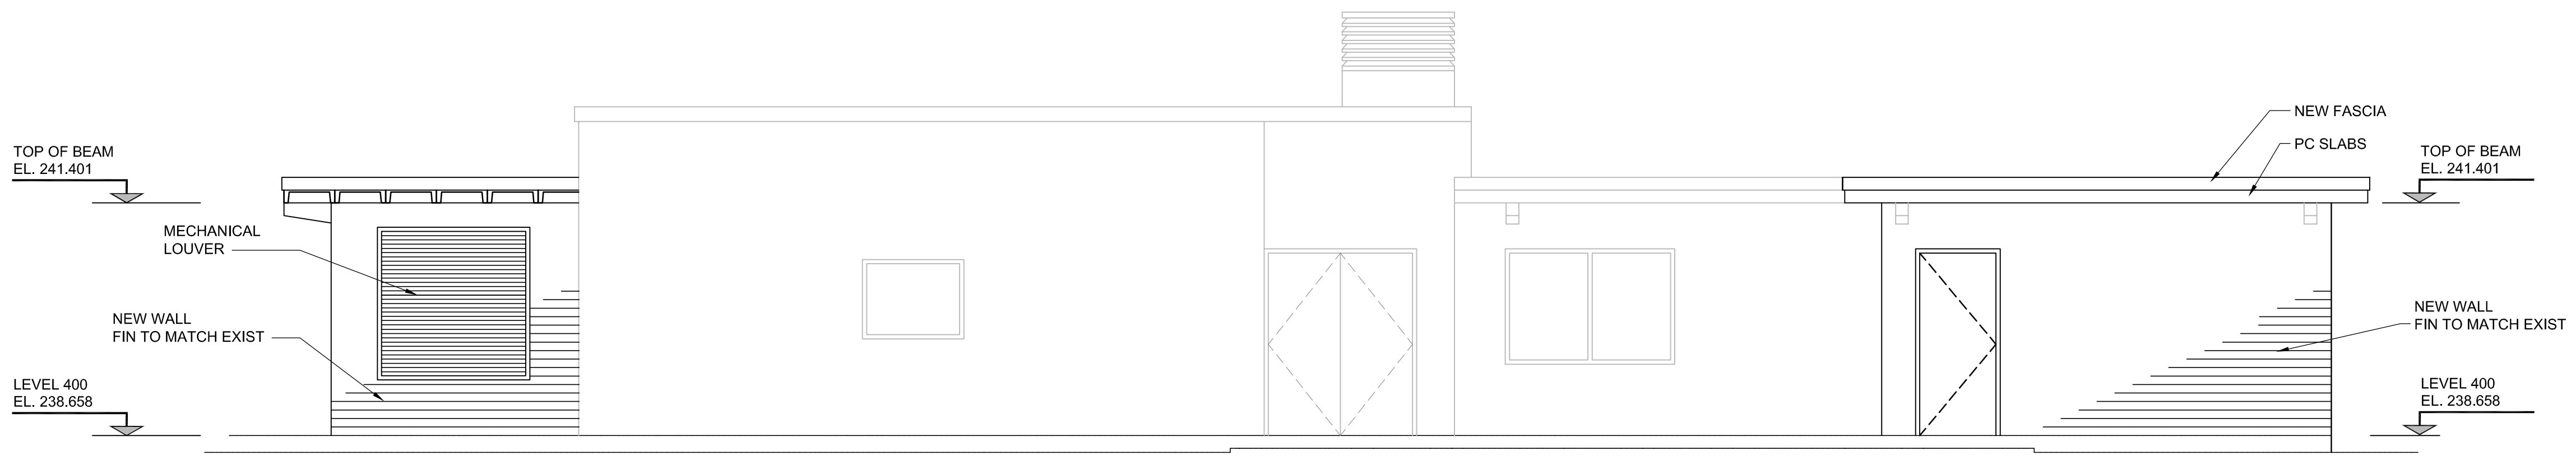

**4 EAST ELEVATION**  
SCALE: 1:50  
A12

**APECM**  
Certificate of Authorization  
UMA Engineering Ltd. (MB)  
No. 256 Date: 07/12/14

B.M. ELEV.	FIELD BOOK #:	Neil Cooper Architect Inc. 10-395 Berry Street, Winnipeg, Manitoba R3J 1N6 Phone (204) 885-3855 Fax (204) 831-7148	
POSTED TO LBIS		DESIGNED BY: <b>NC</b>	CHECKED BY: -
		DRAWN BY: <b>CGC/AL</b>	APPROVED BY: -
		HOR. SCALE: <b>AS NOTED</b>	RELEASED FOR CONSTRUCTION
		VERTICAL: <b>AS NOTED</b>	
<b>A</b>	<b>ISSUED FOR BID</b>	DATE: <b>07/12/14</b>	DATE: <b>07/06/14</b>
NO. REVISIONS	DATE	BY	FILENAME: AR_ELEV2.dwg

ENGINEER'S SEAL  
REVISION - A  
ISSUED FOR BID  
WAS SEALED BY  
NEIL COOPER  
AND DATED  
DEC 14, 2007

**THE CITY OF WINNIPEG**  
WATER AND WASTE DEPARTMENT

**PERIMETER ROAD PUMPING STATION UPGRADES**  
Contract B - Building Upgrades

Architectural - New Construction  
BUILDING ELEVATIONS

CITY DRAWING NUMBER: **1-0111L-A0012** SHEET: **001** REV. **A** SIZE **D**