


**2** PLAN LEVEL 200  
SCALE: 1:50

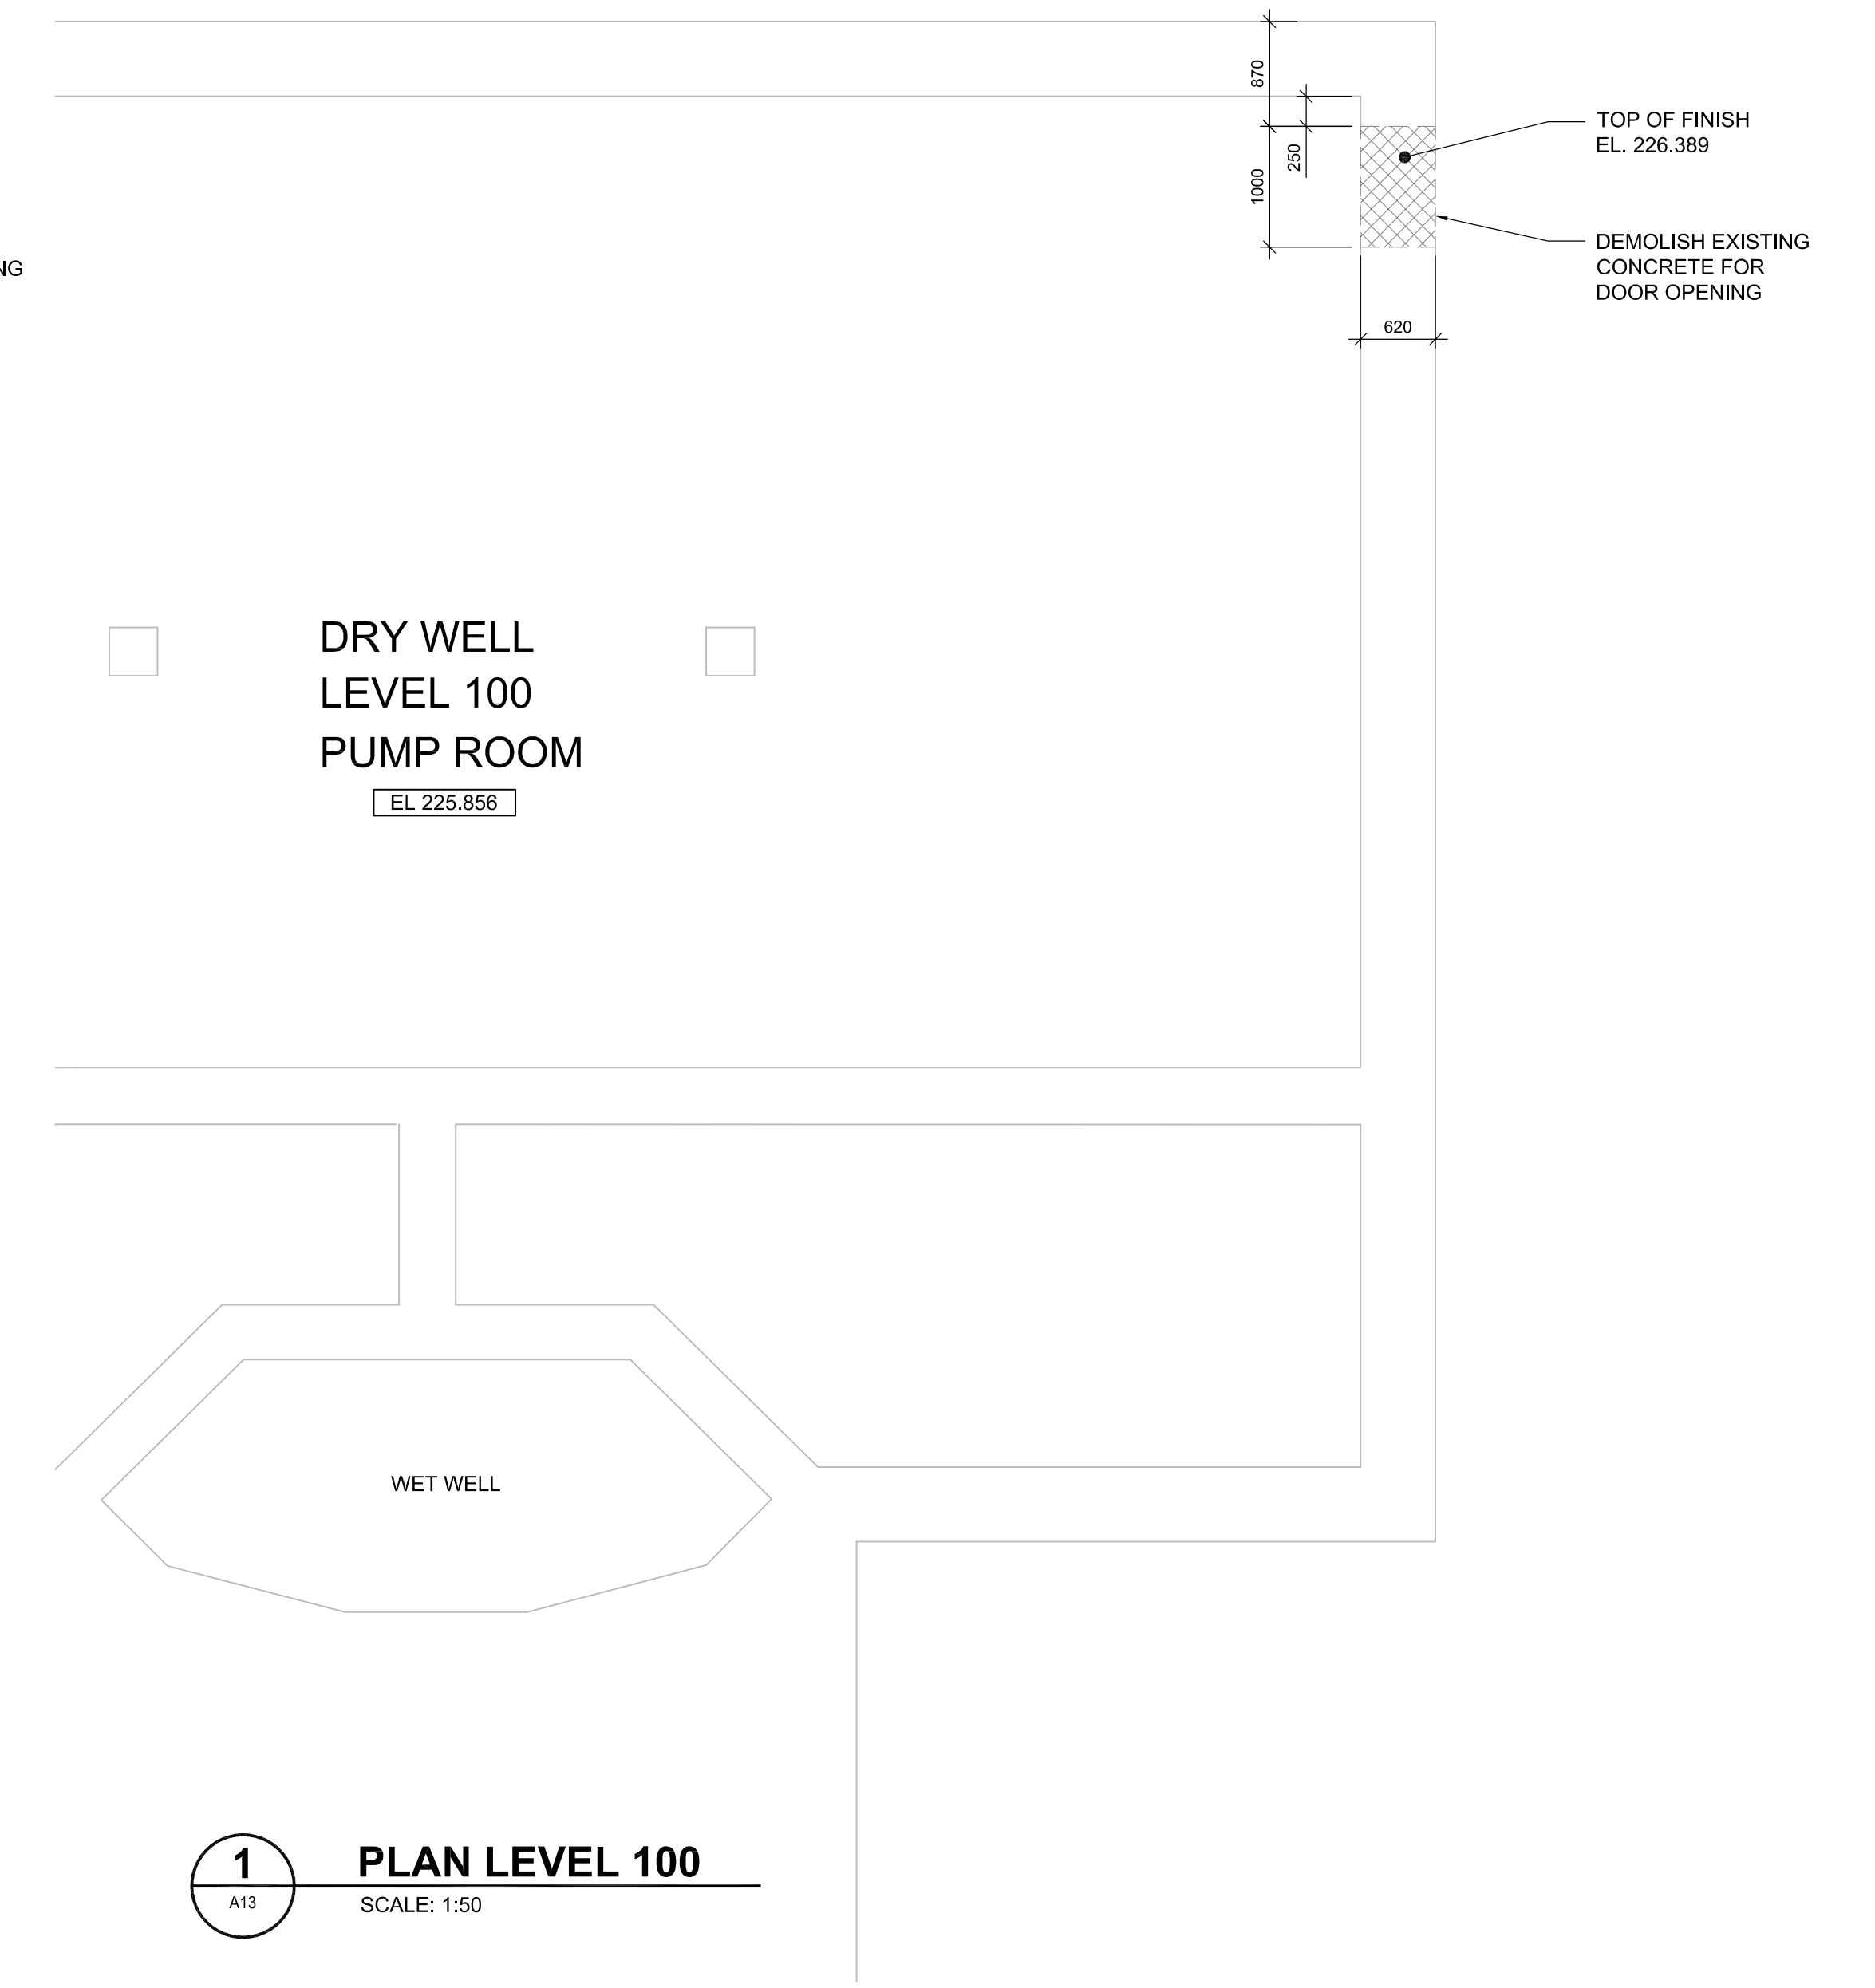

**1** PLAN LEVEL 100  
SCALE: 1:50

**APECM**  
Certificate of Authorization  
UMA Engineering Ltd. (MB)  
No. 256 Date: 07/12/14

**THE CITY OF WINNIPEG**  
WATER AND WASTE DEPARTMENT  
PERIMETER ROAD PUMPING STATION UPGRADES  
Contract B - Building Upgrades  
Architectural - Demolition  
LEVEL 100 & LEVEL 200 FLOOR PLANS  
CITY DRAWING NUMBER: 1-0111L-A0013  
SHEET: 001 REV. A SIZE: D

B.M. ELEV.	FIELD BOOK #:	<b>Neil Cooper Architect Inc.</b> 10-395 Berry Street, Winnipeg, Manitoba R3J 1N6 Phone (204) 885-3855 Fax (204) 831-7148	
POSTED TO LBIS		DESIGNED BY: <b>NC</b>	CHECKED BY: -
		DRAWN BY: <b>CGC/AL</b>	APPROVED BY: -
		HOR. SCALE: <b>AS NOTED</b>	RELEASED FOR CONSTRUCTION
		VERTICAL: <b>AS NOTED</b>	
<b>A</b> ISSUED FOR BID	07/12/14	AL	DATE: 07/06/14
NO. REVISIONS	DATE	BY	FILENAME: AR DEMO.dwg

ENGINEER'S SEAL  
REVISION - A  
ISSUED FOR BID  
WAS SEALED BY  
NEIL COOPER  
AND DATED  
DEC 14, 2007