


D SIZE 22" x 34" (559mm x 864mm)

PLOT: 07/12/18 9:52:12 AM

UMA FILE NAME: D265-202-02_00-E-0003_RX.dwg Saved By: djl

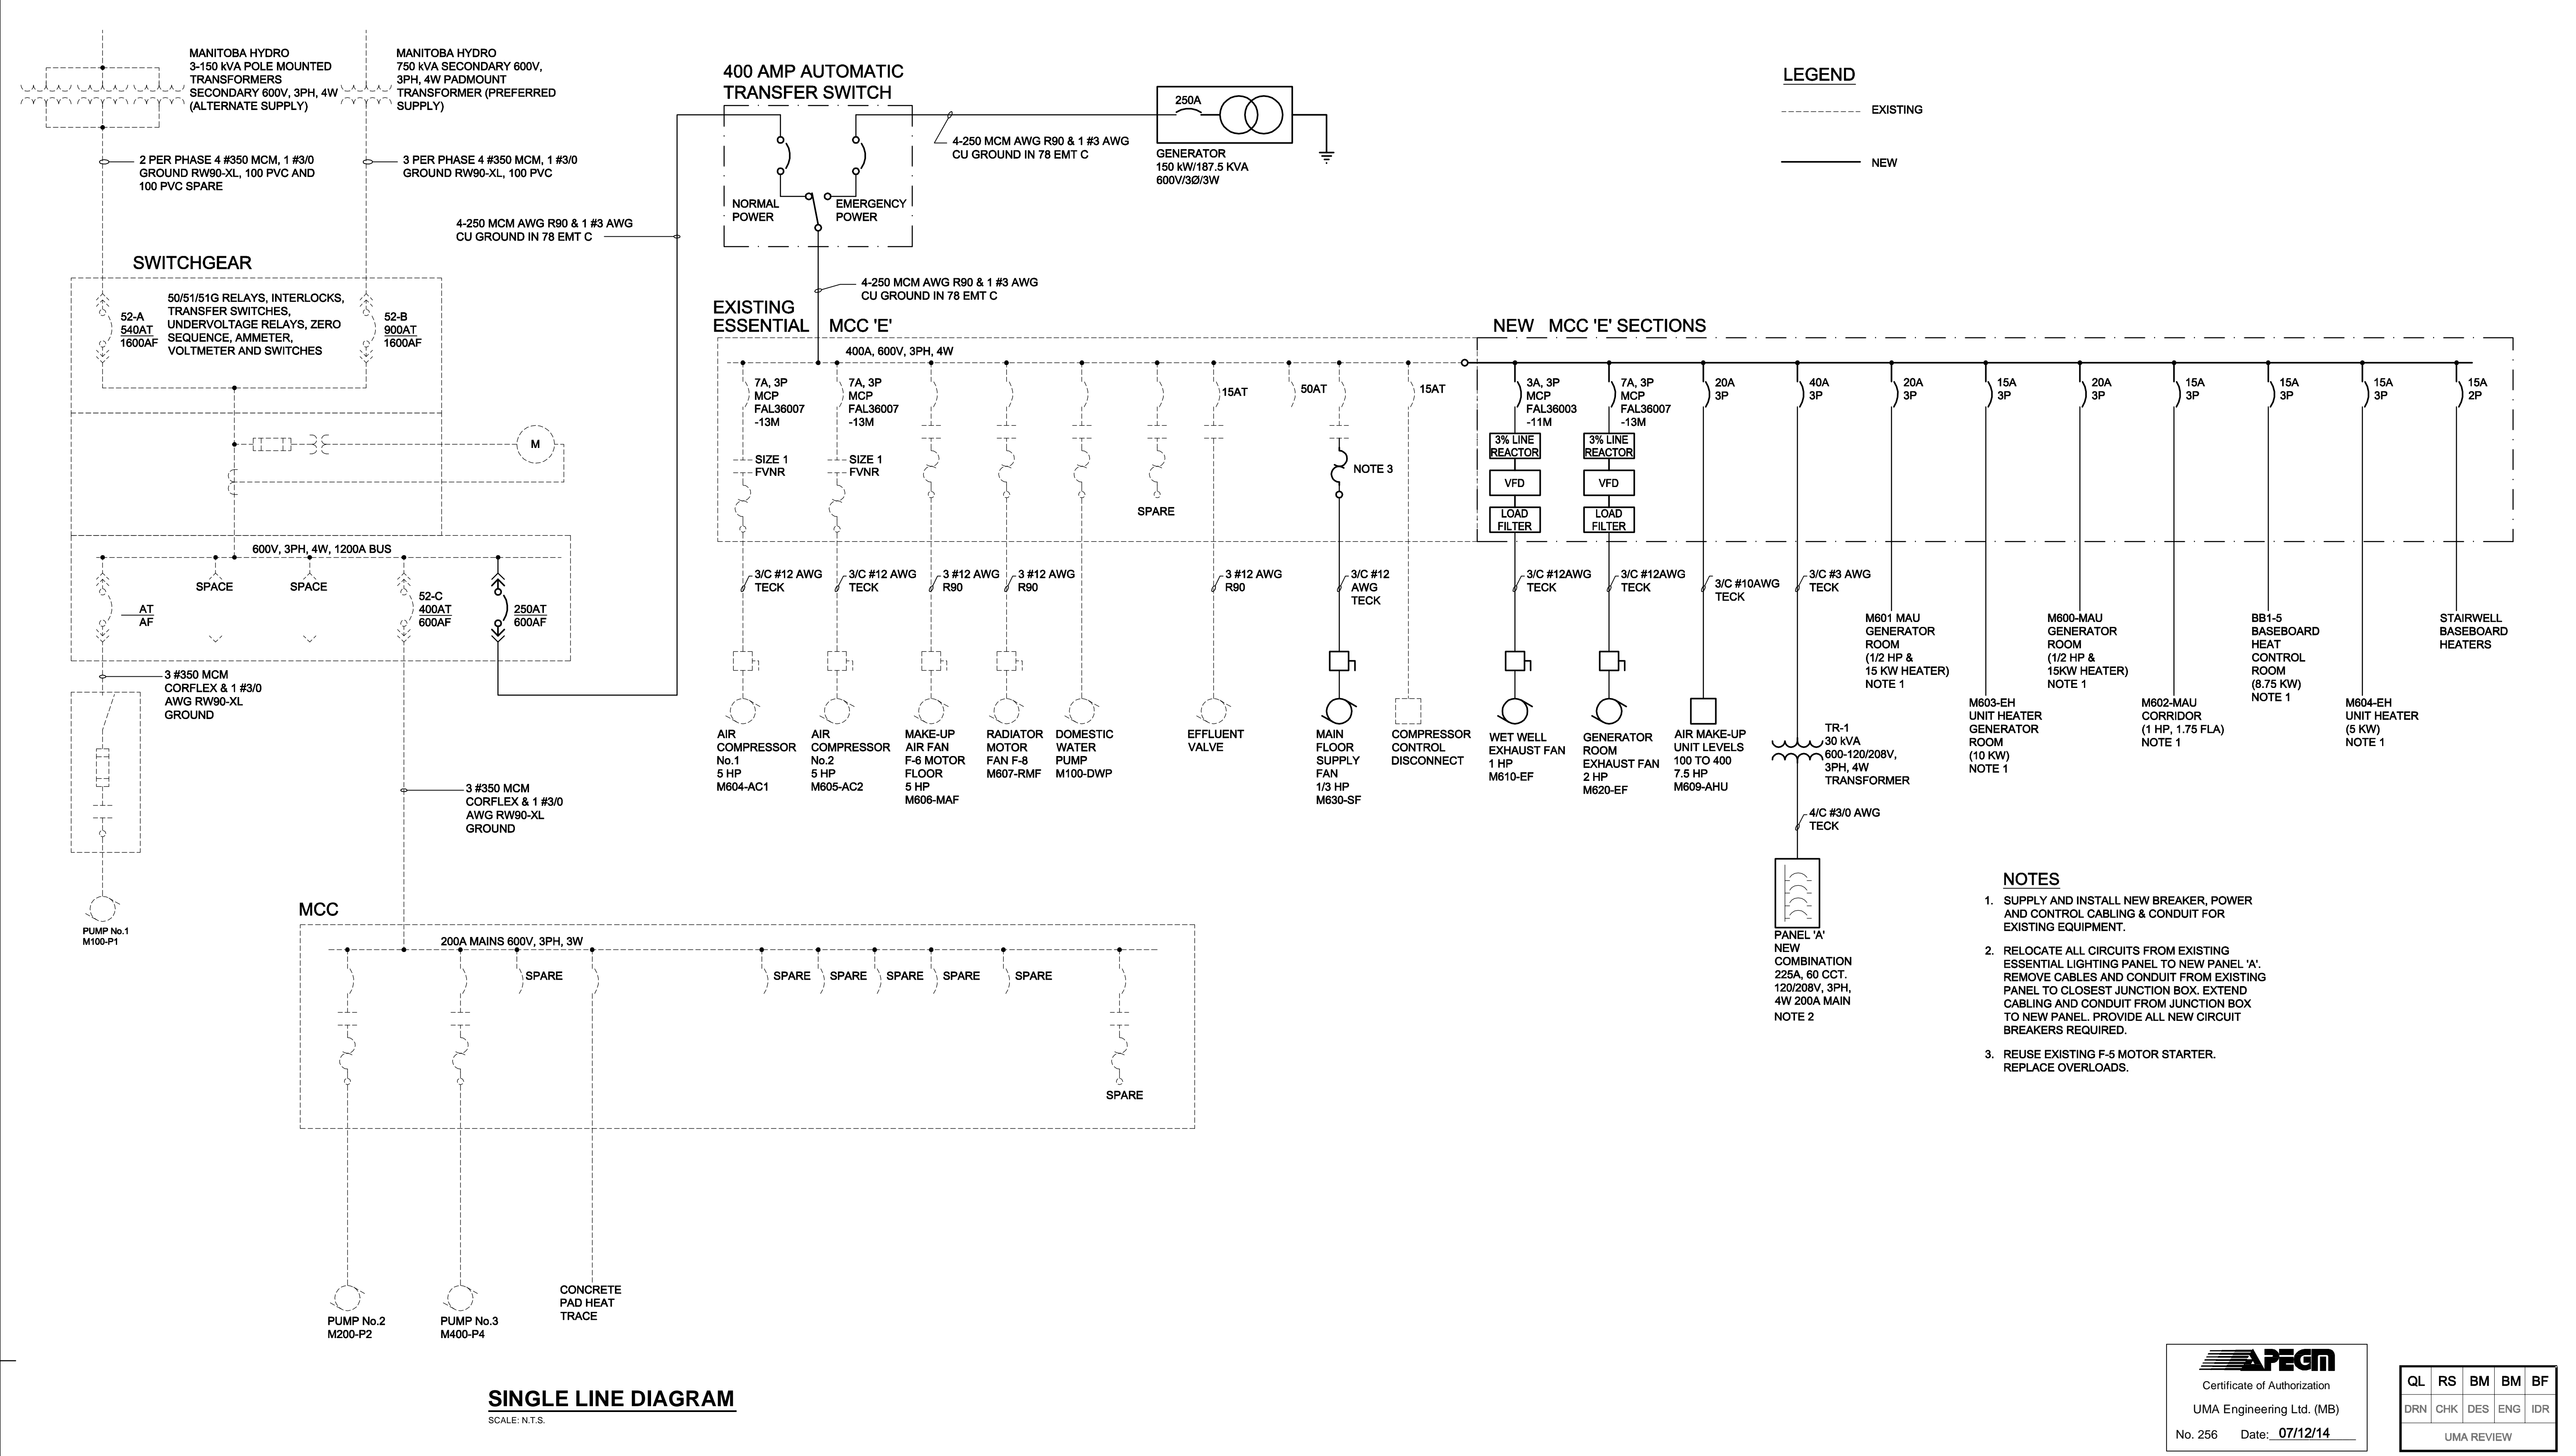

SINGLE LINE DIAGRAM
 SCALE: N.T.S.

APECM
 Certificate of Authorization
 UMA Engineering Ltd. (MB)
 No. 256 Date: 07/12/14

QL	RS	BM	BM	BF
DRN	CHK	DES	ENG	IDR
UMA REVIEW				

B.M. ELEV.	FIELD BOOK #:	UMA AECOM	
POSTED TO LBIS		DESIGNED BY BLM	CHECKED BY
		DRAWN BY QL	APPROVED BY
D ISSUED FOR BID	07/12/14	LJV	
C ISSUED FOR 100% REVIEW	07/11/09	SCK	
B ISSUED FOR ZONING	07/08/21	SCK	
A ISSUED FOR 80% REVIEW	07/06/18	SCK	
NO. REVISIONS	DATE	BY	FILENAME: D265-202-02_00-E-0003_RX.dwg

© 2009 UMA ENGINEERING LTD. ALL RIGHTS RESERVED.	
HOR. SCALE AS NOTED	RELEASED FOR CONSTRUCTION
VERTICAL AS NOTED	
DATE: 07/04/23	DATE

ENGINEER'S SEAL
 ISSUE / REVISION D
 ISSUED FOR BID
 WAS SEALED BY
 B.L. MOORE
 AND DATED
 07/12/14

THE CITY OF WINNIPEG
 WATER AND WASTE DEPARTMENT

PERIMETER ROAD PUMPING STATION UPGRADES
 Contract B - Building Upgrades

Electrical
 SINGLE LINE DIAGRAM

CITY DRAWING NUMBER	SHEET	REV.	SIZE
1-0111L-E0002	001	D	D