
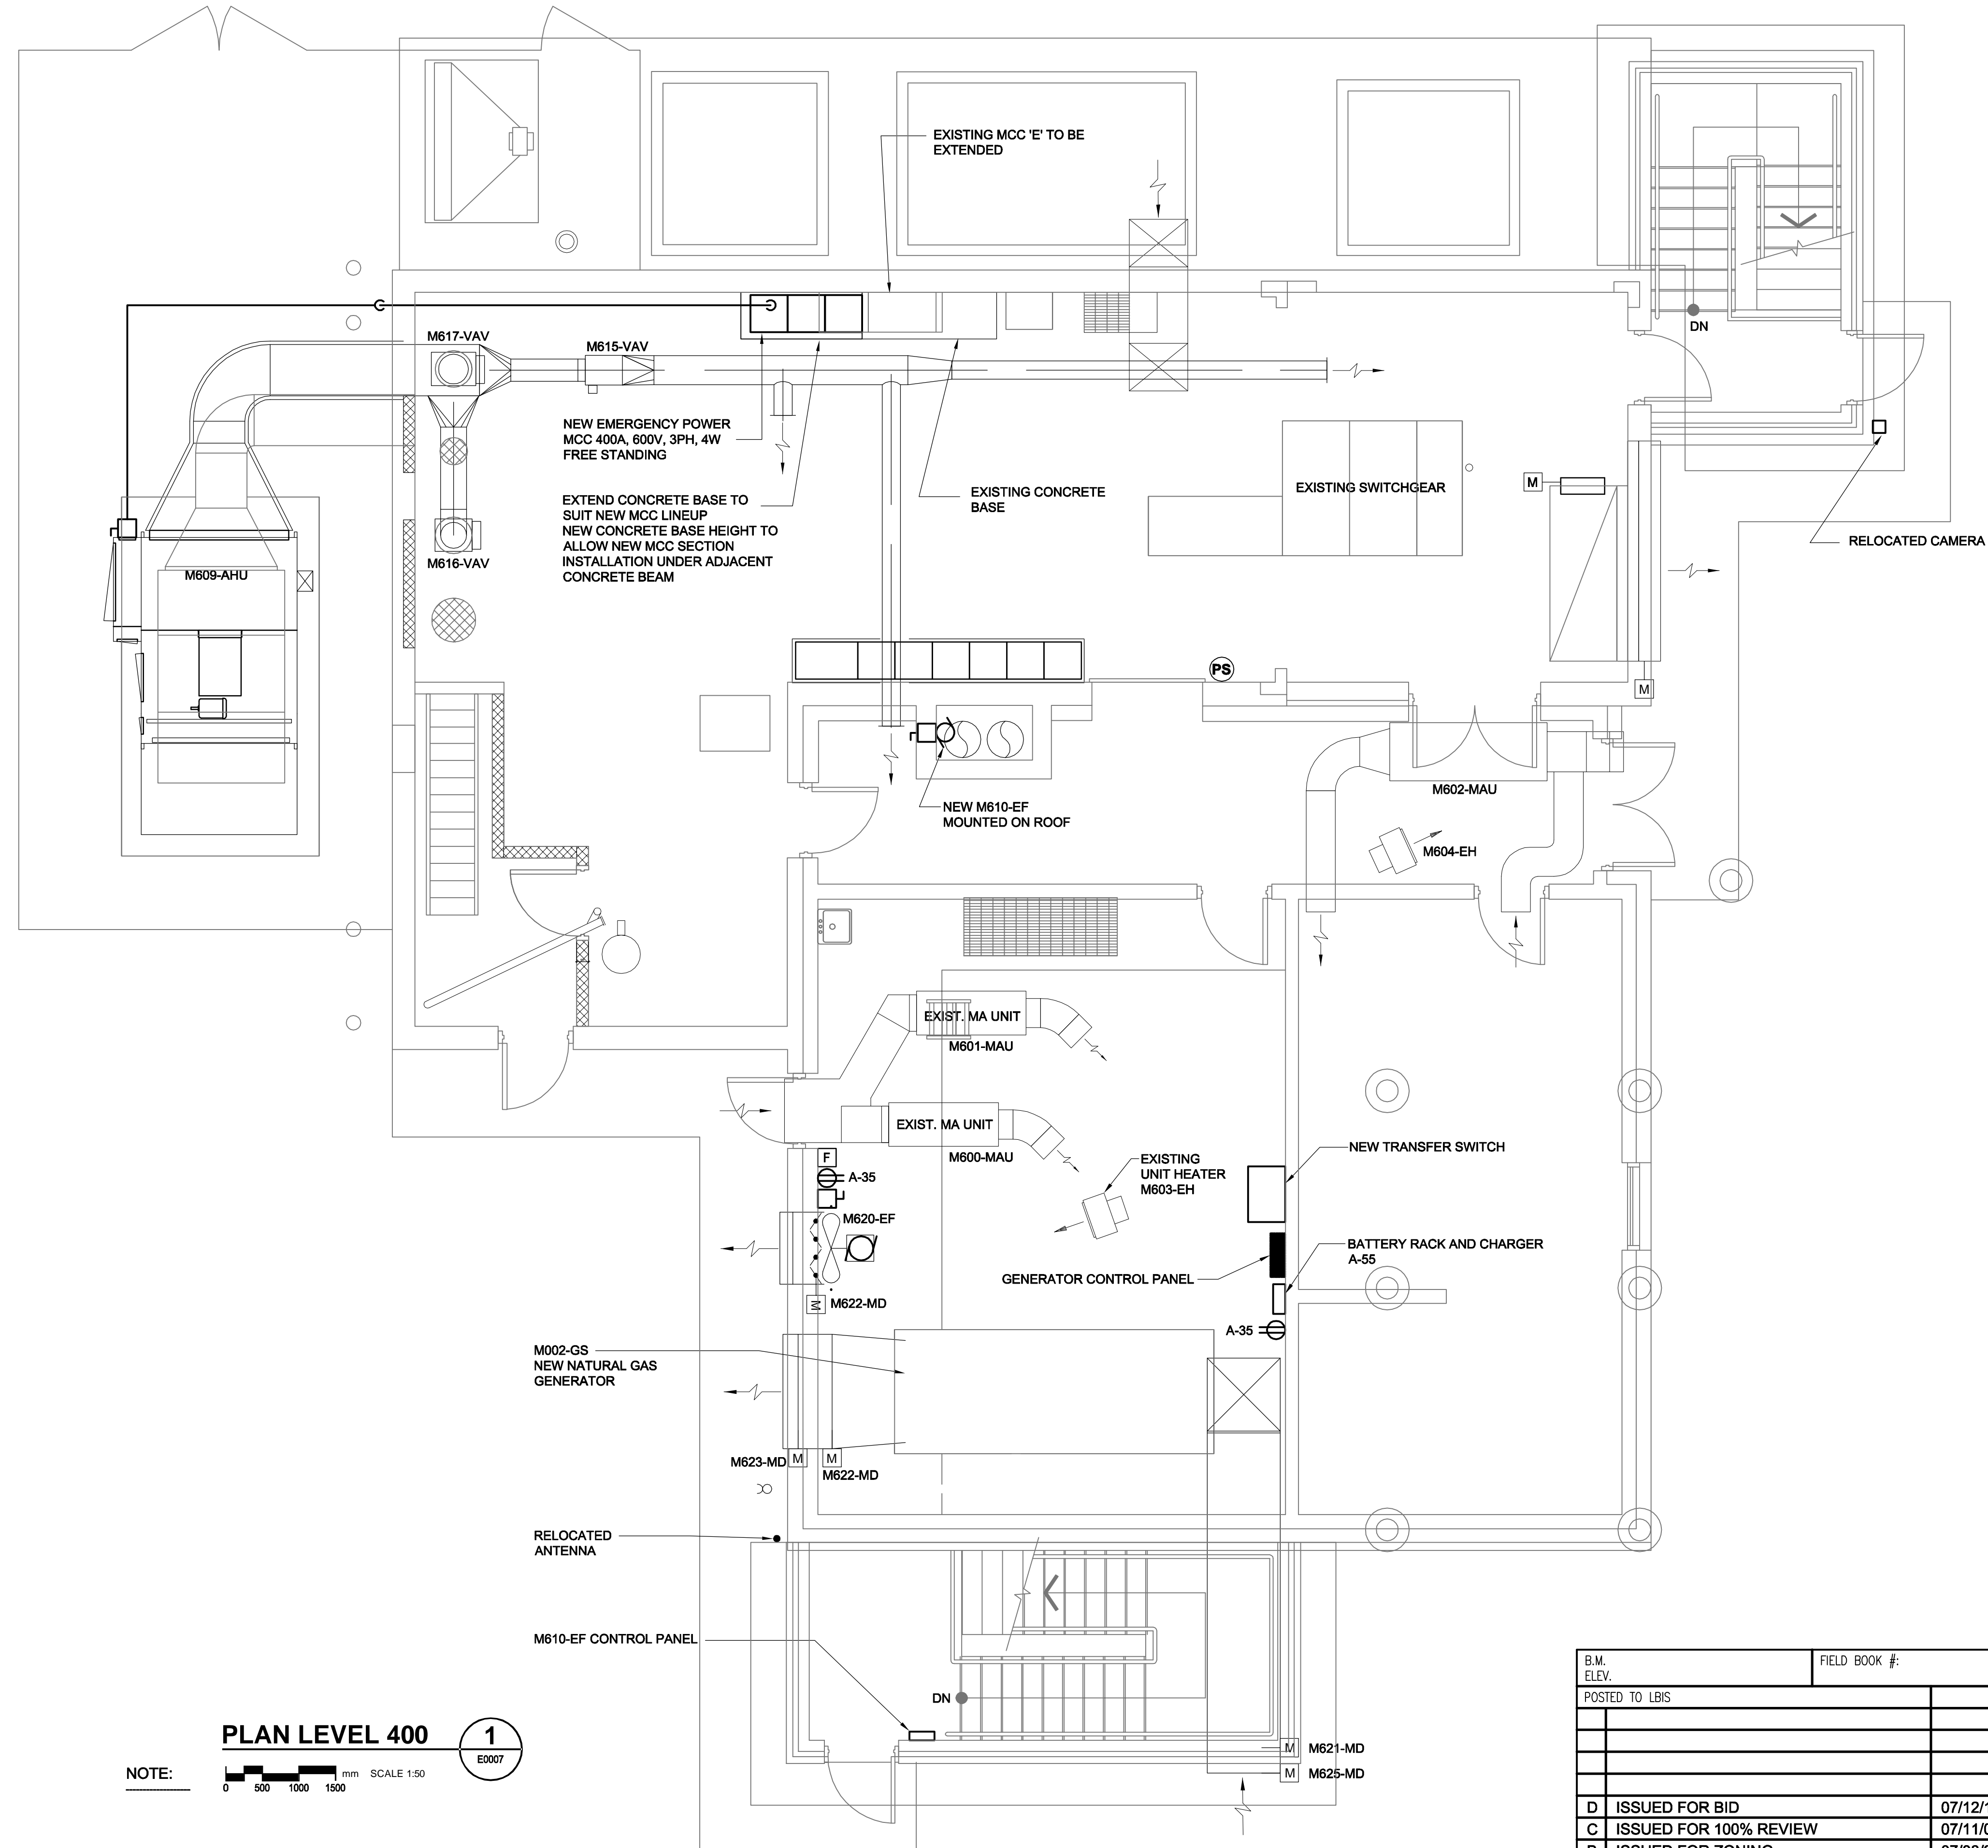


D SIZE 22" x 34" 659mm x 864mm

PLOT: 07/12/14 9:05:17 AM

UMA FILE NAME: D265-202-02_01-E-0401_RX.dwg Saved By: dll

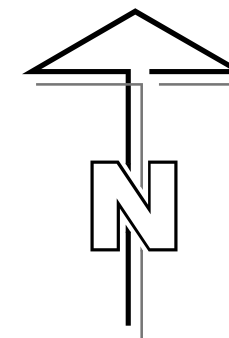

PLAN LEVEL 400 **1**
E0007

NOTE: 0 500 1000 1500 mm SCALE 1:50

APEGM
Certificate of Authorization
UMA Engineering Ltd. (MB)
No. 256 Date: 07/12/14

QL	RS	BM	BM	BF
DRN	CHK	DES	ENG	IDR
UMA REVIEW				

B.M. ELEV.	FIELD BOOK #:	UMA AECOM	
POSTED TO LBIS		DESIGNED BY BM/LK	CHECKED BY -----
		DRAWN BY SCK	APPROVED BY -
D ISSUED FOR BID	07/12/14	LJV	
C ISSUED FOR 100% REVIEW	07/11/09	SCK	
B ISSUED FOR ZONING	07/08/21	SCK	
A ISSUED FOR 80% REVIEW	07/06/18	SCK	
NO. REVISIONS	DATE	BY	FILENAME: D265-202-02_01-E-0401_RX.dwg

ENGINEER'S SEAL	ISSUE / REVISION D
	ISSUED FOR BID
	WAS SEALED BY
	B.L. MOORE
	AND DATED
	07/12/14

THE CITY OF WINNIPEG
WATER AND WASTE DEPARTMENT

PERIMETER ROAD PUMPING STATION UPGRADES
Contract B - Building Upgrades

Electrical - Power Layout
LEVEL 400 FLOOR PLAN

CITY DRAWING NUMBER: **1-0111L-E0006** SHEET: **001** REV: **D** SIZE: **D**